
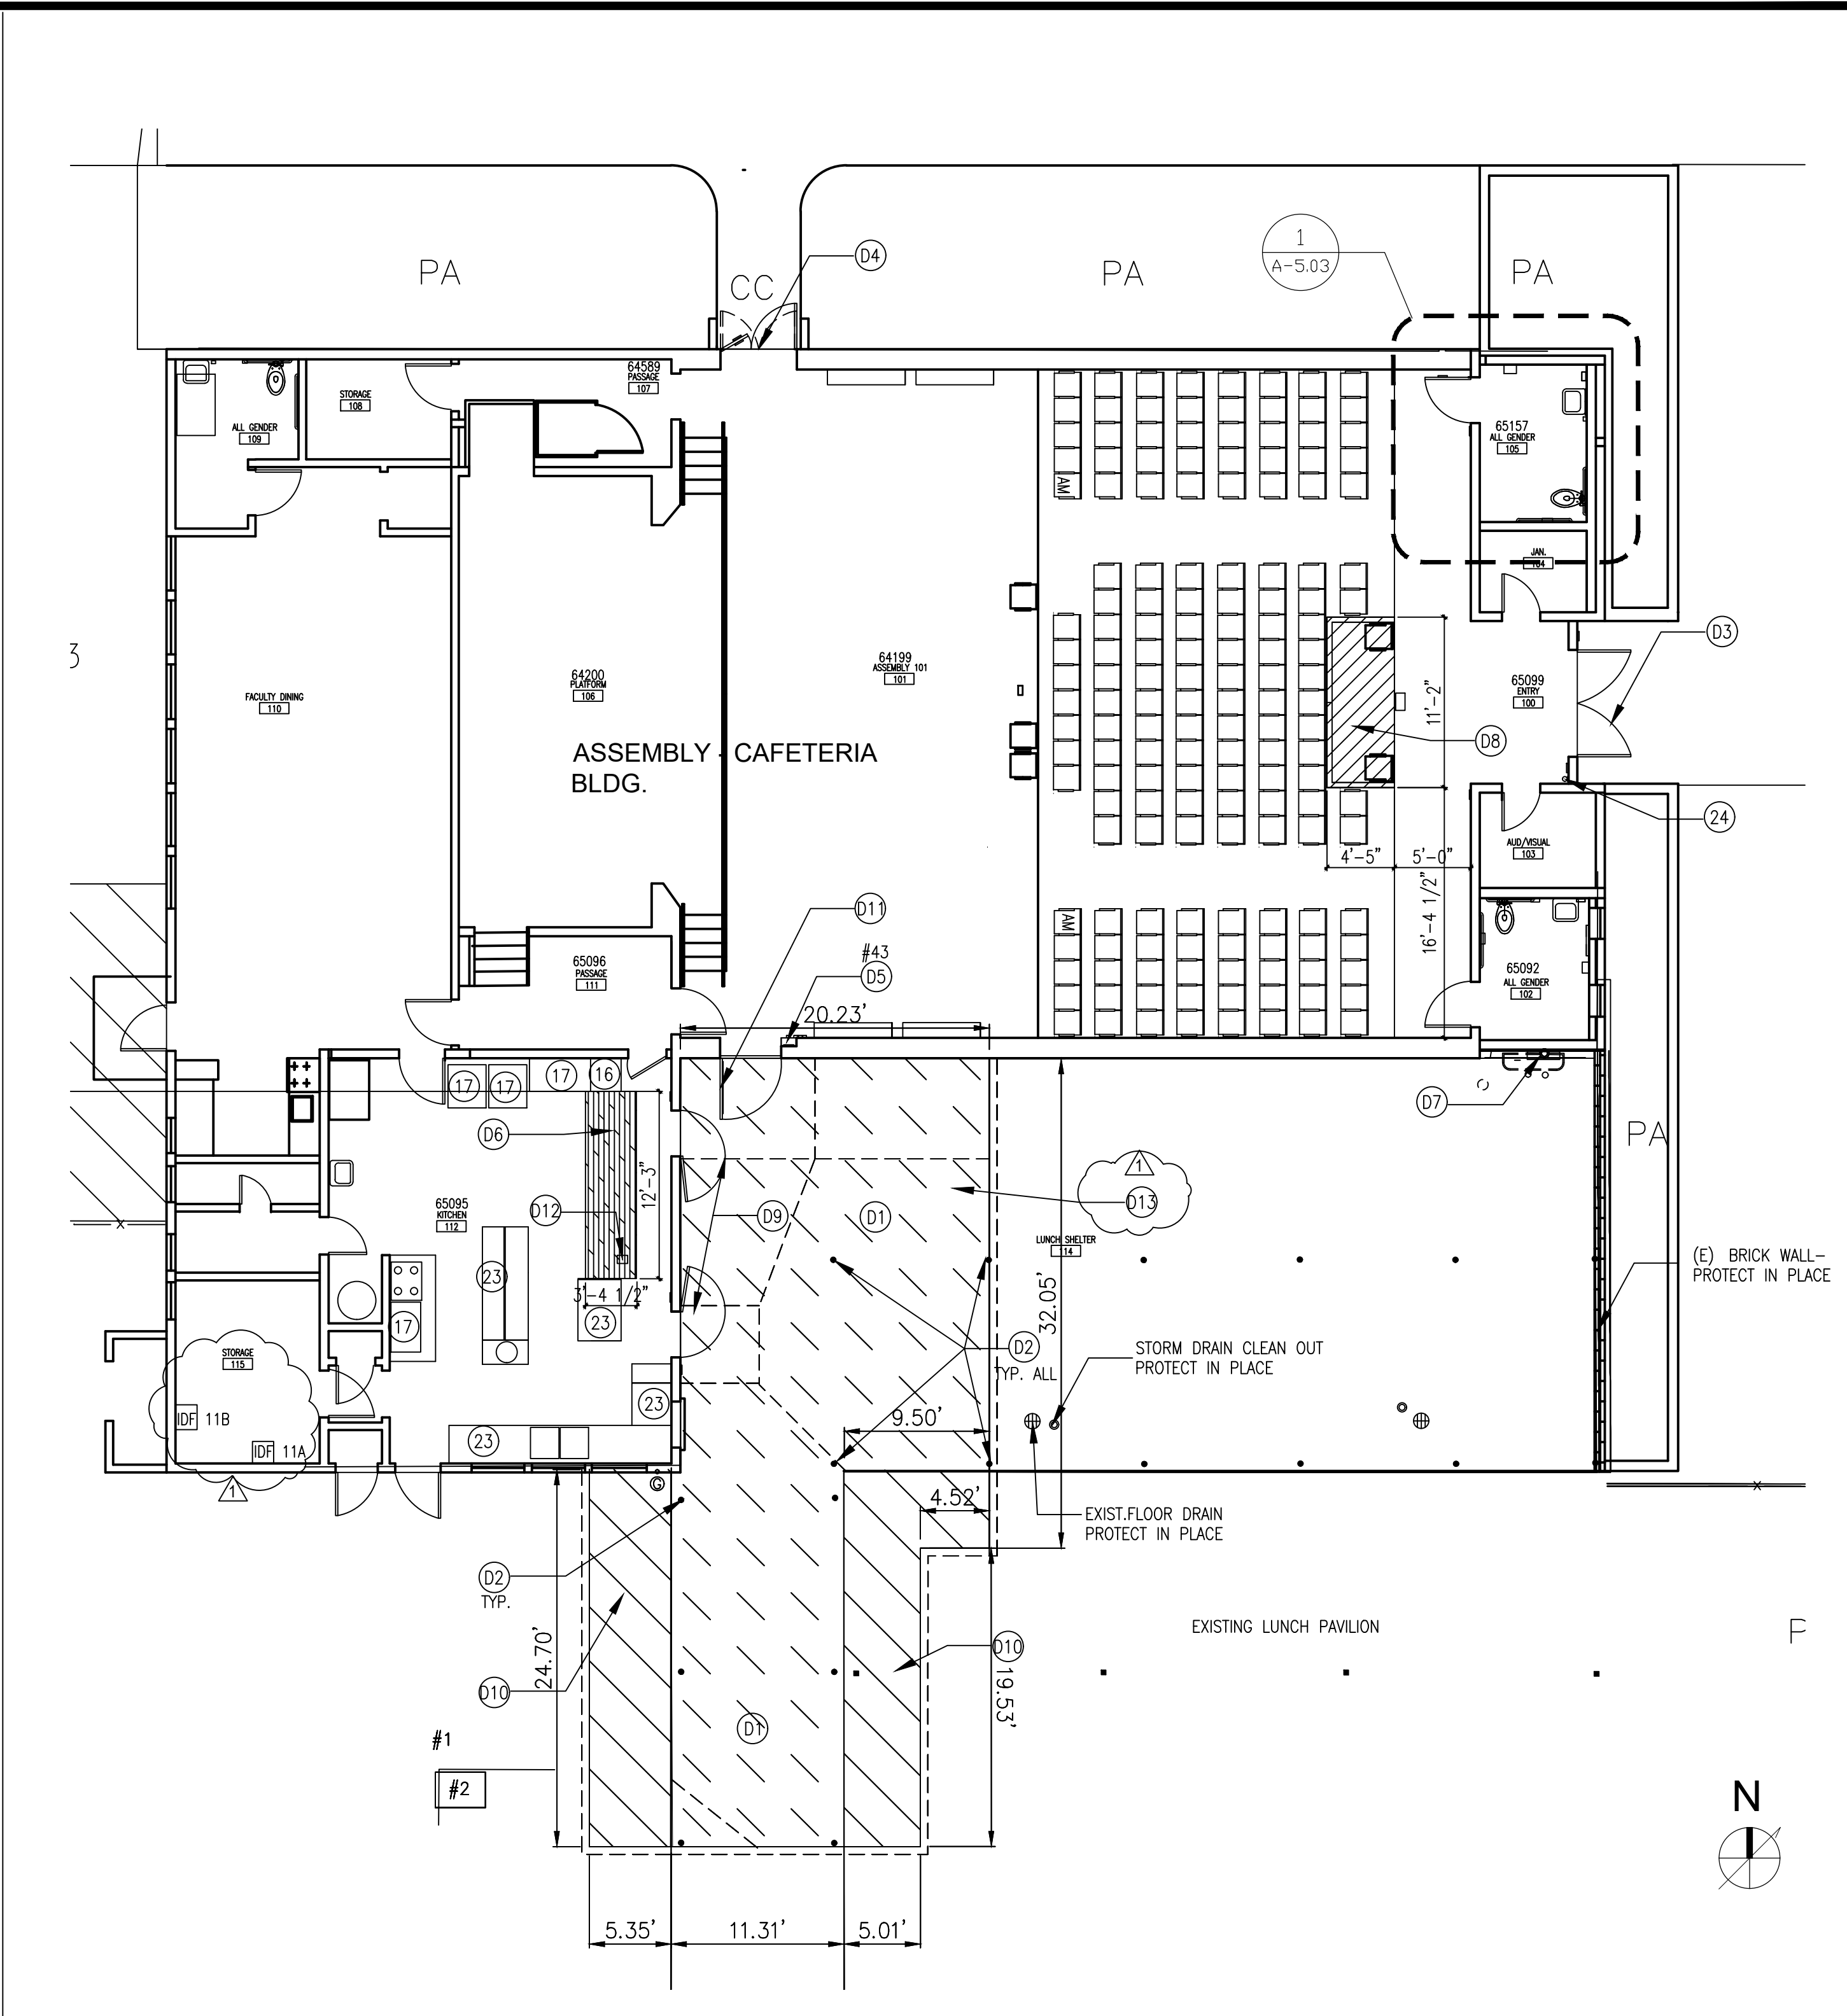


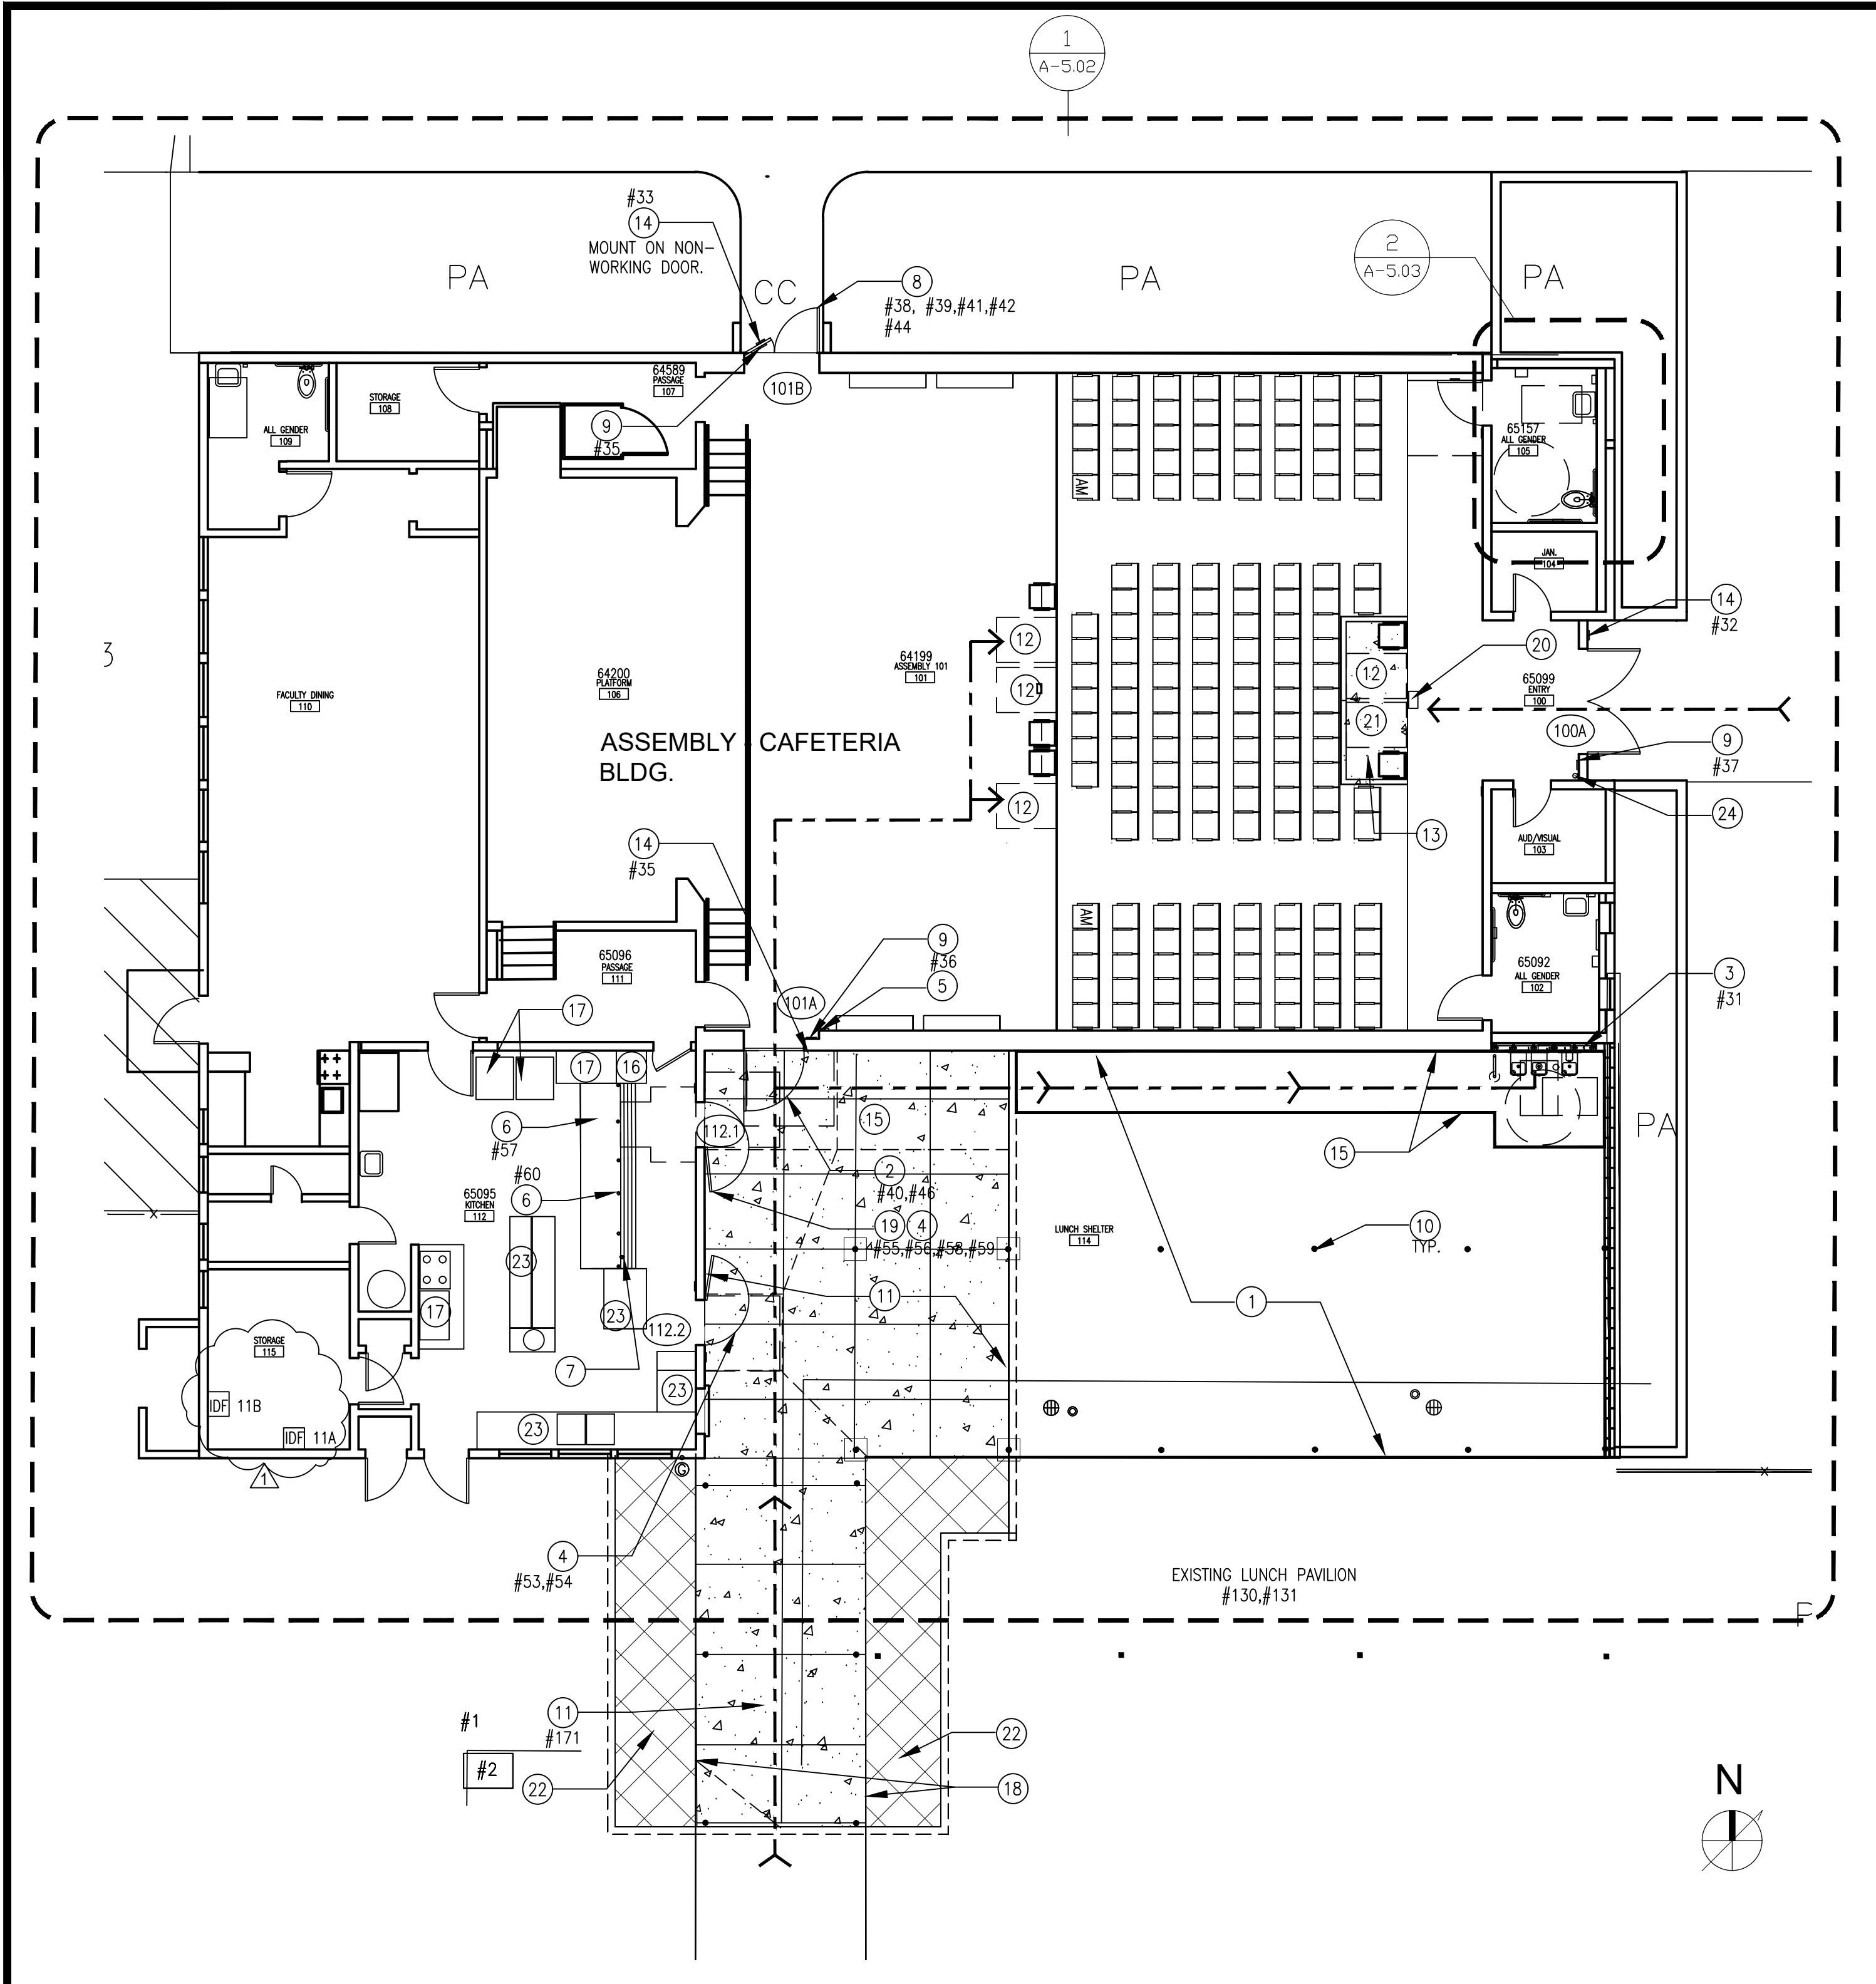

REMODEL (E) ASSEMBLY BLDG. 13 FLOOR PLAN

SCALE 1/8"=1'-0"


2

DEMO (E) ASSEMBLY BLDG. 13 FLOOR PLAN

SCALE 1/8"=1'-0"

1

GENERAL NOTES	DEMO KEY NOTES	KEY NOTES	KEY LEGEND
1-FOR ENLARGED PLAN. SEE SHEET A-5.02 2-SEE CIVIL SHEETS FOR DIMENSIONS/EXTENT OF NEW WORK	(D1) REMOVE CONCRETE PAVING. SEE CIVIL FOR DIMENSIONS/EXTENT WORK (D2) PROTECT IN PLACE EXISTING CONCRETE FOOTING AT (E) COLUMN. TYP. (D3) REMOVE AND REPLACE EXIST. DOOR HARDWARE, THRESHOLD AND (E) SOLID WOOD-PREP (E) WOOD DOOR FRAME TO RECEIVE NEW DOUBLE DOOR. (D4) REMOVE EXISTING DOUBLE WOOD DOOR AND ALL DOOR HARDWARE.-PREP (E) WOOD DOOR FRAME TO RECEIVE NEW DOUBLE WOOD DOOR (D5) REMOVE 12" MIN. CLEAR PORTION OF (E) 2X8 FURRED WOOD WALL AND CEMENT PLASTER (D6) REMOVE AND RELOCATE EXISTING STAINLESS STEEL FREESTANDING COUNTER AT FOOD SERVICE LINE. AND SNEEZE GUARD. (D7) REMOVE EXISTING TROUGH DRINKING FOUNTAIN- SEE P-5.02 (D8) REMOVE SEATS CHAIR BOLT TO (E) CONCRETE FLOOR AND REMOVE PORTION (E) TOPING CONCRETE SLAB .SEE DETAIL 9/ACS-2.00 (D9) REMOVE (E) DOOR HARDWARE, THRESHOLD- PREP TO RECEIVE NEW DOOR HARDWARE (D10) REMOVE ASPHALT PAVING-SEE CIVIL SHEETS FOR DIMENSIONS/EXTENT (D11) REMOVE (E) 4'X7' WOOD DOOR, HARDWARE AND THRESHOLD- PREP WOOD DOOR TO RECEIVE NEW DOOR. (D12) REMOVE (E) FLOOR MOUNT ELEC. OUTLET AND EXTEND TO NEW LOCATION (D13) REMOVE (E) LUNCH TABLE AT NEW CONCRETE WORK AND RE-INSTALL LUNCH TABLE AFTER FINISH WORK	(1) EXISTING CONCRETE PAVING-PROTECT IN PLACE (2) NEW 4'X7' WOOD DOOR, HARDWARE AND THRESHOLD. STAIN INTERIOR DOOR AND PAINT EXTERIOR DOOR TO MATCH (E) FINISH (3) NEW ADA TRIPLE DRINKING FOUNTAIN WITH WING GUARD (4) NEW DOOR HARDWARE. SEE ACS-8.00 (5) NEW LOCATION OF (E) FIRE ALARM PULL STATION (6) NEW LOCATION OF EXISTING STAINLESS STEEL SERVICE COUNTER AND SERVICE LINE. (7) NEW LOCATION OF FLOOR MOUNT ELEC. OUTLET (8) NEW UNEVEN PAIR DOORS WITH REMOVABLE MULLION (9) EXIT SIGN. SEE 9/ACS-6.00 (10) PROTECT IN PLACE STEEL COLUMNS AND CONC. FOOTING. TYP. ALL (11) NEW CONCRETE PAVING (ACCESSIBLE ROUTE (POT) SHALL BE WITHOUT ANY ABRUPT VERTICAL LEVEL CHANGES NOT EXCEEDING 1/4" MAX. & 48" CLEAR IN WIDTH MIN.). SEE C-3.02 (12) 3'X4' SPACE FOR WHEEL CHAIR (FOR TWO WHEEL CHAIR 5'-6"X4' MIN.) (13) NEW FLAT CONCRETE SLAB ADD CURB FOR WHEEL CHAIR SPACES. SEE DETAIL (14) WALL MOUNT BUILDING SIGNAGE. SEE DETAIL (15) PROVIDE MIN. 3'-0" WIDTH WALKWAY WITH 1.5% MAX. SLOPE ANY DIRECTION ALONG PATH OF TRAVEL (16) CASHIER TABLE- PROTECT IN PLACE	(17) (E) KIT. EQUIPMENTS, COMMERCIAL HOOD WITH FIRE SUPPRESSION SYSTEM- PROTECT IN PLACE (18) CONCRETE PAVING EDGE AT NEW AC PACING. SEE (19) PREP (E) DOOR TO RECEIVE DOOR HARDWARE (20) ADJUST (E) COVER TO FLUSH WITH (N) FLAT CONCRETE FLOOR (21) INSTALL NEW VCT TILE TO MATCH (E) TILE (22) NEW ASPHALT PAVING.SEE CIVIL FOR DIMENSIONS EXTENT. (23) (E) STAINLESS COUNTER TOP-PROTECT IN PLACE (24) (E) WALL MOUNT FIRE EXTINGUISHER-PROTECT IN PLACE (25) (E) WALL MOUNT ENCLOSURE IDF'S NEW CONCRETE PAVING REMOVE EXISTING CONCRETE PAVING/ SLAB NEW ASPHALT PAVING REMOVE EXISTING ASPHALT PAVING REMOVE PORTION OF WALL REMOVE (E) STAINLESS STEEL SERVING LINE COUNTER PATH OF TRAVEL TO ACCESSIBLE DRINKING FOUNTAIN SEMI-AMBULANT SEAT COMPANION SEAT (OFC) MATCH EXISTING. INSTALL PER MANUF. (USING 1/2" DIA. EPOXY KB TZ 2 1/2" EMBED TO CONCRETE SLAB DOOR NUMBER. SEE DOOR SCHEDULE SHEET ACS-8.00

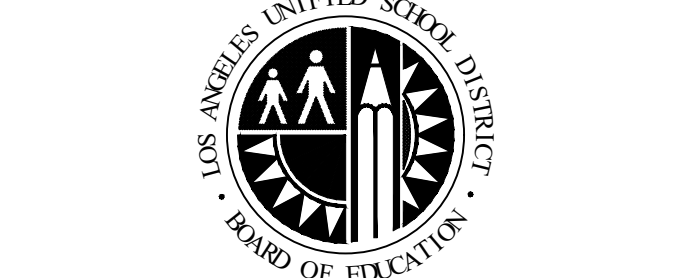


LOS ANGELES UNIFIED SCHOOL DISTRICT
ASSET MANAGEMENT
FACILITIES SERVICES DIVISION
 333 S. BEAUDRY AVENUE, 23RD FLOOR
 LOS ANGELES, CALIFORNIA 90017

PROJECT TITLE AND SCHOOL LOCATION
STRATHERN STREET SCHOOL
VOLUNTARY BARRIER REMOVAL
 7939 ST. CLAIRE AVENUE.
 N. HOLLYWOOD, CA 91605
 COLIN ID No.: 10373687


DSA# 03-125645

COMMISSIONED ARCHITECT
MLA
 ML ARCHITECTURE
 355 PASADENA AVENUE
 SOUTH PASADENA, CA91030

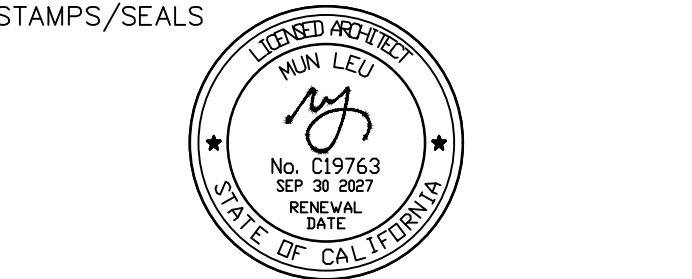

CONSULTANT

STAMPS/SEALS

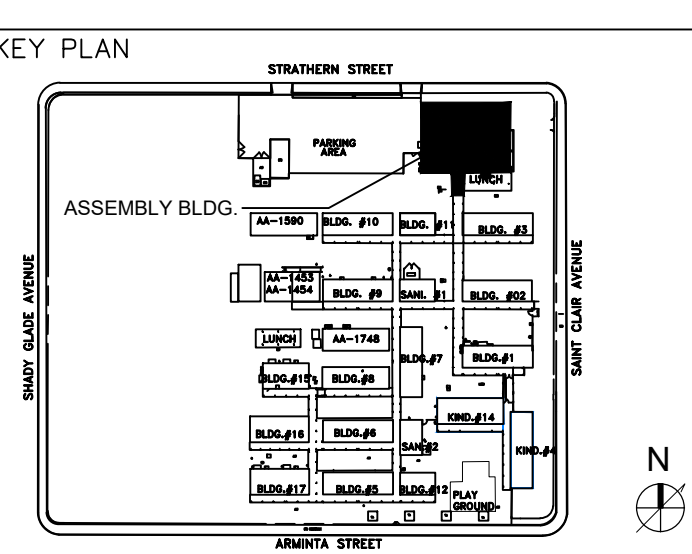

ADDEDUM 1 06/02/26

SHEET TITLE:

ASSEMBLY BLDG. 13 FLOOR PLAN


PROJECT NO.: 23004 PROJECT ARCH: ML ARCHITECTURE

DRAWN: T PHAN CHECKED: MUN LEU

SHEET NUMBER

A-2.00


DATE: 10-24-2025 SHEET: OF:

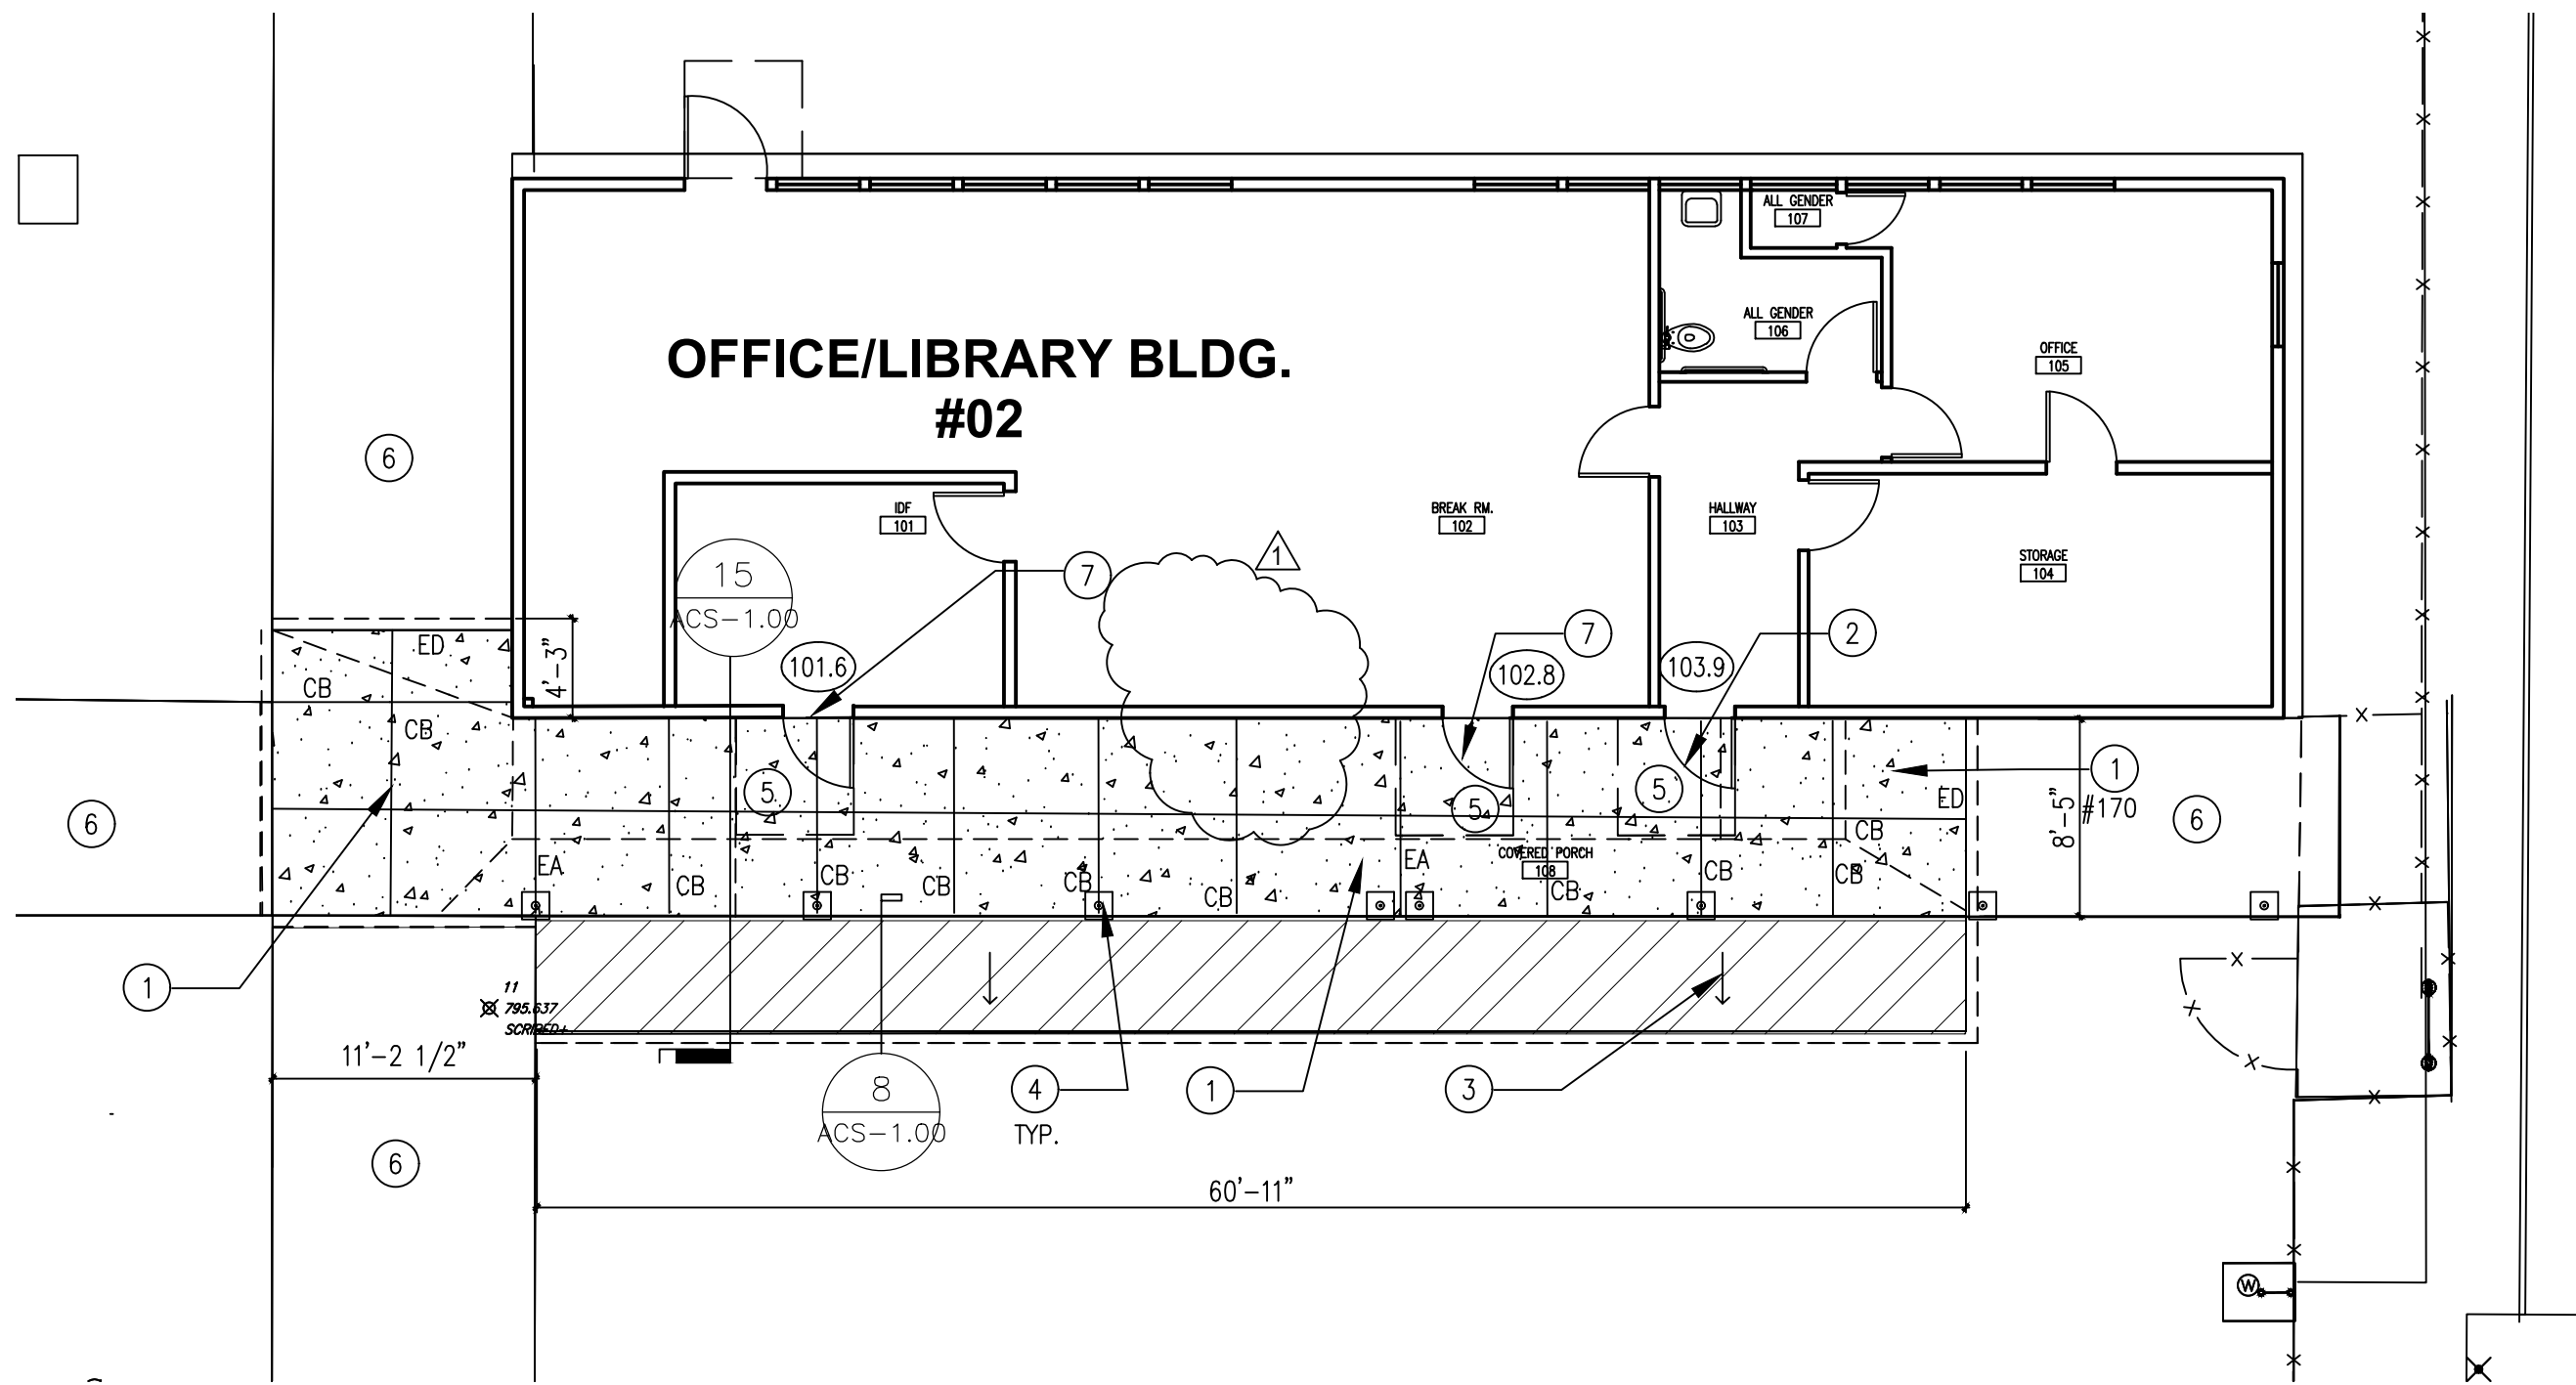

OFFICE/LIBRARY BLDG. 02

SCALE
1/8"=1'-0"

2

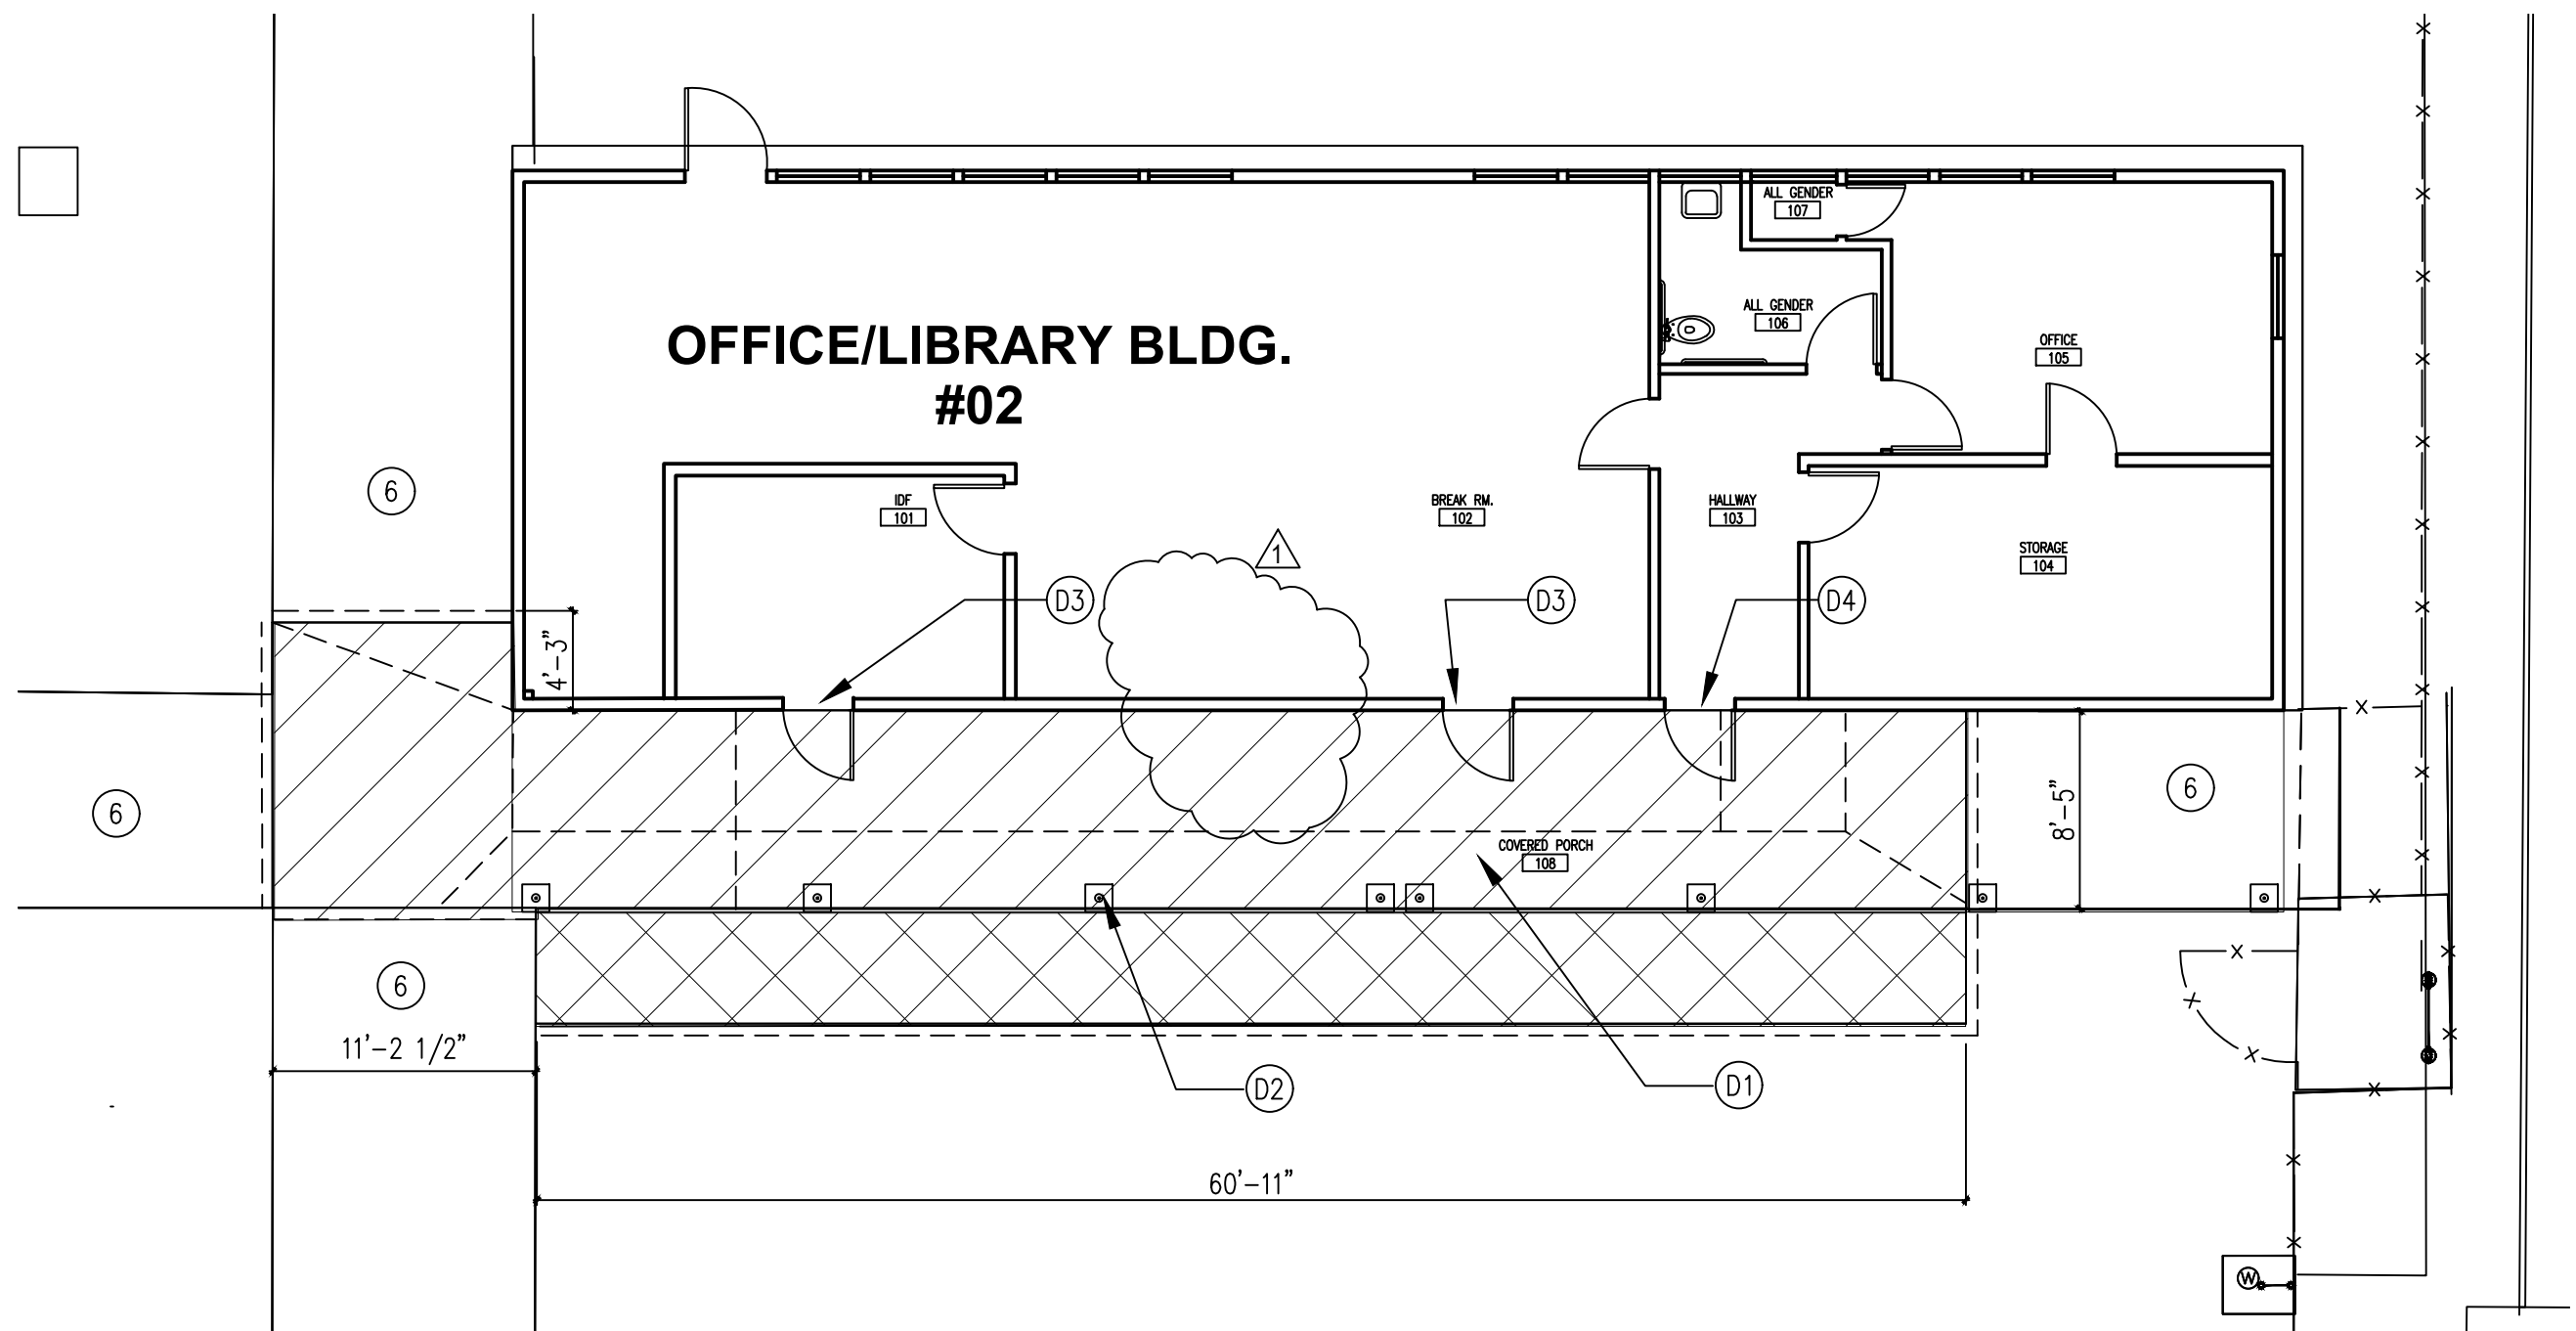

DEMO OFFICE/LIBRARY BLDG. 02

SCALE
1/8"=1'-0"

1

GENERAL NOTES

1-SEE CIVIL SHEETS C-3.02 AND C-2.02 FOR DIMENSIONS/EXTENT OF NEW WORK

DEMO KEY NOTES


- (D1) REMOVE (E) 4" REINFORCED CONCRETE PAVING.-SEE CIVIL DRAWINGS C-2.02 FOR EXTENT
- (D2) PROTECT IN PLACE EXISTING CONCRETE FOOTING AT (E) STEEL COLUMN. TYP.
- (D3) REMOVE (E) DOOR HARDWARE AND (E) STEEL THRESHOLD- PATCH (E) FLOOR WITH 3000 PSI CONCRETE. SEE 15/ACS-1.00
- (D4) REMOVE (E) ALUMINUM DOOR THRESHOLD- PATCH (E) FLOOR WITH 3000PSI CONCRETE

KEY NOTES

- (1) NEW CONCRETE PAVING. SEE SHEET C-3.02
- (2) PREP. (E) DOOR TO RECEIVE NEW ADA THRESHOLD. SEE DOOR SCHEDULE SHEET ACS-8.00. SEE DETAIL 2/ ACS-8.00
- (3) NEW ASPHALT PAVING SLOPE AWAY FROM BUILDING. SEE C-3.02
- (4) EXISTING COLUMN AND FOOTING- PROTECT IN PLACE
- (5) 5'X5' MIN. SPACE AT DOOR LANDING WITH 1.5% SLOPE ANY DIRECTION
- (6) EXISTING CONCRETE PAVING- PROTECT IN PLACE
- (7) PREP. (E) DOOR TO RECEIVE NEW DOOR HARDWARE AND ADA THRESHOLD-PAINT. SEE DETAIL 2/ACS-8.00 FOR THRESHOLD AND DOOR SCHEDULE SHEET ACS-8.00

KEY LEGEND

- NEW CONCRETE PAVING. SEE SHEET C-3.02
- REMOVE CONCRETE PAVING
- REMOVE EXISTING ASPHALT PAVING
- NEW ASPHALT PAVING
- EA EXPANSION JOINT. SEE 5 TYPE A /ACS-1.00
- CB CONTROL JOINT. SEE 5 TYPE B/ ACS-1.00
- ED JOINT.AT (N) AND (E) CONCRETE PAVING SEE 5 TYPE D /ACS-1.00

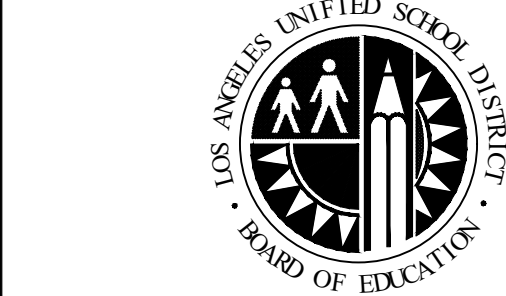

LOS ANGELES UNIFIED SCHOOL DISTRICT ASSET MANAGEMENT FACILITIES SERVICES DIVISION

333 S. BEAUDRY AVENUE, 23RD FLOOR
LOS ANGELES, CALIFORNIA 90017

PROJECT TITLE AND SCHOOL LOCATION

STRATHERN STREET
SCHOOL

VOLUNTARY BARRIER
REMOVAL

7939 ST. CLAIRE AVENUE.
N. HOLLYWOOD, CA 91605

COLIN ID No.: 10373687


DSA# 03-125645

COMMISSIONED ARCHITECT

MLA

ML ARCHITECTURE
355 PASADENA AVENUE
SOUTH PASADENA, CA91030


STAMPS/SEALS

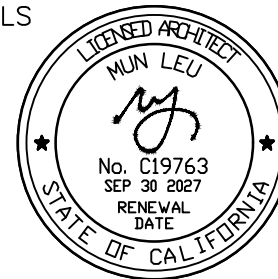

CONSULTANT

STAMPS/SEALS

KEY PLAN

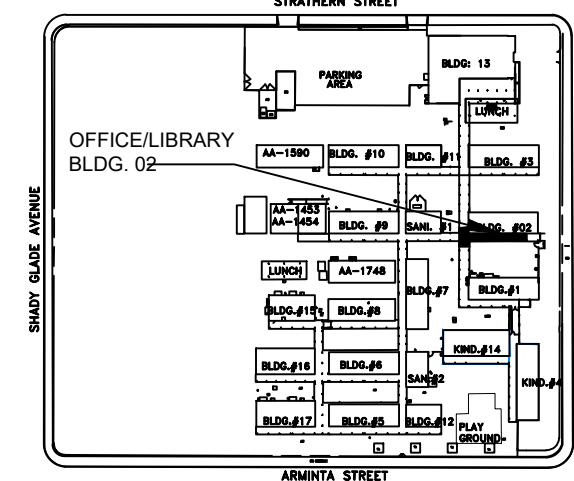

ADDENDUM 1 06/02/26

SHEET TITLE:

OFFICE/LIBRARY BLDG. 02-FLOOR PLAN

PROJECT NO.: 23004

PROJECT ARCH: ML ARCHITECTURE

DRAWN: T PHAN


CHECKED: MUN LEU

SHEET NUMBER

A-2.01

DATE: 10-24-2025


SHEET: OF:

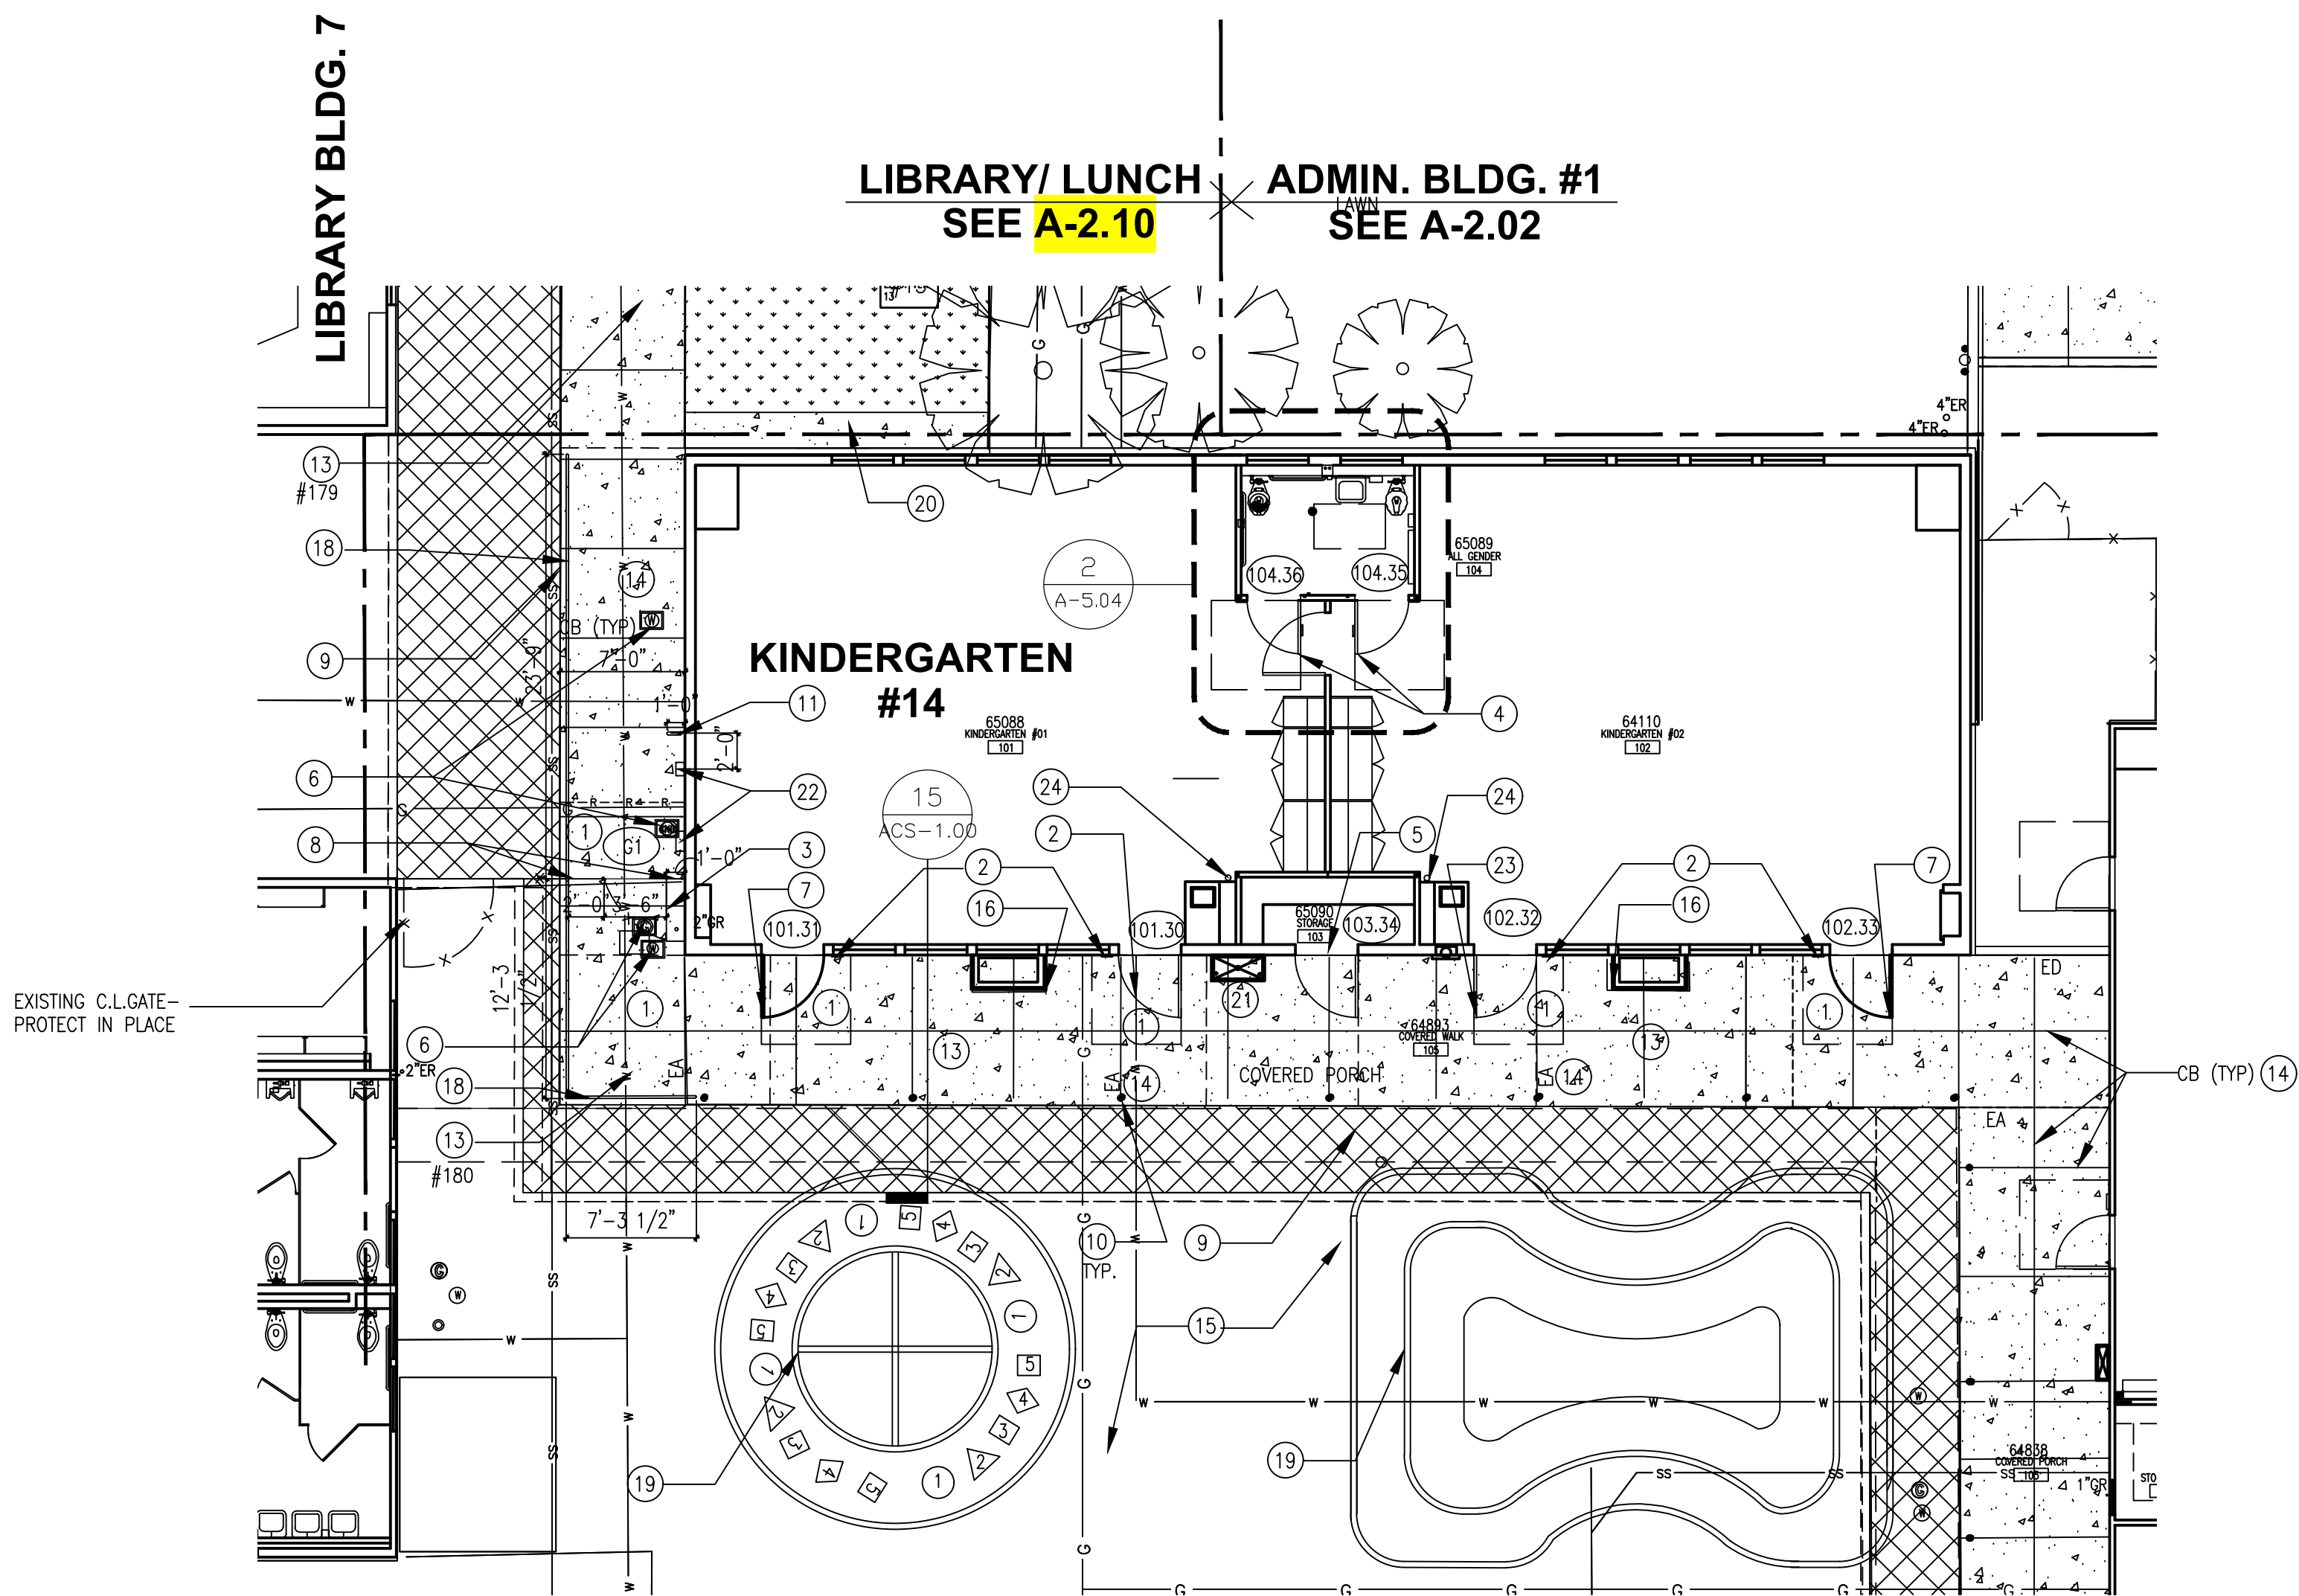

REMODEL PLAN KINDERGARTEN BLDG. #14

SCALE
1/8"=1'-0"

2

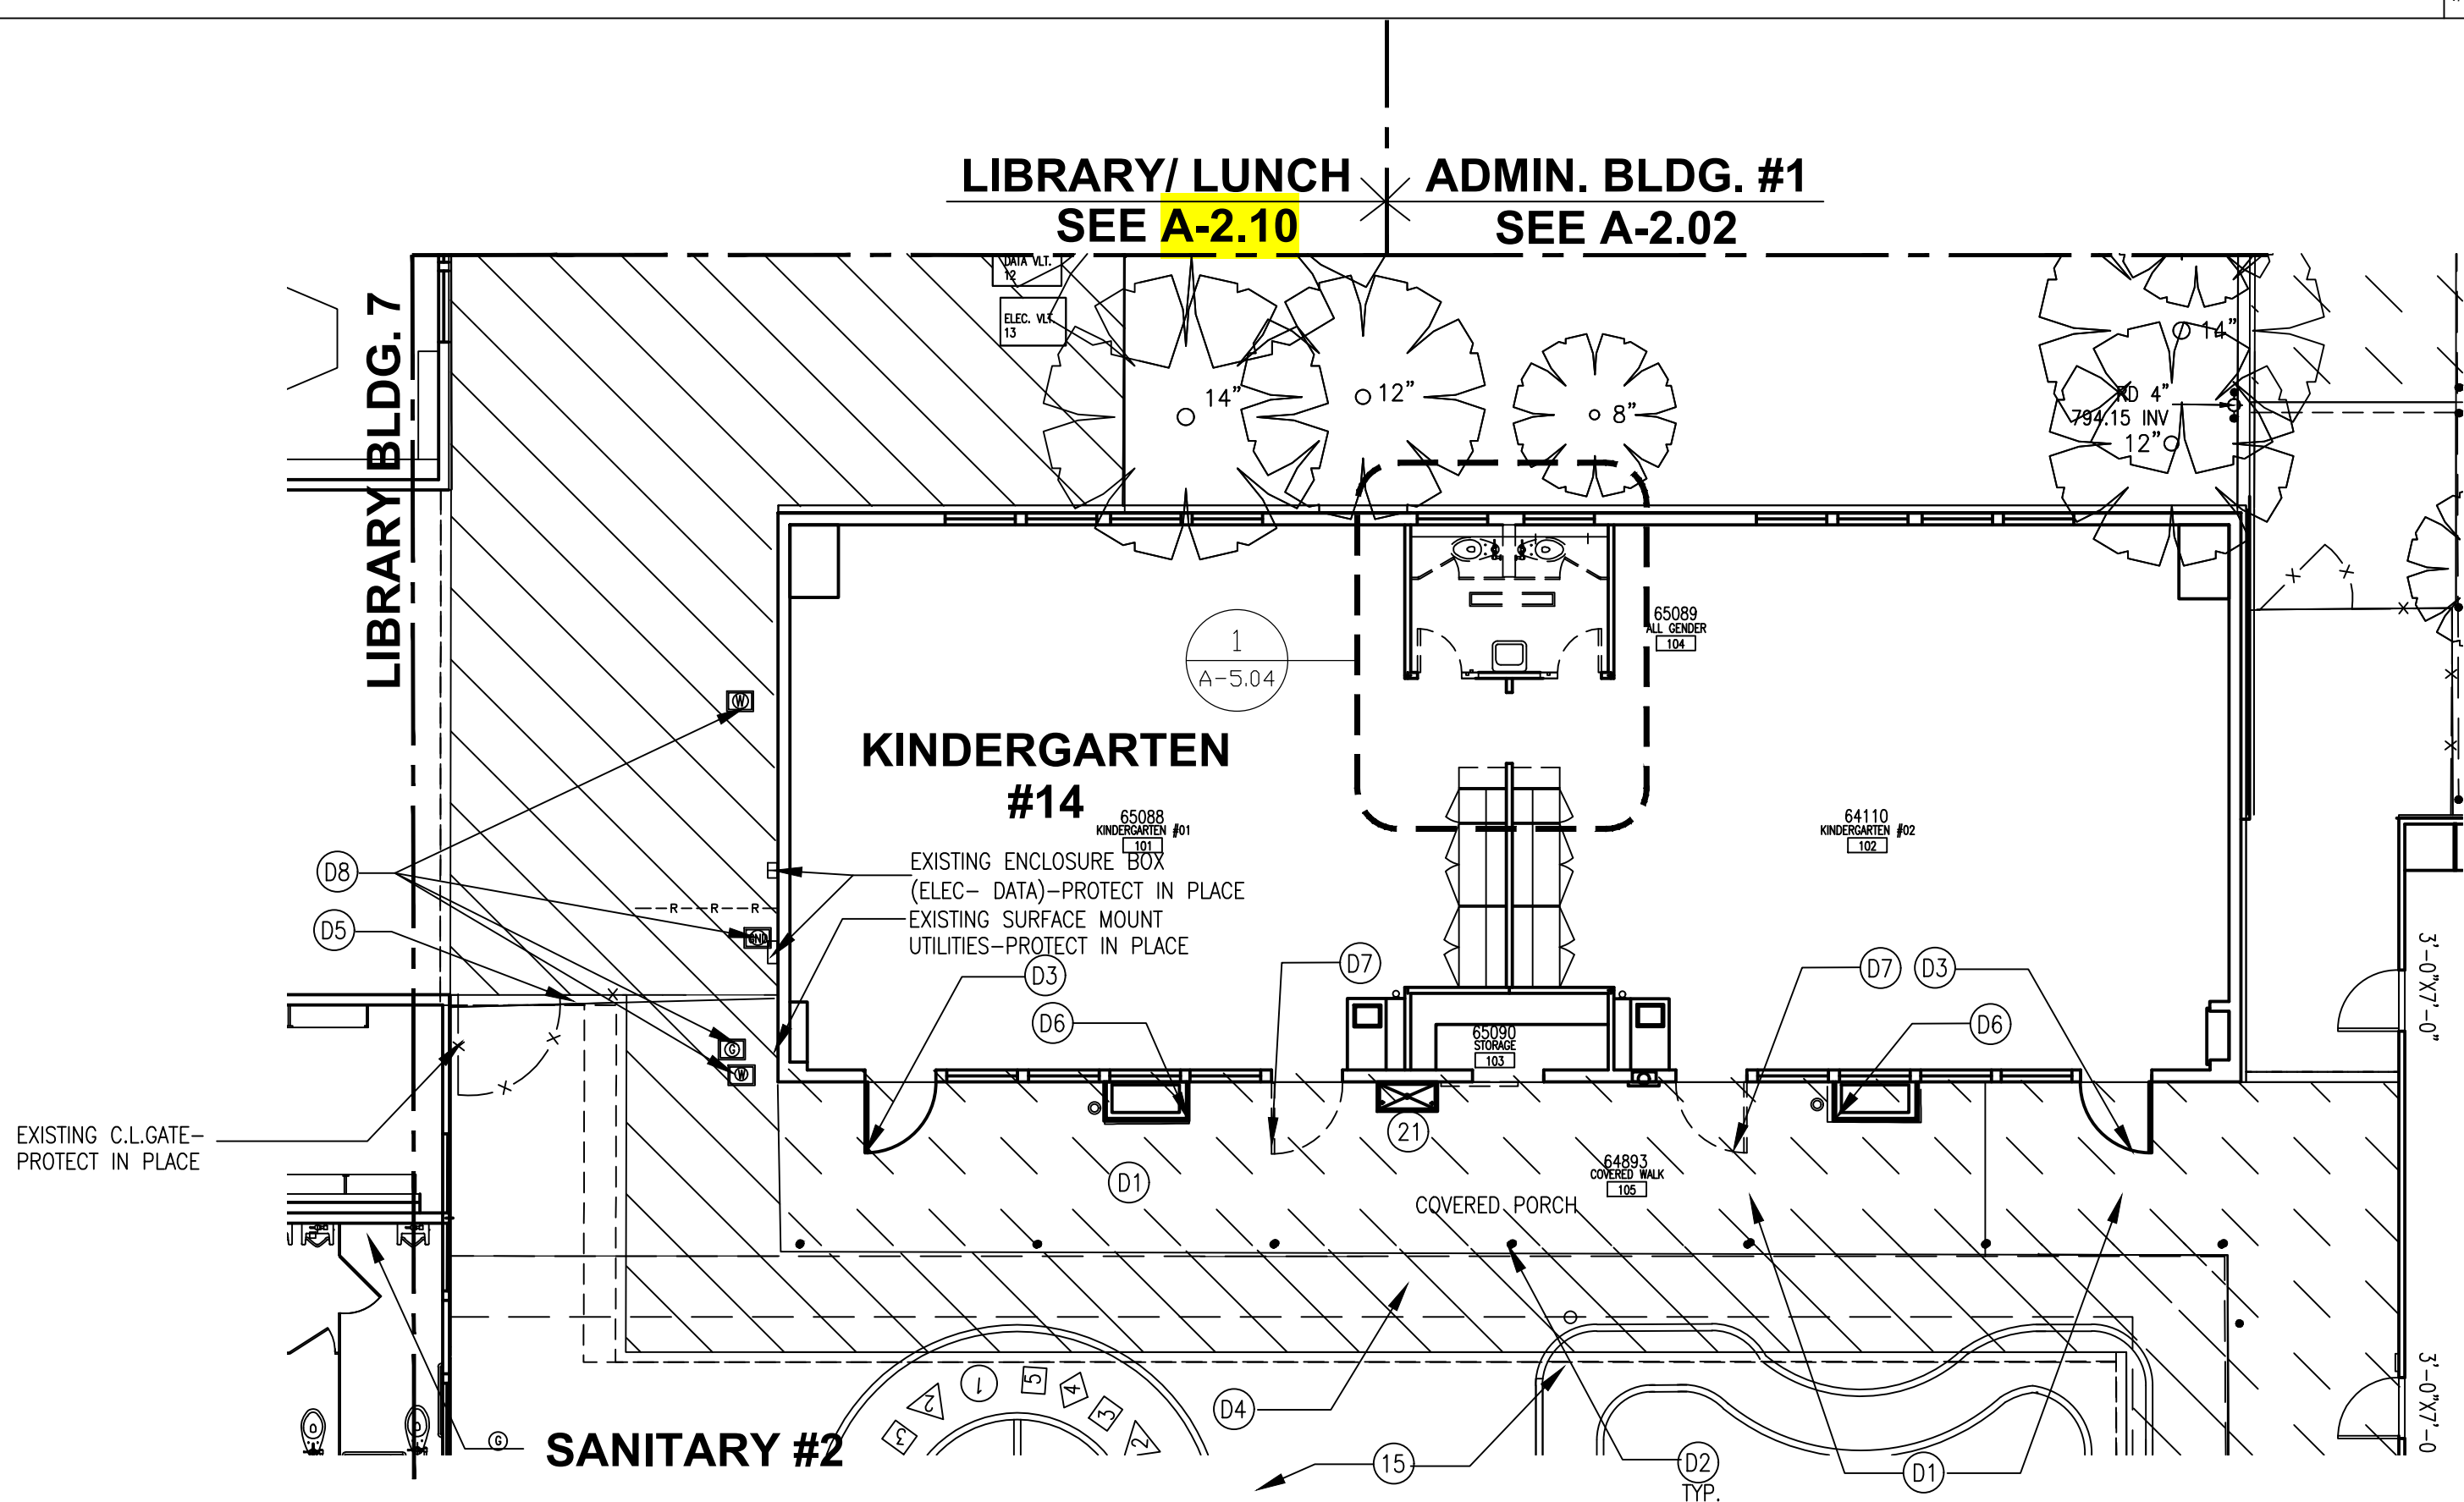

DEMO PLAN KINDERGARTEN BLDG. #14

SCALE
1/8"=1'-0"

1

GENERAL NOTES

1- FOR EXTENT WORK AND DIMENSION. SEE CIVIL SHEET C-2.01 AND C-3.01

DEMO KEY NOTES

- SAWCUT AND DEMO (E) 4" THICK CONCRETE PAVING WITH STEEL RE BAR. SEE C-2.01 AND 15/ACS-1.00.
- PROTECT IN PLACE EXISTING CONCRETE FOOTING AT (E) COLUMN. TYP. REFER TO DETAIL 15/ACS-1.00
- REMOVE (E) DOOR HARDWARE-PREP (E) WOOD DOOR FOR NEW DOOR HARDWARE
- REMOVE (E) PORTION ASPHALT. SEE C-2.01
- REMOVE (E) 6'-0" HIGH CHAIN LINK FABRIC-PROTECT IN PLACE POST FOOTING
- REMOVE (E) PROTECTION GALV. RAIL AND FOOTING AT (E) WALL MOUNT VERTICAL HVAC UNIT
- REMOVE (E) WOOD DOOR, FRAME, THRESHOLD AND HARDWARE
- REMOVE (E) CONCRETE YARD BOX. SEE C-2.01

KEY NOTES

- NEW CONCRETE 5'X5' PAVING LANDING WITH 1.5% MAX. SLOPE ANY DIRECTION.
- INSTALL ROOM SIGNAGE. SEE 12 ACS-6.00
- INSTALL NEW 3'-6" x 6'-0" CHAIN LINK GATE. GATE WILL BE OPEN DURING SCHOOL HOUR. SEE ACS-8.00.
- NEW 3'X7' SOLID CORE WOOD DOOR AND HM. FRAME WITH NEW HARDWARE. SEE DOOR SCHEDULE ACS-8.00
- INSTALL NEW THRESHOLD AT (E) DOOR. SEE DOOR SCHEDULE ACS-8.00
- NEW YARD BOX. SEE SHEET C-3.01 AND DETAIL 5/C-5.01
- INSTALL NEW HARDWARE AND THRESHOLD TO (E) DOOR. SEE DOOR SCHEDULE 2/ ACS-8.00-PAINOT DOOR AND FRAME
- (N) 6'-0" HIGH CHAIN LINK FENCE AND GATE. SEE DOOR SCHEDULE ACS-8.00
- NEW ASPHALT.
- EXISTING CONCRETE FOOTING OF STEEL COLUMN- PROTECT IN PLACE
- INSTALL NEW 10" LONG WING GUARD. SEE DETAIL 9 ACS-5.00
- (E) CONCRETE PAVING- PROTECT IN PLACE
- NEW CONCRETE PAVING WITH 3.75% MAX. P.O.T. AND 1.5% MAX CROSS SLOPE- SEE CIVIL C-3.01.
- ALL JOINT. SEE LEGEND
- EXISTING ASPHALT PAVING
- PROVIDE NEW HVAC PROTECTION RAIL AT (E) WALL MOUNT HVAC UNIT TO NEW CONC.PAVING. SEE 6/ACS-2.00
- 5'X5' MIN. LANDING WITH 2% MAX. SLOPE ANY DIRECTION
- HANDRAIL AT PAVING. SEE DETAIL 4/ACS-2.00
- RE-PAINT ENTIRE PATTERNS AND FINISH COLOR TO MATCH (E) OLD LAY OUT.
- CONCRETE MOWING STRIP. SEE CIVIL C-3.01
- EXISTING DRINKING FOUNTAIN- PROTECT IN PLACE
- EXISTING 8" DEPTH SURFACE MOUNTED PANEL- PROTECT IN PLACE
- NEW DOOR HARDWARE TO (N) DOOR AND HM DOOR FRAME- REPAIR PLASTER AND RE APINT TO MATCH (E) FINISH
- (E) WALL MOUNT FIRE EXTINGUISHER-PROTECT IN PLACE

KEY LEGEND

- NEW CONCRETE PAVING. SEE C-3.01
- REMOVE CONCRETE PAVING. SEE C-2.01
- REMOVE EXISTING ASPHALT PAVING. SEE C-2.01
- NEW ASPHALT PAVING. SEE C-3.01
- ACCESSIBLE PATH OF TRAVEL TO LUNCH AREA
- EA EXPANSION JOINT. SEE 5 TYPE A /ACS-1.00
- CB CONTROL JOINT. SEE 5 TYPE B/ ACS-1.00
- ED JOINT. AT (N) AND (E) CONCRETE PAVING SEE 5 TYPE D /ACS-1.00



LOS ANGELES UNIFIED SCHOOL DISTRICT ASSET MANAGEMENT FACILITIES SERVICES DIVISION

333 S. BEAUDRY AVENUE, 23RD FLOOR
LOS ANGELES, CALIFORNIA 90017

PROJECT TITLE AND SCHOOL LOCATION

STRATHERN STREET
SCHOOL
VOLUNTARY BARRIER
REMOVAL

7939 ST. CLAIRE AVENUE.
N. HOLLYWOOD, CA 91605
COLIN ID No.: 10373687


DSA# 03-125645

COMMISSIONED ARCHITECT

MLA

ML ARCHITECTURE
355 PASADENA AVENUE
SOUTH PASADENA, CA 91030


STAMPS/SEALS

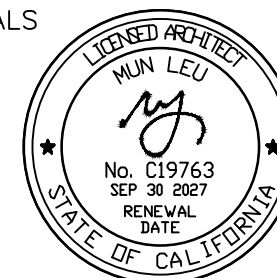

CONSULTANT

STAMPS/SEALS

KEY PLAN

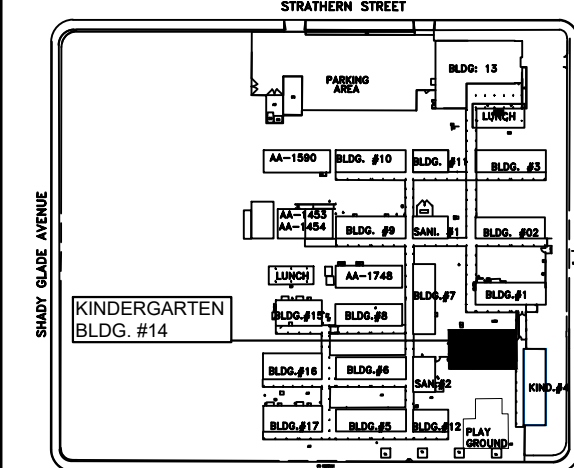

ADDEDUM 1 06/02/26

SHEET TITLE:

**KINDERGARTEN
BLDG. #14**

PROJECT NO.: 23004

PROJECT ARCH: ML ARCHITECTURE

DRAWN: T PHAN


CHECKED: MUN LEU

SHEET NUMBER

A-2.04

DATE: 10-24-2025

SHEET: OF:


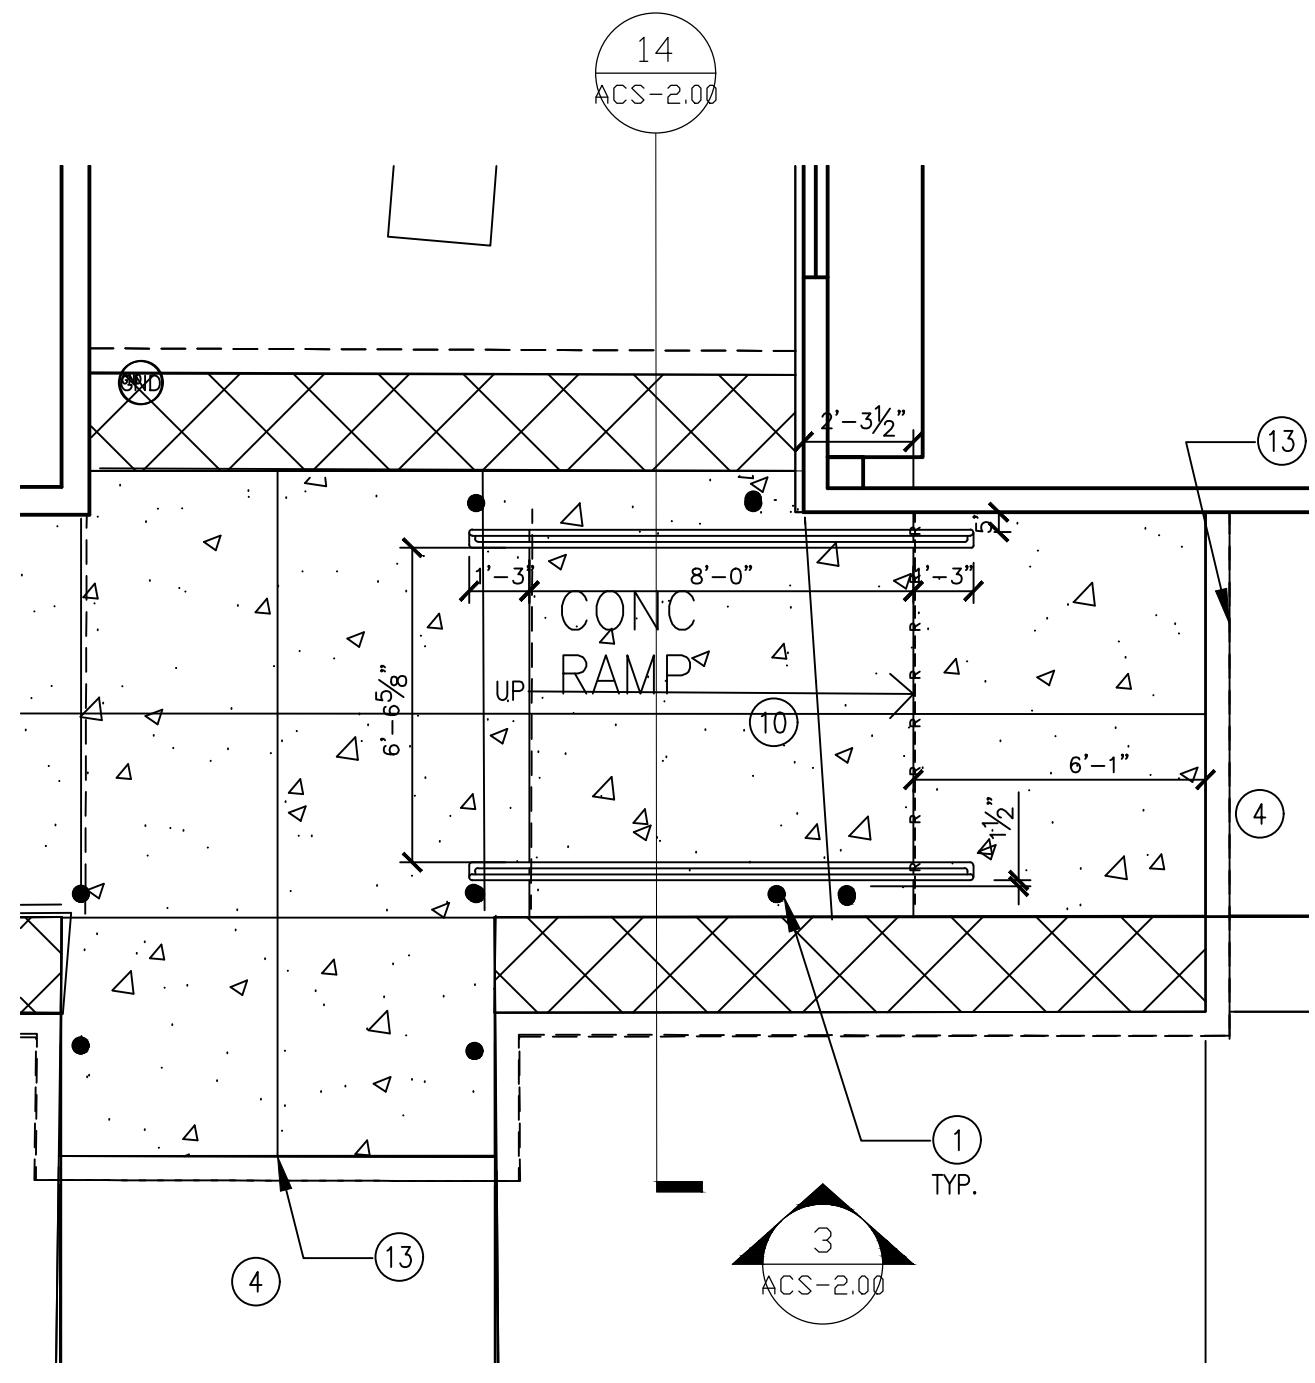



SCALE	2
1/8"=1'-0"	



SCALE	1
1/8"=1'-0"	

  KEY LEGEND

	NEW CONCRETE PAVING. SEE CIVIL C-3.04 AND C-3.01
	REMOVE CONCRETE PAVING. SEE CIVIL C-2.01 AND C-2.04
	REMOVE EXISTING ASPHALT. SEE CIVIL C-2.01 AND C-2.04
	NEW ASPHALT PAVING. SEE CIVIL C-3.04 AND C-3.01
EA	EXPANSION JOINT. SEE 5 TYPE A / ACS-1.00
CB	CONTROL JOINT. SEE 5 TYPE B/ ACS-1.00
ED	JOINT-AT (N) AND (E) CONCRETE PAVING SEE 5 TYPE D / ACS-1.00

 



VIEW: 1 (TABLE ALLOW ARRANGEMENT DIFFERENT WAY)



VIEW: 2 DESK FOR ACCESSIBLE AREA.

SEE SHEET **A-2.04**



VIEW: 3 TV BRACKET

SEE SHEET **A-2.04**

GENERAL NOTES

1. CONSULT WITH THE LAUSD ARBORIST PRIOR TO CUTTING TREE ROOT FOR NEW WORK.

DEMO KEY NOTES

- (D1) REMOVE (E) 4" THICK CONCRETE PAVING AND RE BAR. SEE C-2.01
- (D2) PROTECT IN PLACE EXISTING CONCRETE FOOTING AT (E) COLUMN. TYP. SEE 15/ACS-1.00
- (D3) REMOVE (E) DOOR HARDWARE AT (E) WOOD DOOR -PREP FOR NEW DOOR HARDWARE TO (E) WOOD DOOR.
- (D4) REMOVE (E) TV AND (E) WALL MOUNT TV BRACKET- PROTECT (E) WOOD BLOCKING
- (D5) REMOVE (E) KEYBOARD PULL OUT TRAY UNDERNEATH THE (E) COUNTERTOP
- (D6) REMOVE (E) ONE WOOD BAY BOOK SHELVES (AROUND 4'-0" LONG. V.I.F) REPAIR WALL AND PAINT TO MATCH (E) FINISH
- (D7) CONSULT WITH THE LAUSD ARBORIST PRIOR TO CUTTING TREE ROOT FOR NEW WORK.
- (D8) REMOVE (E) UNDERGROUND CONC. BOX AND COVER- PREP TO RECEIVE A NEW UTILITY BOX AND COVER. SEE C-2.01
- (D9) REMOVE (E) 6'-0" HIGH CHAIN LINK FABRIC FROM POST TO POST - PREP TO INSTALL NEW 3'-6" X 6'-0" CHAIN LINK GATE, NEW POST AND CHAIN LINK FABRIC. -SEE DETAIL 13/ACS-5.00
- (D10) ADJUST VAULT PER DETAIL 10/C-5.01
- (D11) REMOVE 2- (E) ROUND LUNCH TABLES AT THIS AREA

KEY NOTES

- (1) NEW CONCRETE PAVING. SEE C-3.01
- (2) EXISTING ASPHALT PAVING- PROTECT IN PLACE
- (3) EXISTING CONCRETE PAVING - PROTECT IN PLACE
- (4) NEW CHAIN LINK FENCE AND GATE-SEE DETAIL 13/ACS-5.00
- (5) NEW WALL MOUNT TV BRACKET TO (E) WOOD BLOCKING. INSTALL NEW THIN TV (AROUND 3" DEPTH) WITH 7'-0" CLEARANCE FROM FINISH FLOOR (OWNER PROVIDE CONTRACTOR INSTALL)
- (6) NEW YARD BOX. SEE DETAIL C-5.01
- (7) NEW ROOM SIGNAGE. SEE DETAIL ACS-6.00
- (8) WALL MOUNT EXIT SIGNAGE. SEE DETAIL ACS-6.00
- (9) NEW HARDWARE AND THRESHOLD TO (E) DOOR- PAINT. SEE ACS-8.00
- (10) NEW CONCRETE PAVING 5'x5' MIN. LANDING WITH 1.5% MAX. ANY DIRECTION.
- (11) NEW ACCESSIBLE LUNCH AREA
- (12) 30"x4'-0" CLEAR ACCESSIBLE SPACE FOR ACCESSIBLE TABLE
- (13) LUNCH TABLE PROVIDE BY OWNER - CONTRACTOR TO INSTALL PER MANUF. GUIDELINE USE 3/4"DIA. KH-TZ2 3" EMBEDMENT TO CONC. PAVING
- (14) EXISTING COUNTER TOP WITH 27" MIN HIGH CLEARANCE FOR COMPUTER STATION
- (15) EXISTING MOVABLE TABLE WITH ADJUSTABLE LEG ALLOW HAVING 27" MIN HIGH CLEARANCE FOR WHEEL CHAIR
- (16) EXISTING HANDRAIL WITH FOOTING AT (E) WALL MOUNT HVAC -1/2" MAX CHIP TOP FOOTING TO FLUSH WITH NEW AC PAVING. SEE 10/ACS-1.00
- (17) EXISTING HANDRAIL WITH FOOTING AT WALL MOUNT HVAC -PROTECT IN PLACE
- (18) NEW YARD. BOX AND COVER FLUSH WITH CONCRETE PAVING. SEE C-5.01
- (19) EXISTING TREE WITH TREE WELL WITH NEW REDWOOD HEADER. SEE C-5.01
- (20) HANDRAIL AT NEW CONCRETE PAVING-SEE DETAIL ACS-2.00
- (21) ADJUST (E) VAULT. PER DETAIL C-5.01
- (22) NEW 10" LONG WING GUARD. SEE SIM. DETAIL ACS-5.00
- (23) (E) YARD BOX - PROTECT IN PLACE
- (24) 3'x4" CLEARANCE AT 2'-10" (E) COUNTERTOP
- (25) CONSULT WITH THE LAUSD ARBORIST PRIOR TO CUTTING TREE ROOT FOR NEW WORK.
- (26) (E) CASE WORK WITH COUNTER TOP AT 30" HIGH

KEY LEGEND

- NEW CONCRETE PAVING
- REMOVE (E) REINFORCED CONCRETE PAVING
- REMOVE EXISTING ASPHALT
- NEW ASPHALT PAVING
- EA EXPANSION JOINT. SEE 5 TYPE A /ACS-1.00
- CB CONTROL JOINT. SEE 5 TYPE B/ ACS-1.00
- ED JOINT.AT (N) AND (E) CONCRETE PAVING SEE 5 TYPE D /ACS-1.00
- 90 DEGREE IRRIGATION HEAD
- 180 DEGREE IRRIGATION HEAD
- 3/4"DIA. PVC CONNECT TO (E) IRRIGATION LINE NEARBY
- ACCESSIBLE PATH OF TRAVEL TO ACCESSIBLE SPACE AT LUNCH TABLE

RENOVATION PLAN AT LIBRARY AND LUNCH AREA


SCALE
1/8"=1'-0"

2

DEMO PLAN AT LIBRARY AND LUNCH AREA

SCALE
1/8"=1'-0"

1

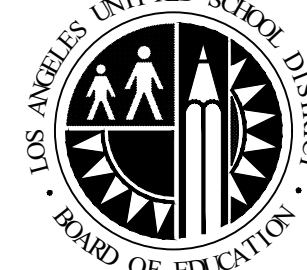

LOS ANGELES UNIFIED SCHOOL DISTRICT ASSET MANAGEMENT FACILITIES SERVICES DIVISION

333 S. BEAUDRY AVENUE, 23RD FLOOR
LOS ANGELES, CALIFORNIA 90017

PROJECT TITLE AND SCHOOL LOCATION

**STRATHERN STREET
SCHOOL
VOLUNTARY BARRIER
REMOVAL**

7939 ST. CLAIRE AVENUE.
N. HOLLYWOOD, CA 91605
COLIN ID No.: 10373687


DSA# 03-125645

COMMISSIONED ARCHITECT

MLA

ML ARCHITECTURE
355 PASADENA AVENUE
SOUTH PASADENA, CA91030


STAMPS/SEALS

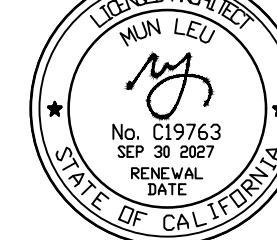

CONSULTANT

STAMPS/SEALS

KEY PLAN

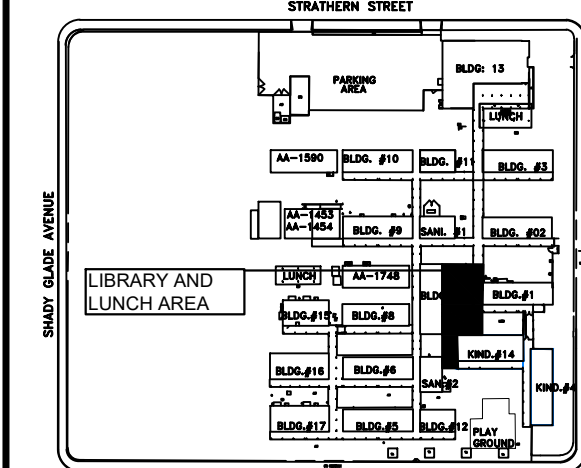

ADDEDUM 1

06/02/26

SHEET TITLE:

LIBRARY AND OUTDOOR PLAN

PROJECT NO.: 23004 PROJECT ARCH: ML ARCHITECTURE


DRAWN: T PHAN CHECKED: MUN LEU

SHEET NUMBER

A-2.10

DATE: 10-24-2025


SHEET: OF:

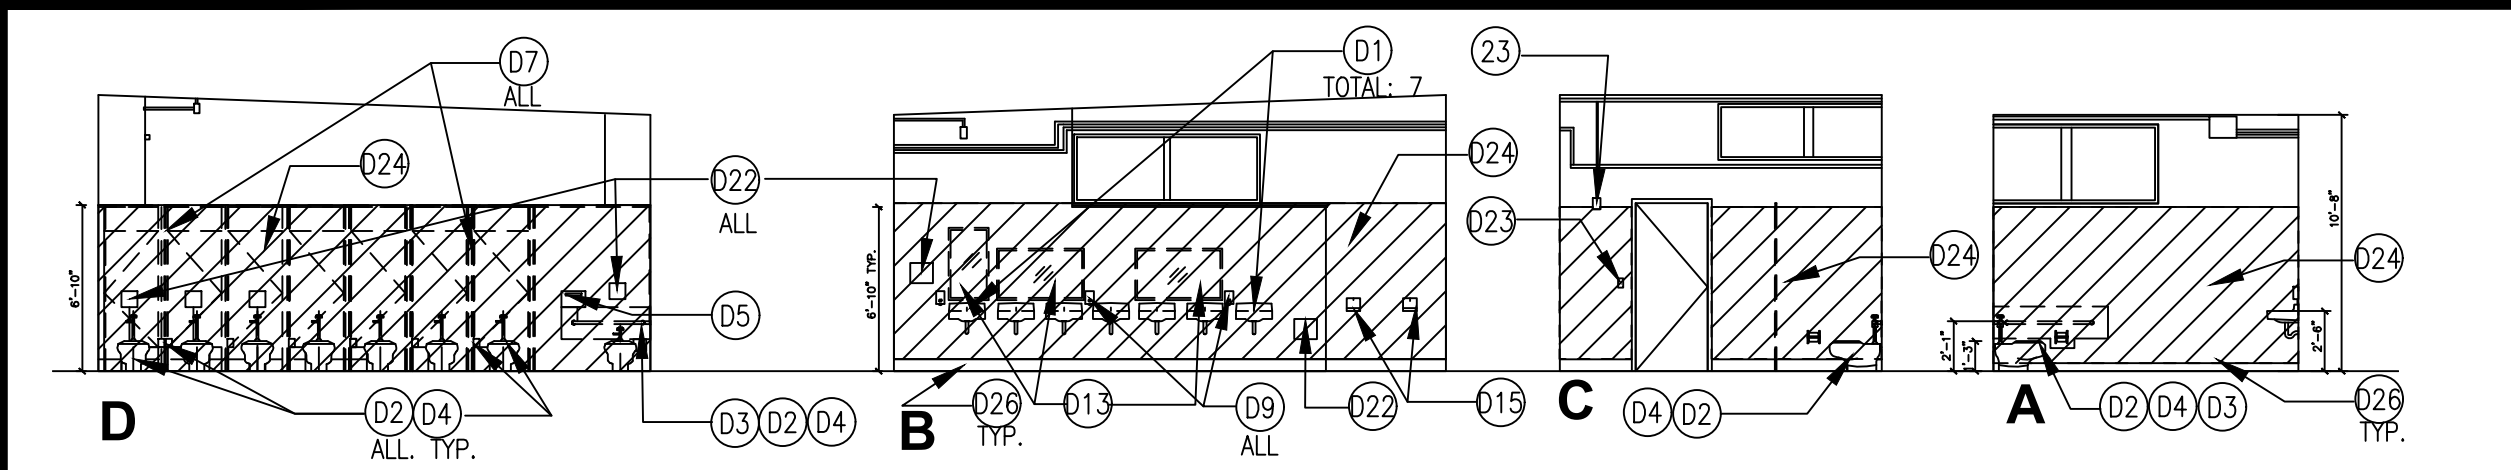

DEMO INTERIOR ELEVATION GIRLS RESTROOM

SCALE
1/4"=1'-0"


6

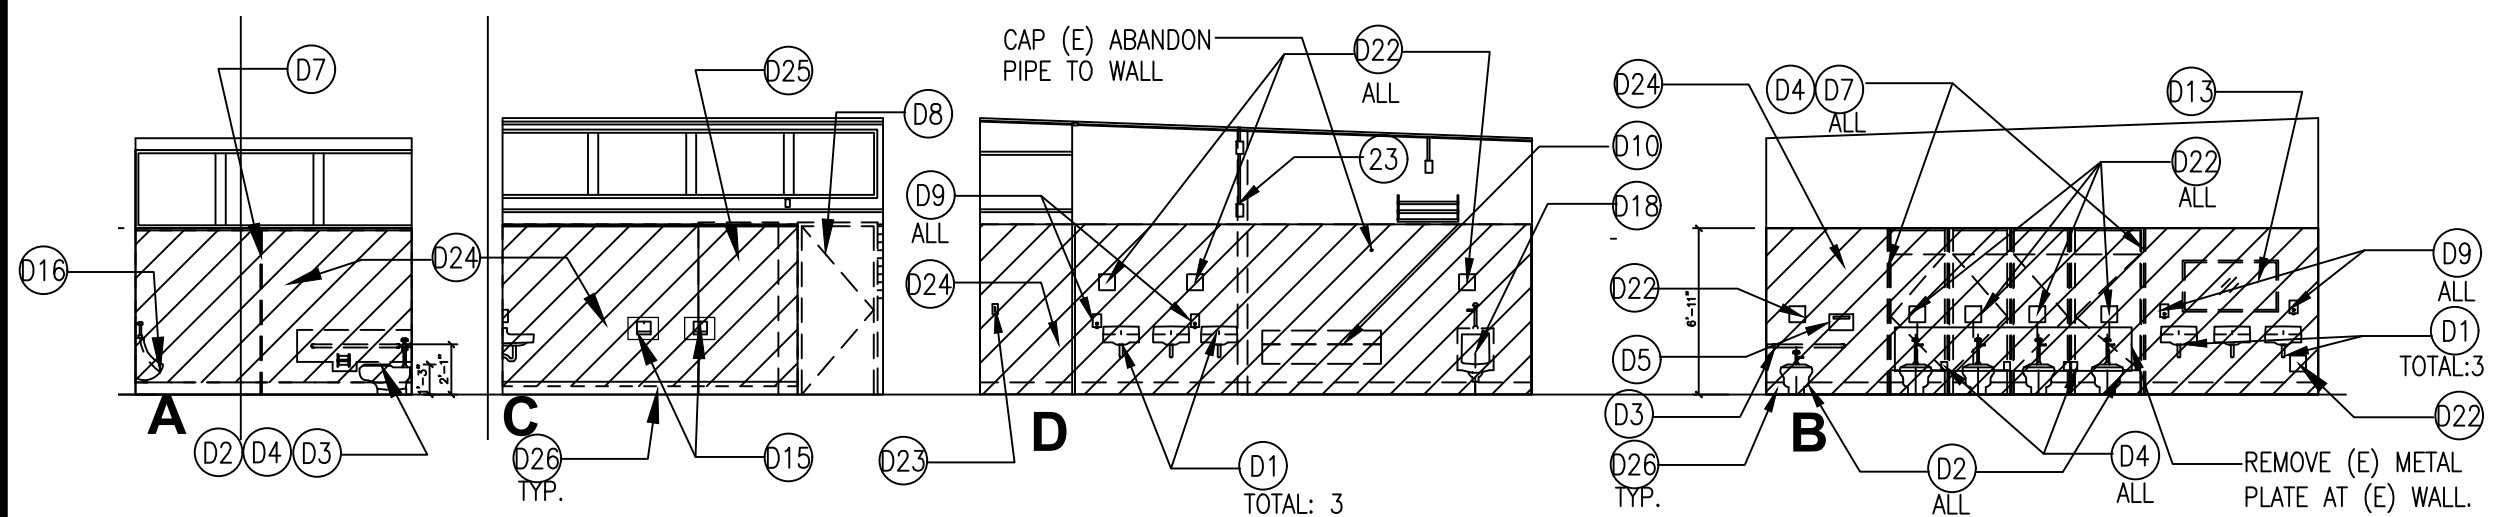

DEMO INTERIOR ELEVATION-BOYS RESTROOM

SCALE
1/4"=1'-0"


5

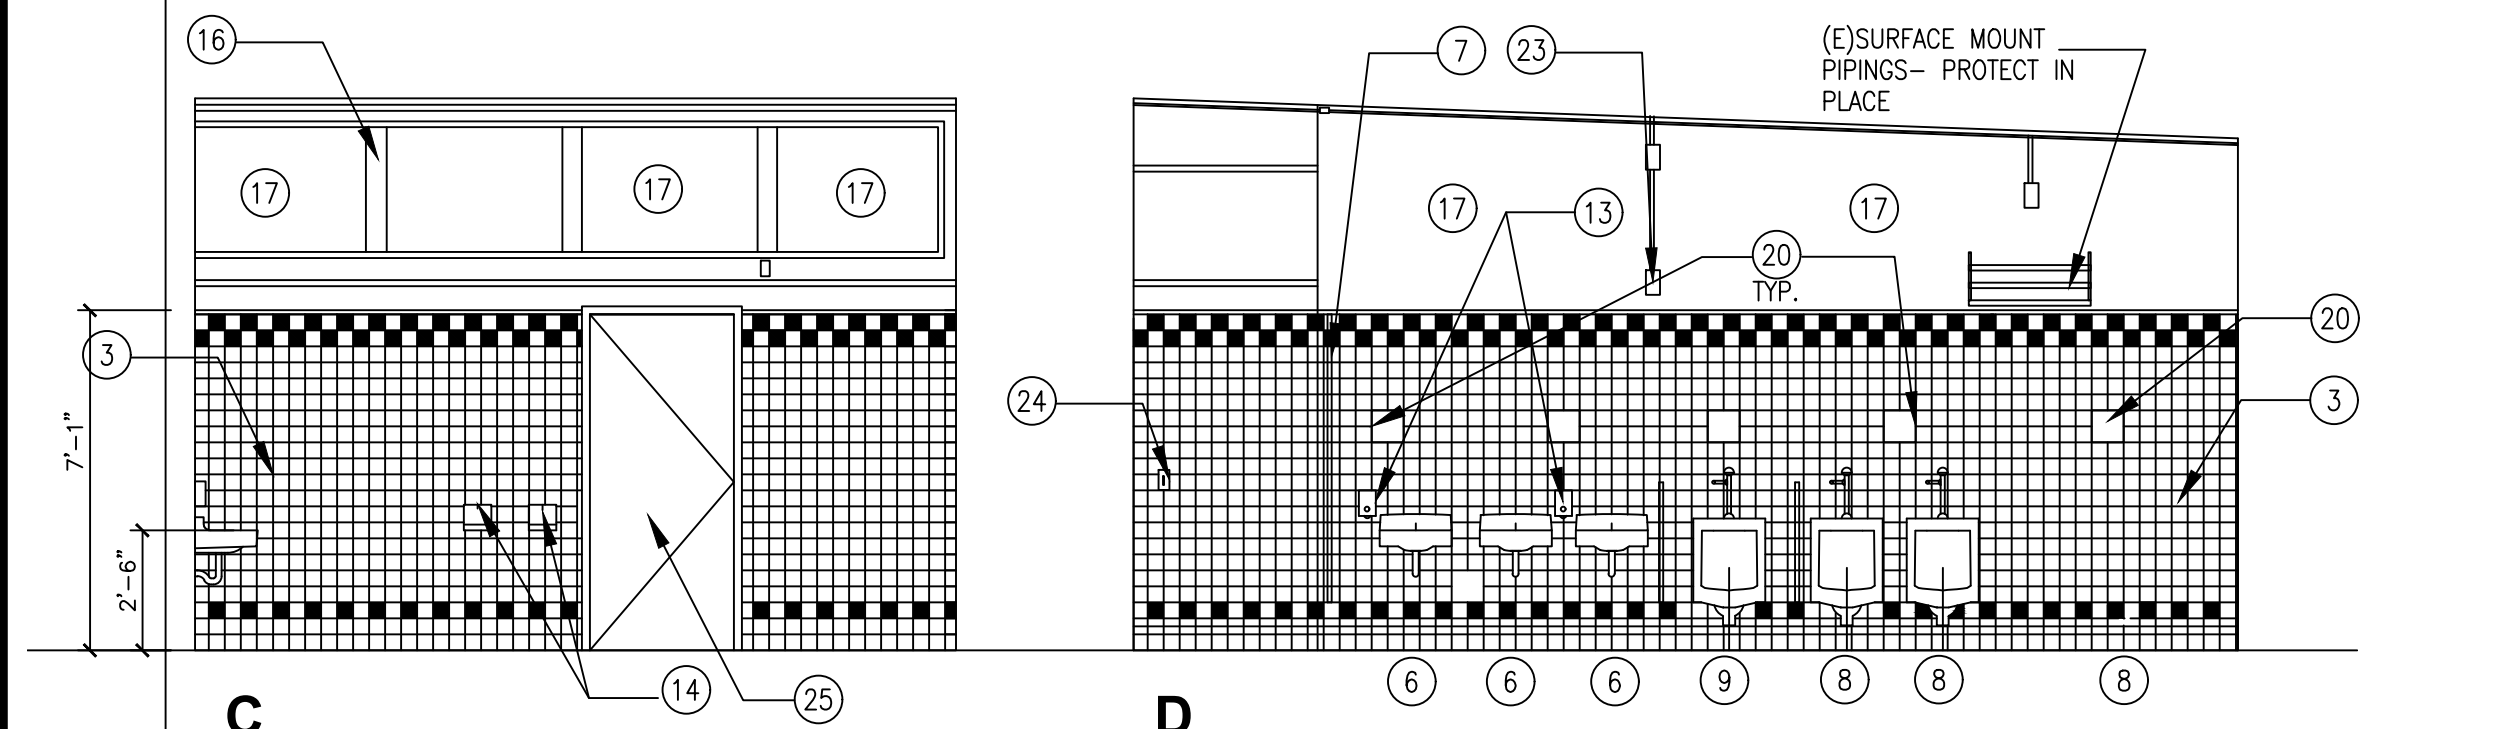

DEMO INTERIOR ELEVATION-BOYS RESTROOM

SCALE
1/4"=1'-0"


4

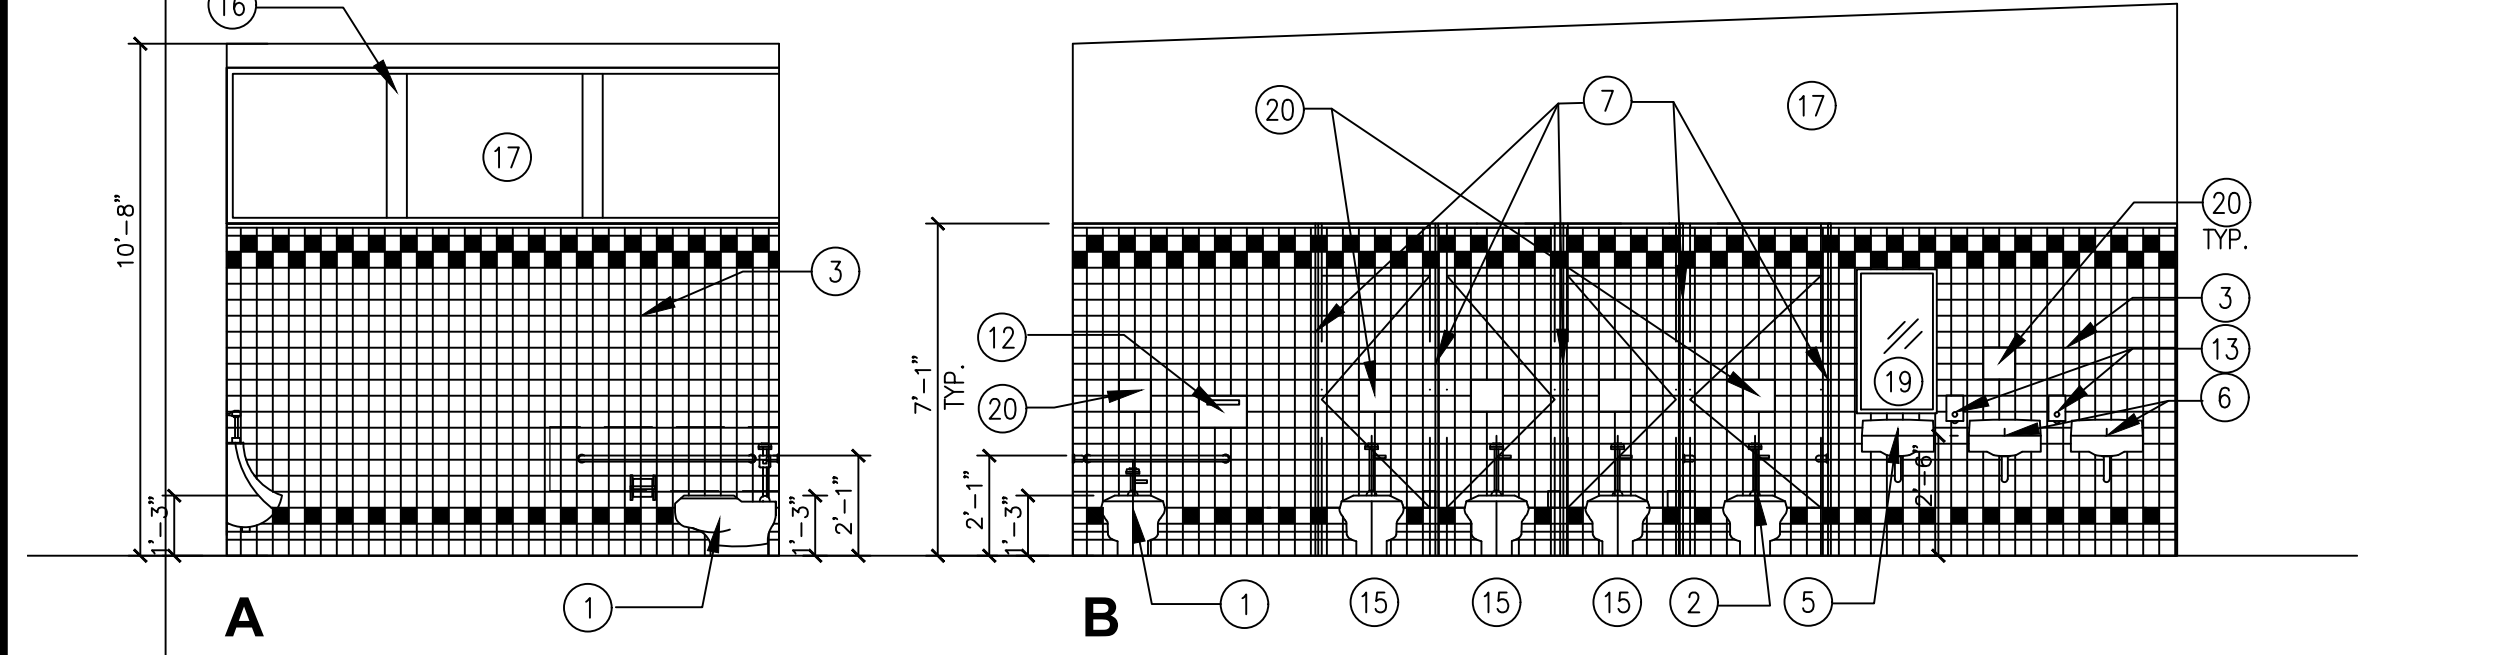

INTERIOR ELEVATION BOYS RESTROOM

SCALE
1/4"=1'-0"


3

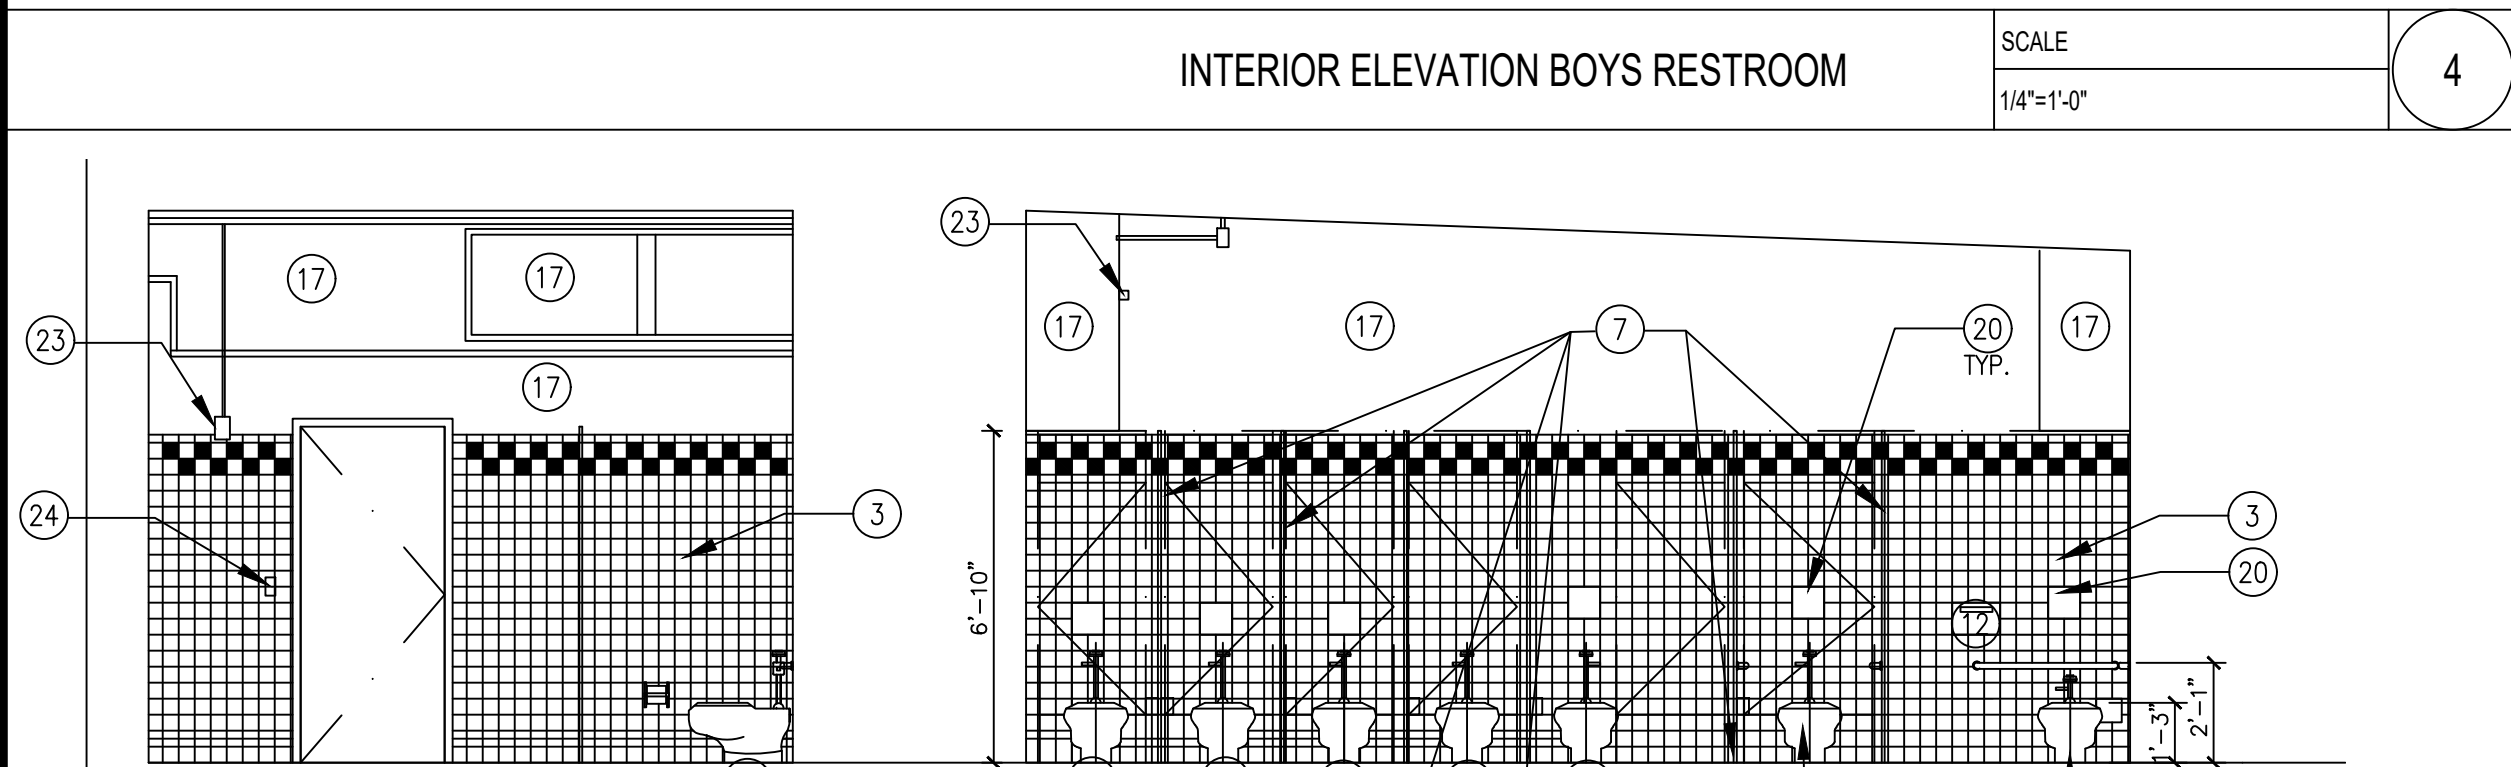

INTERIOR ELEVATION GIRLS RESTROOM

SCALE
1/4"=1'-0"


3

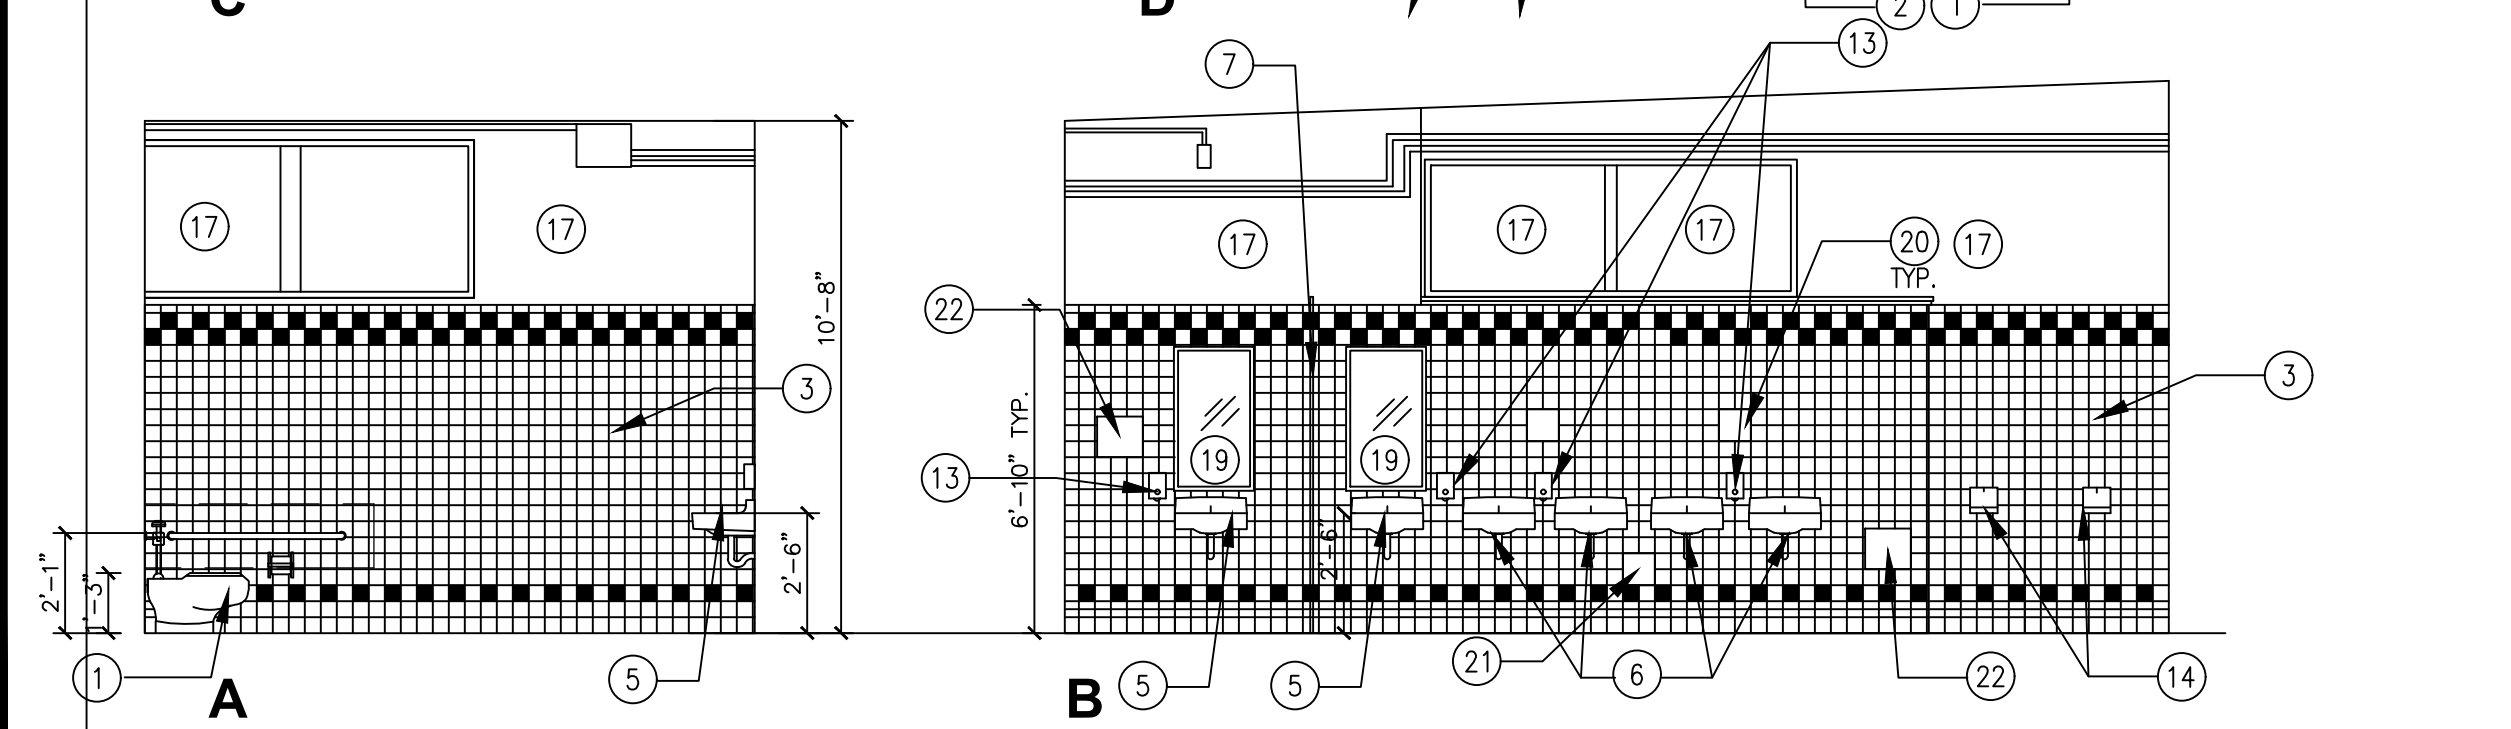

INTERIOR ELEVATION GIRLS RESTROOM

SCALE
1/4"=1'-0"


3

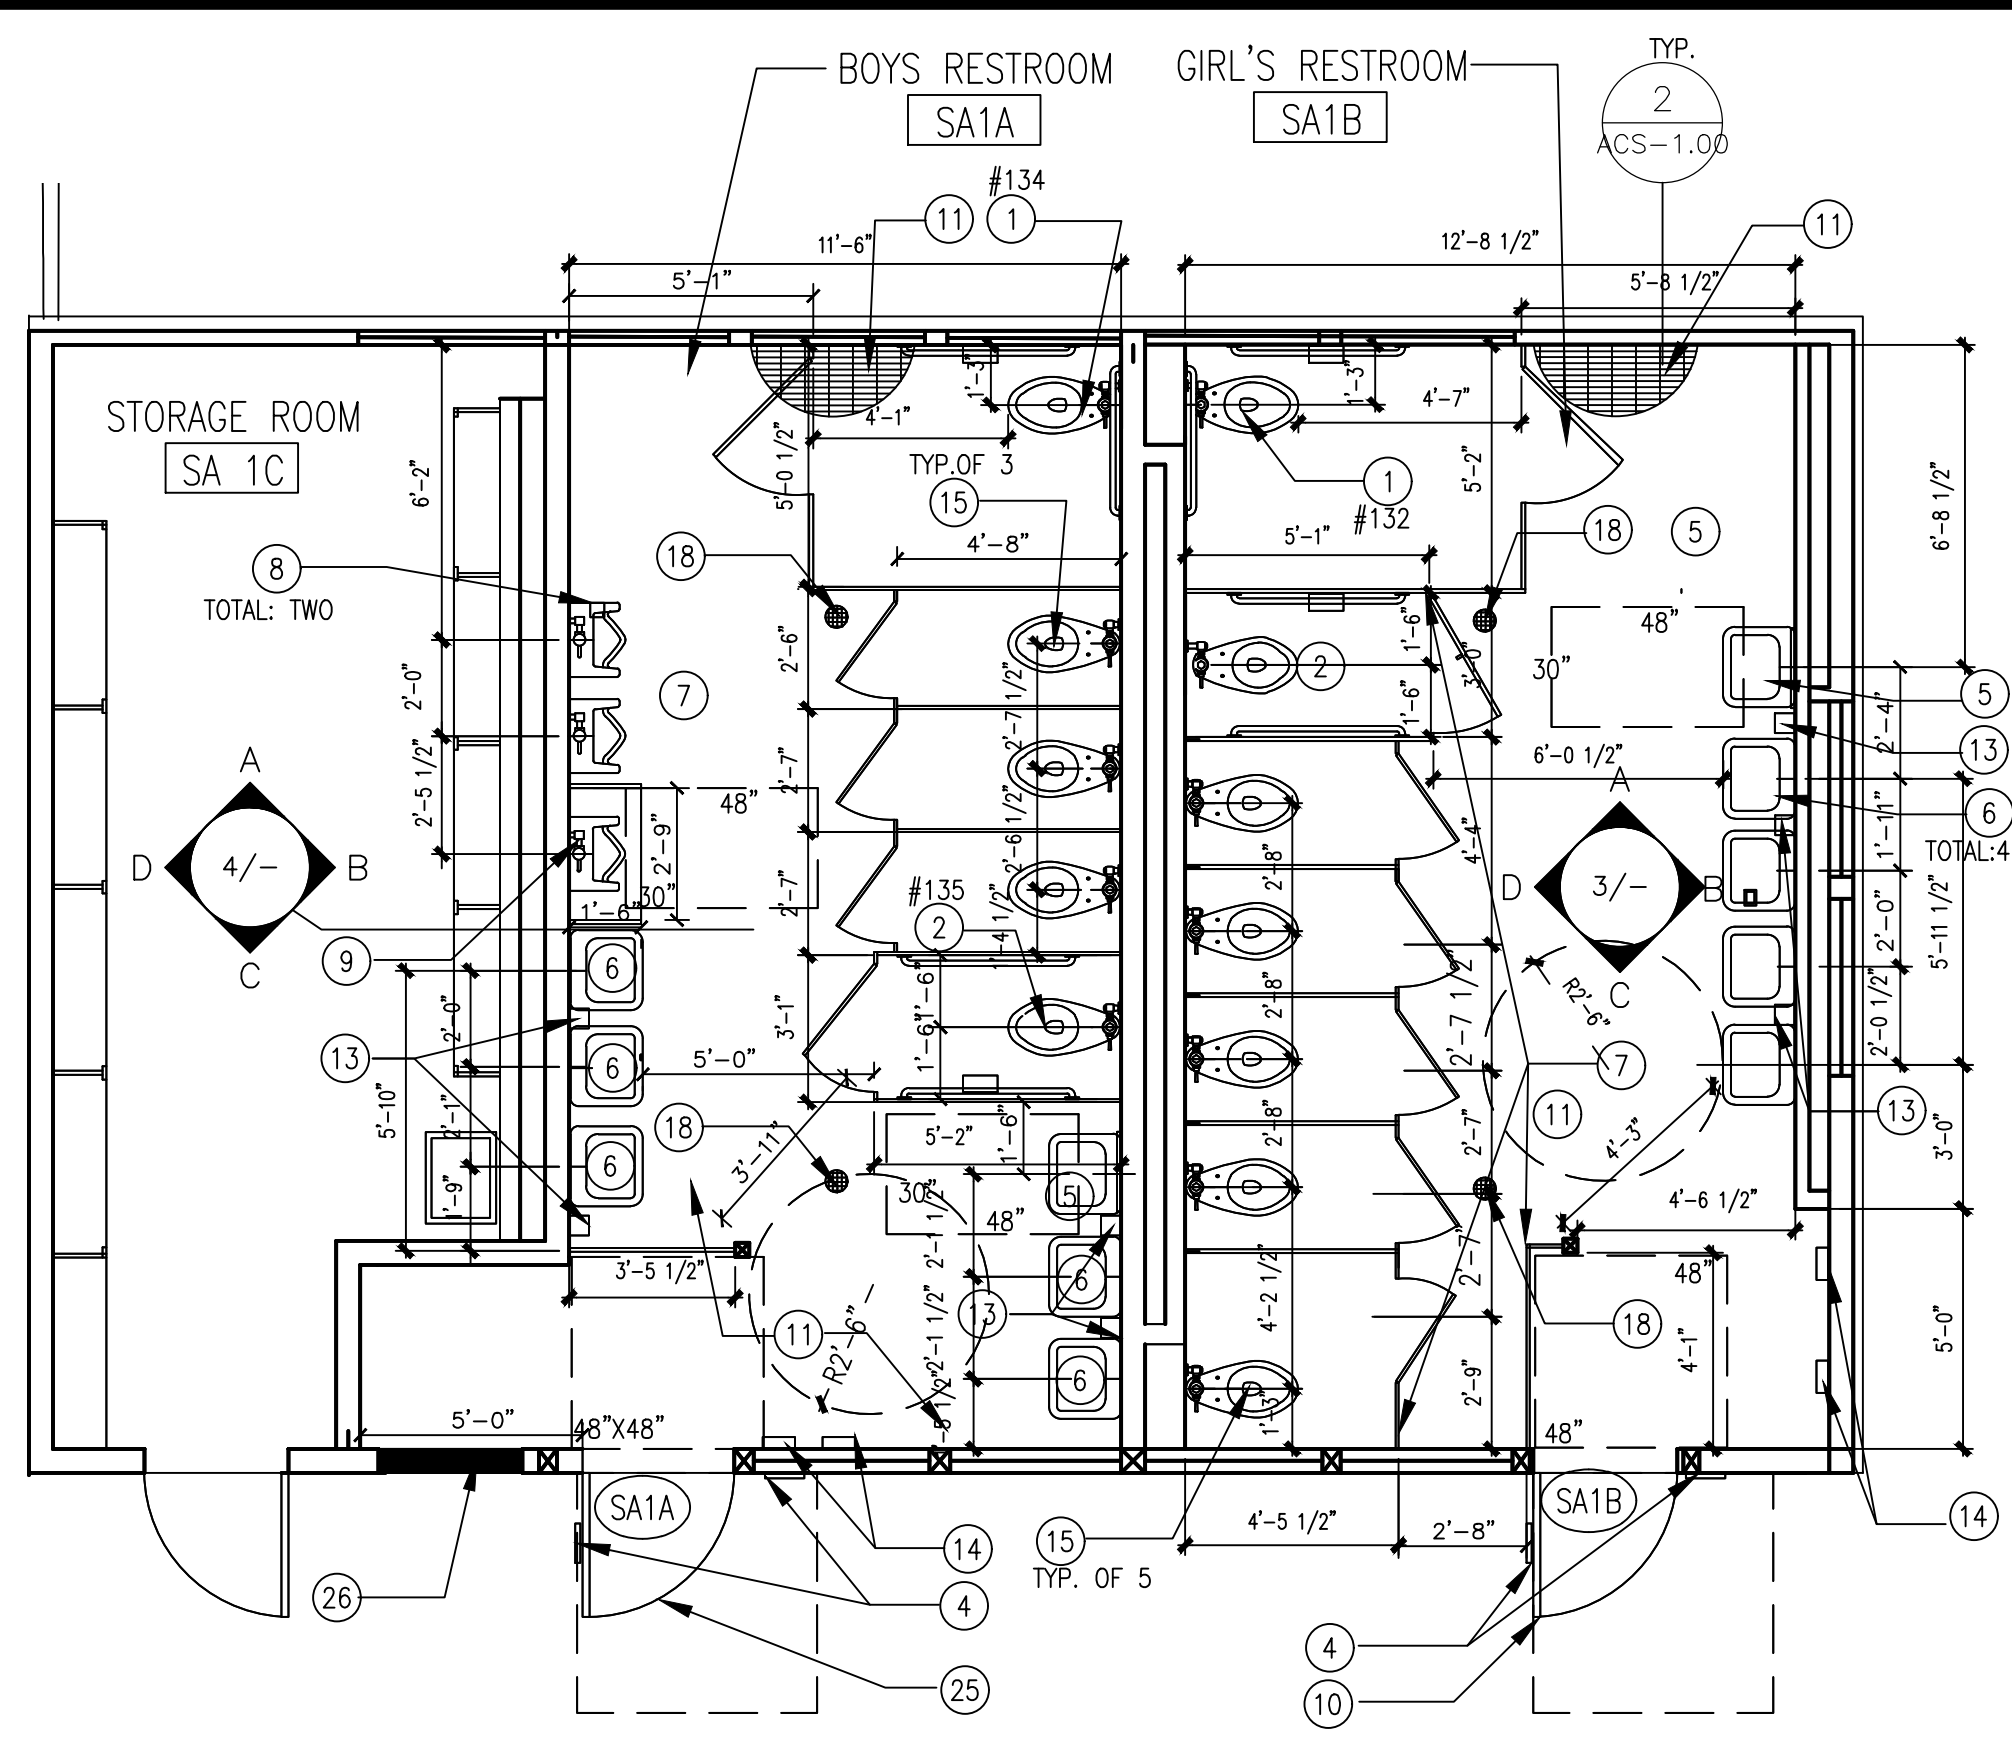

NEW FLOOR PLAN BOYS AND GIRLS - SANITARY #1

SCALE
1/4"=1'-0"

2

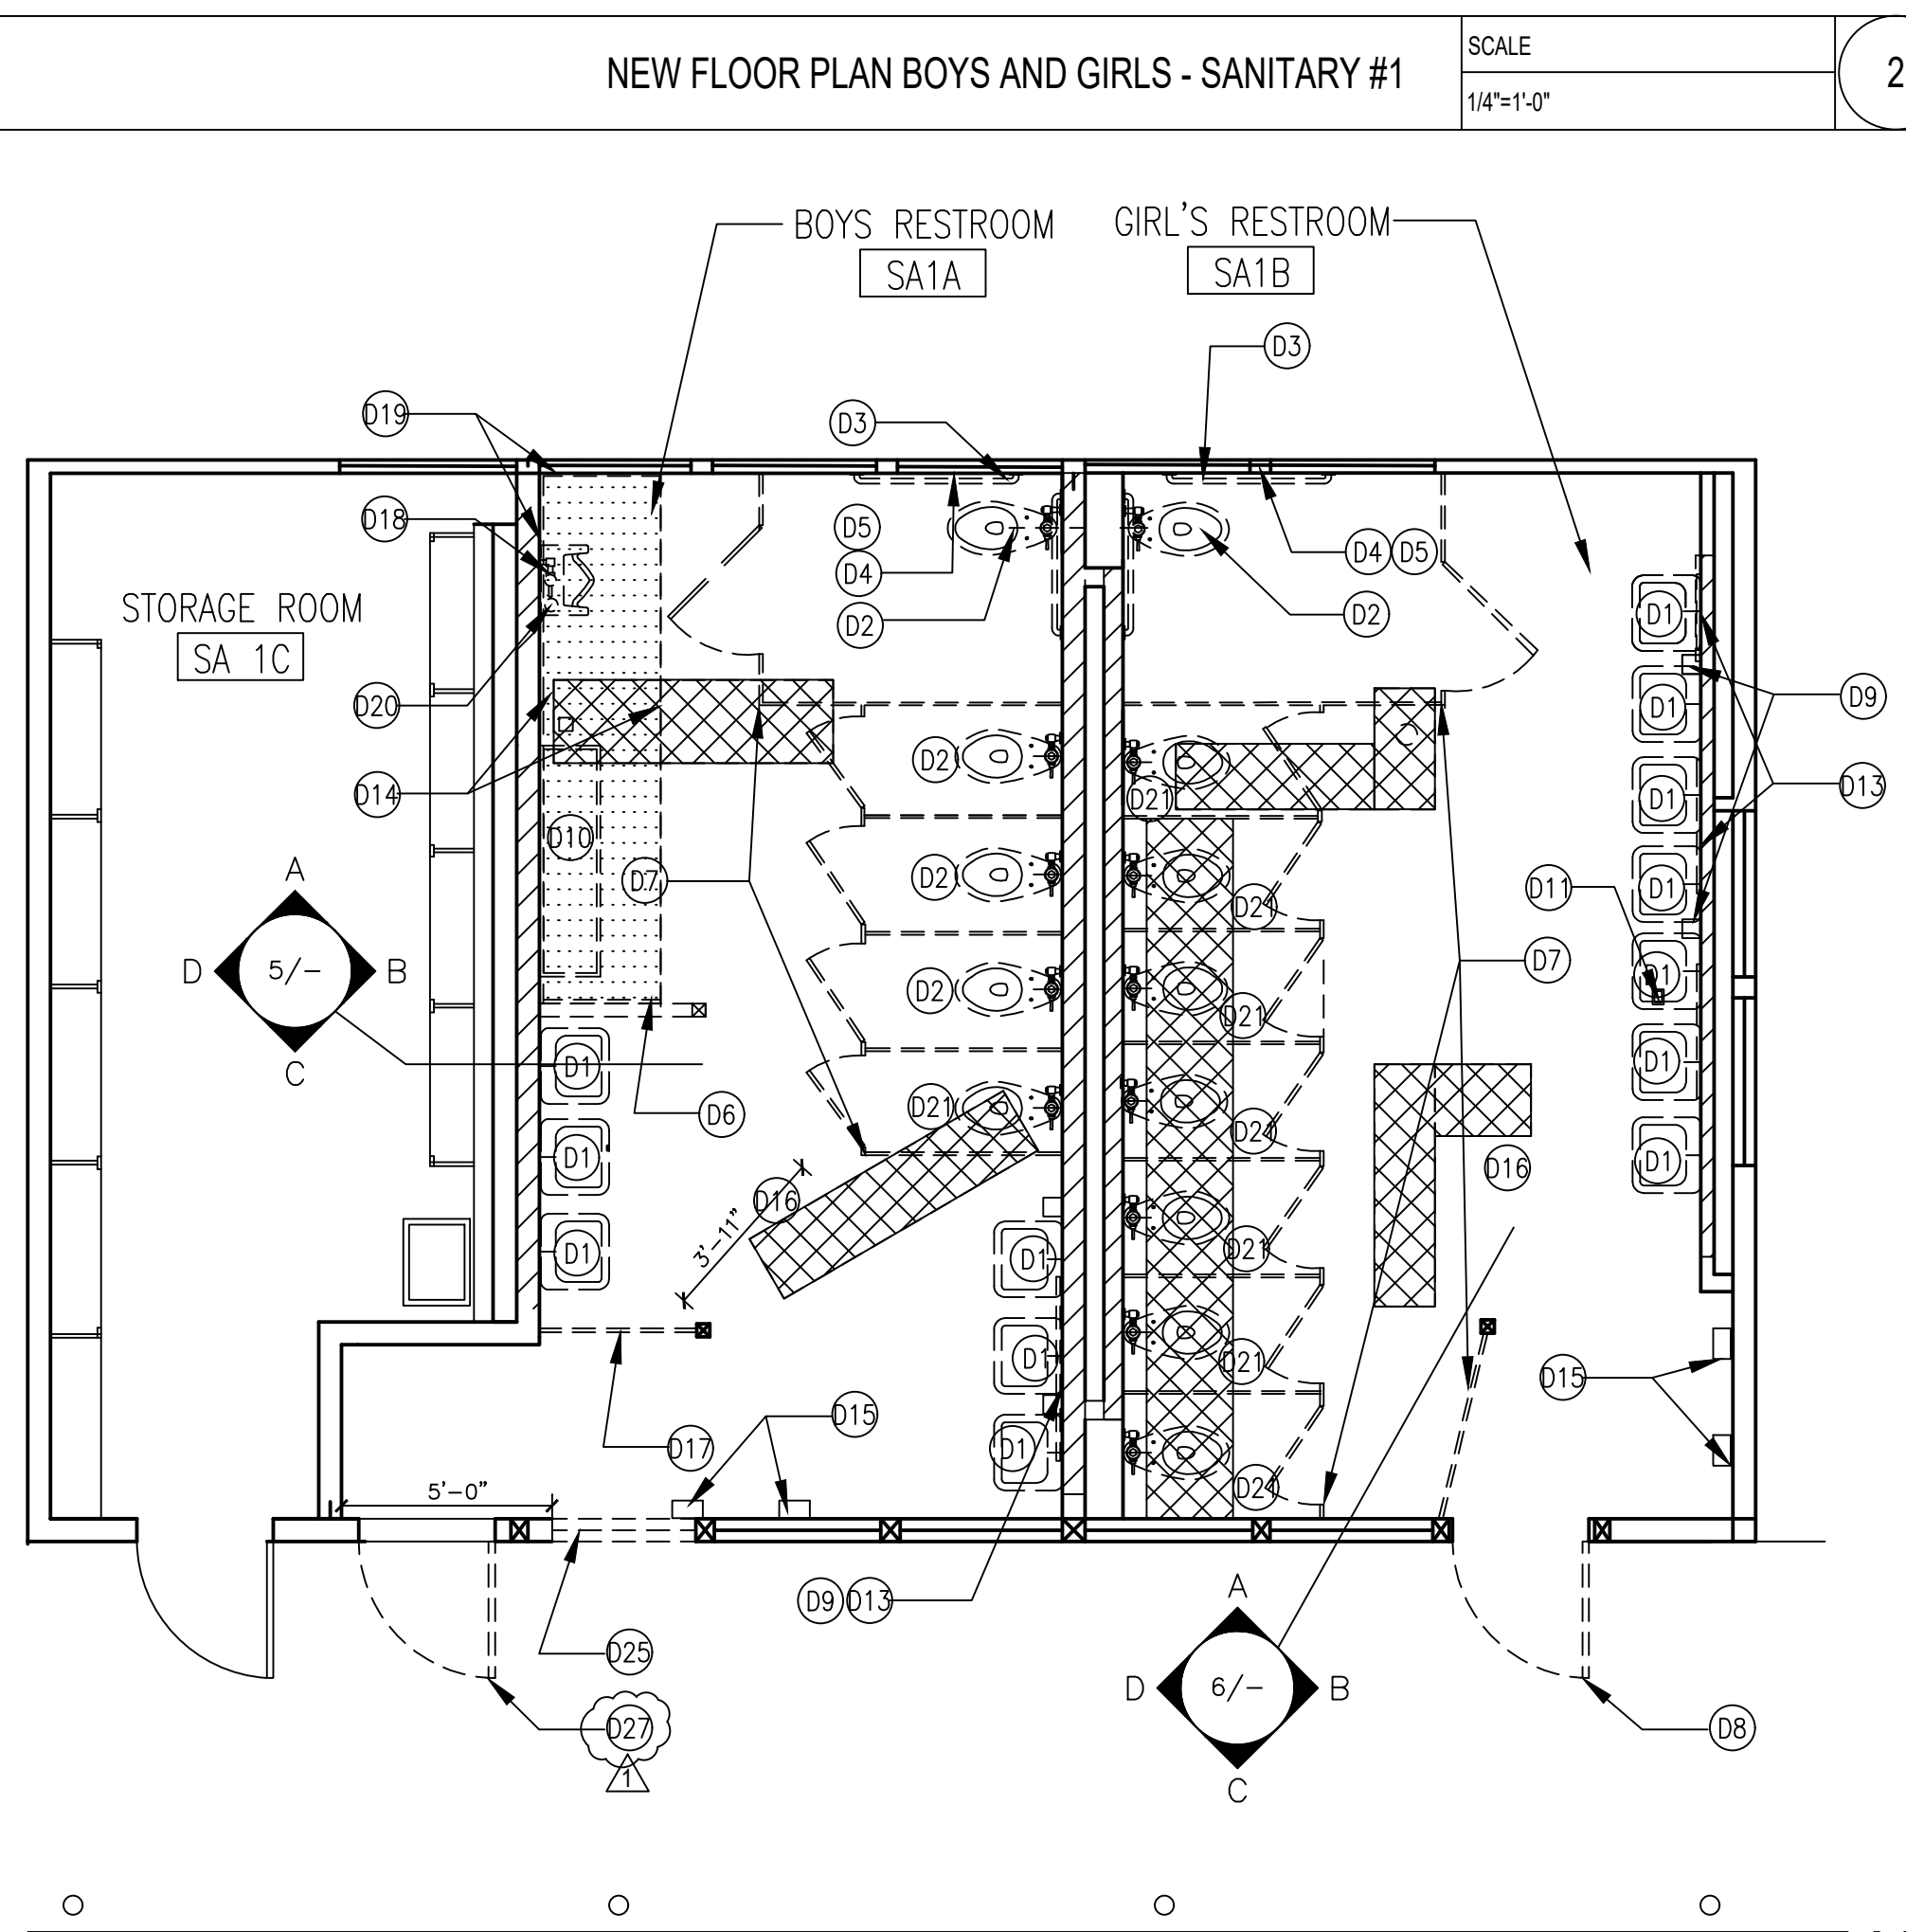

DEMO FLOOR PLAN BOYS AND GIRLS- SANITARY #1

SCALE
1/4"=1'-0"

1

GENERAL KEY NOTES

- 1- USE DETAIL BLOCKING 12/ACS-7.00 FOR ALL MOUNTING ACCESSORIES AND GRAB BAR AND WALL MOUNT PLUMBING FIXTURES.
- 2- USE BLOCKING DETAIL 17, 9/ACS-7.00 FOR PARTITION TOILET PANEL.
- 3- FOR ACCESSIBLE DIMENSIONS AND MOUNTING HEIGHTS. SEE SHEET ACS-7.00

DEMO KEY NOTES

- (D1) REMOVE EXISTING WALL MOUNT LAVATORY--PREP PLUMBING WALL TO RECEIVE NEW LAV. WHERE OCCURS
- (D2) REMOVE (E) FLOOR MOUNT WATER CLOSET
- (D3) REMOVE EXISTING GRAB BAR-- REMOVE PORTION FINISH WALL TO ADD (N) WOOD BLOCKING TO RECEIVE (N) ADA GRAB BAR.
- (D4) REMOVE (E) WALL MOUNT SURFACE TOILET PAPER.
- (D5) REMOVE (E) SURFACE MOUNT SEAT COVER DISPENSER.
- (D6) DEMO (E) WOOD STUD LOW WALL WITH PLASTER, WALL TILE AND CONCRETE CURB.
- (D7) REMOVE (E) WOOD TOILET PARTITION PANEL. PATCH HOLE AT (E) WALL AND FLOOR MATCH (E) FINISH.
- (D8) REMOVE (E) SOLID WOOD DOOR AND DOOR FRAME-- PREP TO RECEIVE (N) HM. DOOR FRAME AND DOOR
- (D9) REMOVE (E) SURFACE MOUNT SOAP DISPENSER
- (D10) REMOVE LONG (E) URINAL-- PREP PIPING TO RECEIVE NEW WALL MOUNT URINAL
- (D11) ADJUST (E) FLOOR DRAIN STRAINER TO FLUSH WITH NEW FLOOR TILE-- 1.5% MAX. SLOPE ANY DIRECTION TO DRAIN. SEE DETAIL 4/ACS-1.00
- (D12) REMOVE PORTION (E) PLYWOOD TO ADD (N) CONT. BLOCKING FOR PARTITION TOILET PANEL
- (D13) REMOVE (E) ALUM. FRAME MIRROR
- (D14) REMOVE (E) FLOOR TILE AND 2" THICK MORTAR BED-- PREP SURFACE TO FLUSH WITH (E) CONC. FLOOR
- (D15) REMOVE (E) SURFACE MOUNT ELEC. HAND DRYER
- (D16) REMOVE (E) EPOXY FLOOR, FINISH AND BASE-- PREP CONC. FLOOR LEVELING FOR NEW FLOOR TILE.
- (D17) REMOVE (E) WOOD PANEL
- (D18) REMOVE (E) URINAL, CAP PLUMBING PIPING IN WALL
- (D19) REMOVE (E) CERAMIC TILE AND 2" THICK MORTAR BED AT 4'-0" HIGH WAINSCOT-- ADD NEW PLYWOOD FLUSH (E) PLYWOOD MOUNT 8" CEMENT BOARD AT WALL TILE WALL.
- (D20) CAP (E) FLOOR DRAIN
- (D21) PREP SEWER LINE FOR NEW LOCATION OF WATER CLOSET
- (D22) REMOVE (E) METAL PANEL ACCESS TO PLUMBING VALVE-- PREP TO RECEIVE (N) PANEL
- (D23) REMOVE (E) KEY SWITCH-- REPLACE (N) STAINLESS STEEL KEY SWITCH FLUSH (N) FINISH OPEN PORTION (E) PLYWOOD FOR NEW PLUMBING LINE-- RE-INSTALL PLYWOOD--PREP TO INSTALL 8" CEMENT BOARD FOR NEW CERAMIC TILE
- (D24) PROVIDE NEW OPENING AT (E) WALL FOR NEW DOOR AND FRAME
- (D25) REMOVE PORTION (E) CURB TO FLUSH WITH (E) FINISH WALL
- (D27) REMOVE (E) DOOR, DOOR FRAME-- PREP TO IN FILL OPENING MATCH (E) WALL

KEY NOTES

- (1) ACCESSIBLE NEW-FLOOR MOUNT WATER CLOSET WITH GRAB BAR TO NEW BACKING AND NEW TILES. 4,12,15 ACS-7.00
- (2) FLOOR MOUNT AMBULATORY WATER CLOSET WITH GRAB BAR. SEE DETAIL 2,15 ACS-7.00
- (3) (N) 4"x4" CERAMIC TILE WITH THIN SET OVER NEW 8" CEMENT BOARD WITH BULLNOSE AT ALL EDGES. SEE 3,7/ACS-1.00
- (4) INSTALL RESTROOM SIGNAGE. SEE DETAIL 6 ACS-6.00
- (5) INSTALL ACCESSIBLE LAVATORY WITH WRAP INSULATED PIPING AND MIRROR. 3,11,14,15 ACS-7.00
- (6) INSTALL NEW WALL HUNG LAVATORY WITH INSULATED WRAP PIPING. 3,11 ACS-7.00
- (7) NEW TOILET PARTITION PANEL OVER NEW BLOCKING, DOOR AND HARDWARE. SEE 9,17 ACS-7.00
- (8) WALL MOUNT URINAL. SEE PLUMBING DWG.
- (9) ADA WALL MOUNT URINAL WITH PARTITION PANEL AT BOTH SIDE.. SEE 1,15 ACS-7.00
- (10) NEW DOOR, HM. DOOR FRAME AND DOOR HARDWARE. SEE SHEET ACS-8.00
- (11) NEW FLOOR TILE OVER MOTAR BED. SEE DETAIL 15/ACS-2.00
- (12) NEW TOILET COVER SEAT. MOUNTING HEIGHT SEE 14/ACS-7.00
- (13) SOAP DISPENSER. SEE 14/ACS-7.00
- (14) NEW ACCESSIBLE HAND DRYER. SEE DETAIL 19 ACS-2.00
- (15) (N) FLOOR MOUNT FLUSH VALVE WATER CLOSET, (AGE 6-12). 15,4 ACS-7.00
- (16) RE PAINT (E) WINDOW AND WOOD TRIM.
- (17) RE PAINT SEMI GLOSS WALL AND CEILING
- (18) NEW FLOOR DRAIN WITH 1.5% MAX. SLOPE FLOOR TILE TO DRAIN 4 ACS-1.00
- (19) WALL MOUNT MIRROR. PROVIDE BLOCKING. SEE SIM. 14,12 ACS-7.00
- (20) ACCESS PANEL/ CO. COVER. DETAIL FRAMING OPEN. SEE 7/ACS-9.00
- (21) HOSE BIB WITH COVER. SEE 2/P-5.00
- (22) (N) STAINLESS STEEL PANEL TO (E) UTILITY VALVE. SEE 7/ACS-9.00
- (23) (E) FIRE ALARM DEVICE--PROTECT IN PLACE
- (24) (N) STAINLESS STEEL KEY SWITCH FLUSH WITH CERAMIC TILE
- (25) NEW SOLID DOOR, HM. DOOR FRAME AND DOOR HARDWARE. SEE SHEET ACS-8.00
- (26) IN FILL WOOD STUD WITH PLASTER OUTSIDE AND CERAMIC INSIDE. SEE 11/ACS-9.00 AND 11/ACS-1.00

LEGEND

- EXISTING WOOD STUD WALL
- FLOOR TILE
- WALL TILE
- REMOVE (E) 3/4" PLYWOOD FINISH (SIDE OF RESTROOM) -- PREP FOR PLUMBING AND WALL CERAMIC TILE
- DEMO (E) CONCRETE SLAB FOR NEW PLUMBING AND PATCH SLAB AND INSTALL NEW FLOOR TILE . SEE 11/ACS-2.00
- REMOVE (E) FLOOR TILE AND MORTAR BED
- IN FILL (E) OPENING WALL OPENING. SEE 11/ACS-9.00
- DEMO (E) WALL FOR NEW DOOR.

LOS ANGELES UNIFIED SCHOOL DISTRICT
ASSET MANAGEMENT
FACILITIES SERVICES DIVISION
333 S. BEAUDRY AVENUE, 23RD FLOOR
LOS ANGELES, CALIFORNIA 90017

PROJECT TITLE AND SCHOOL LOCATION

STRATHERN STREET
SCHOOL

VOLUNTARY BARRIER
REMOVAL

7939 ST. CLAIRE AVENUE.
N. HOLLYWOOD, CA 91605

COLIN ID No.: 10373687

DSA# 03-125645

COMMISSIONED ARCHITECT

MLA
ML ARCHITECTURE
355 PASADENA AVENUE
SOUTH PASADENA, CA91030


STAMPS/SEALS



CONSULTANT

STAMPS/SEALS

KEY PLAN

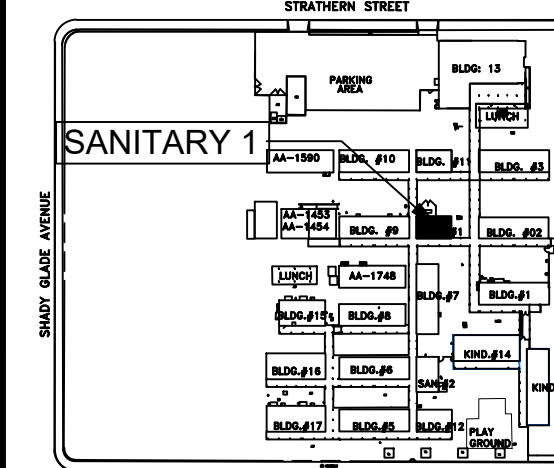

ADDED 1 06/02/26

SHEET TITLE:

**SANITARY 1
FLOOR PLAN**

PROJECT NO.: 23004

PROJECT ARCH: ML ARCHITECTURE

DRAWN: T PHAN


CHECKED: MUN LEU

SHEET NUMBER

DATE: 10-24-2025

SHEET: OF:


A-5.00

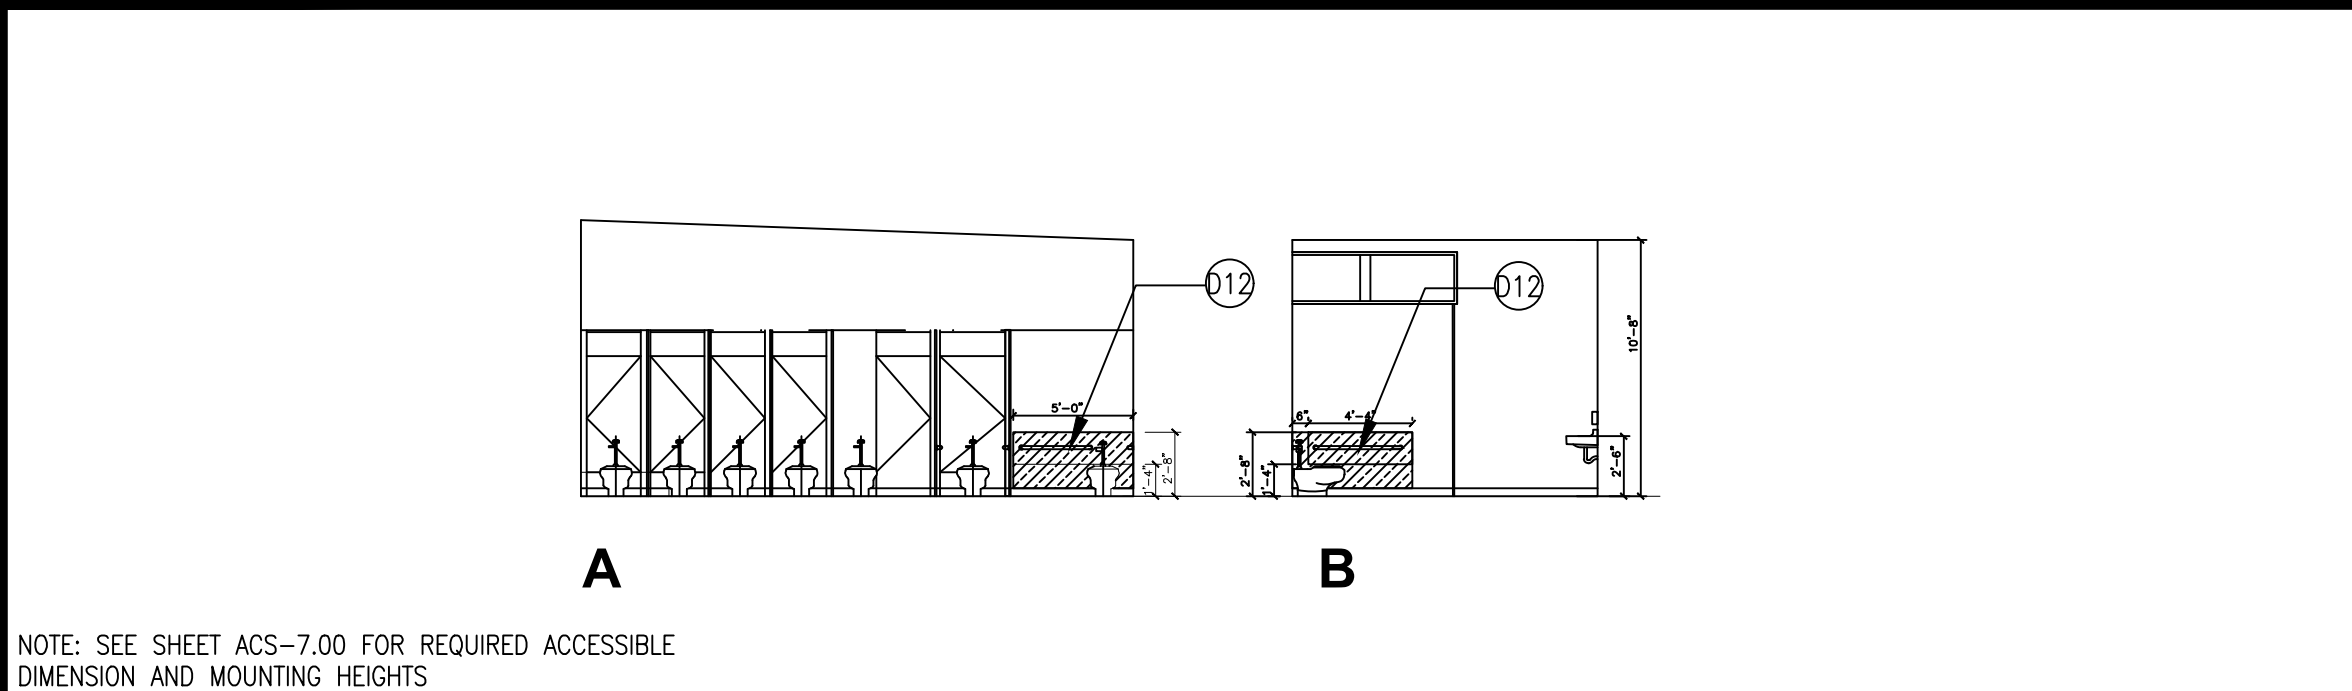

DEMO GIRLS RESTROOM INTERIOR ELEVATION

SCALE
1/8"=1'-0"


6

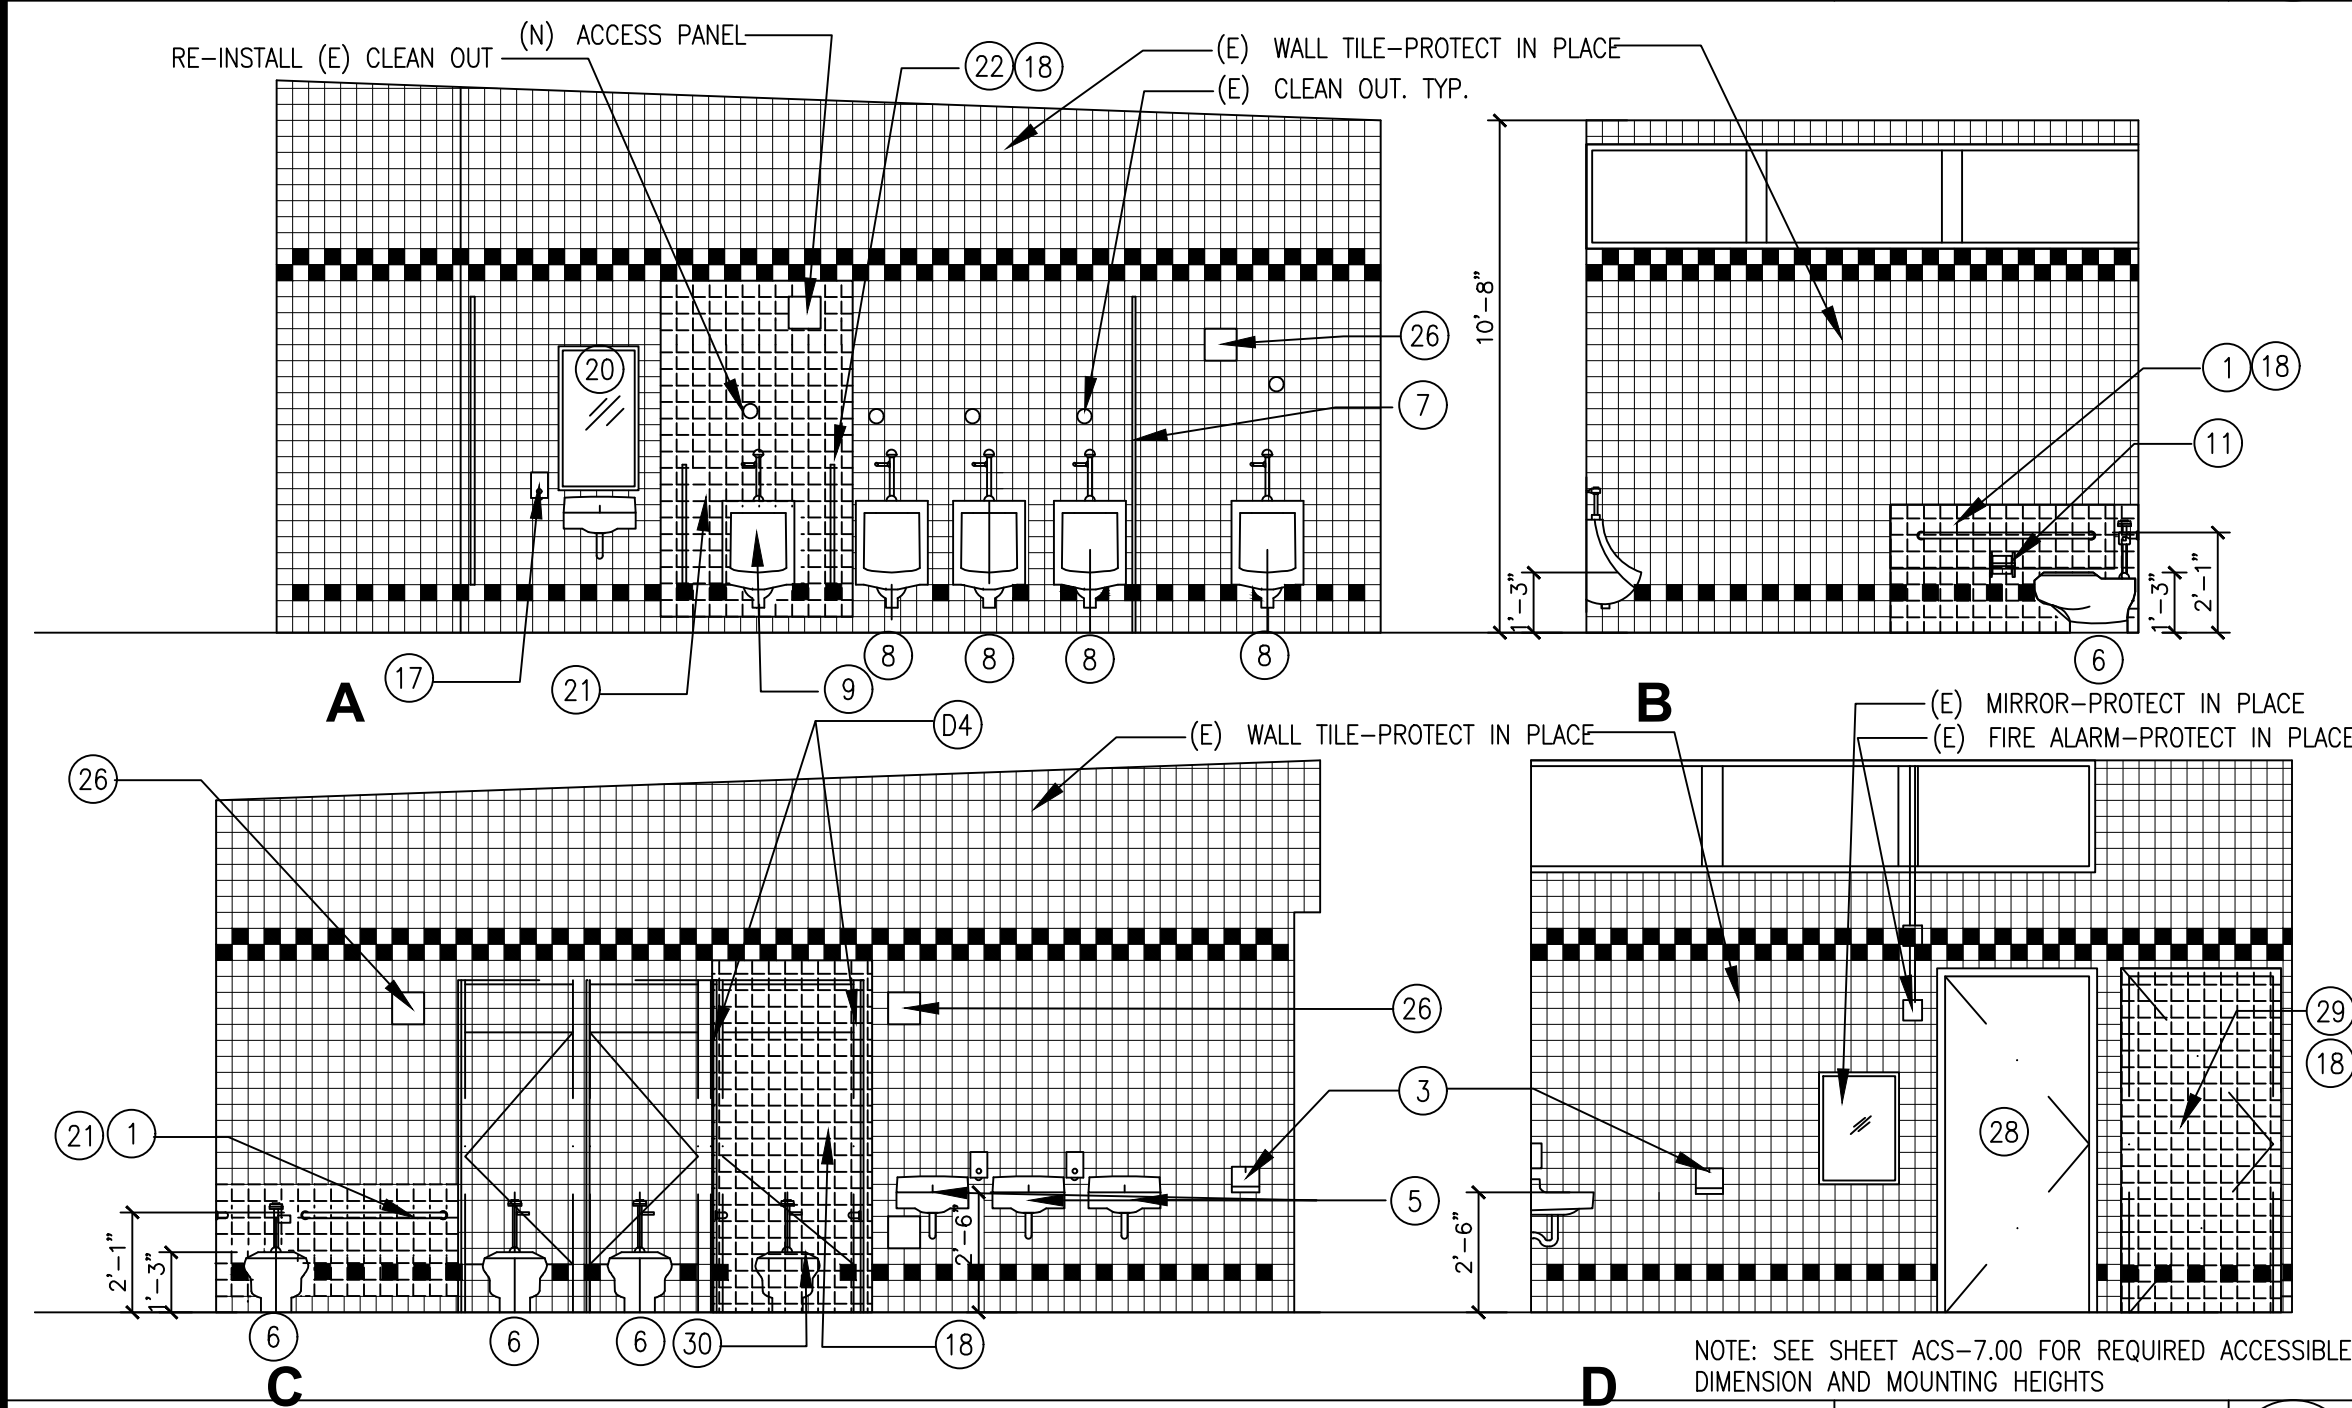

BOYS RESTROOM INTERIOR ELEVATION

SCALE
1/4"=1'-0"


4

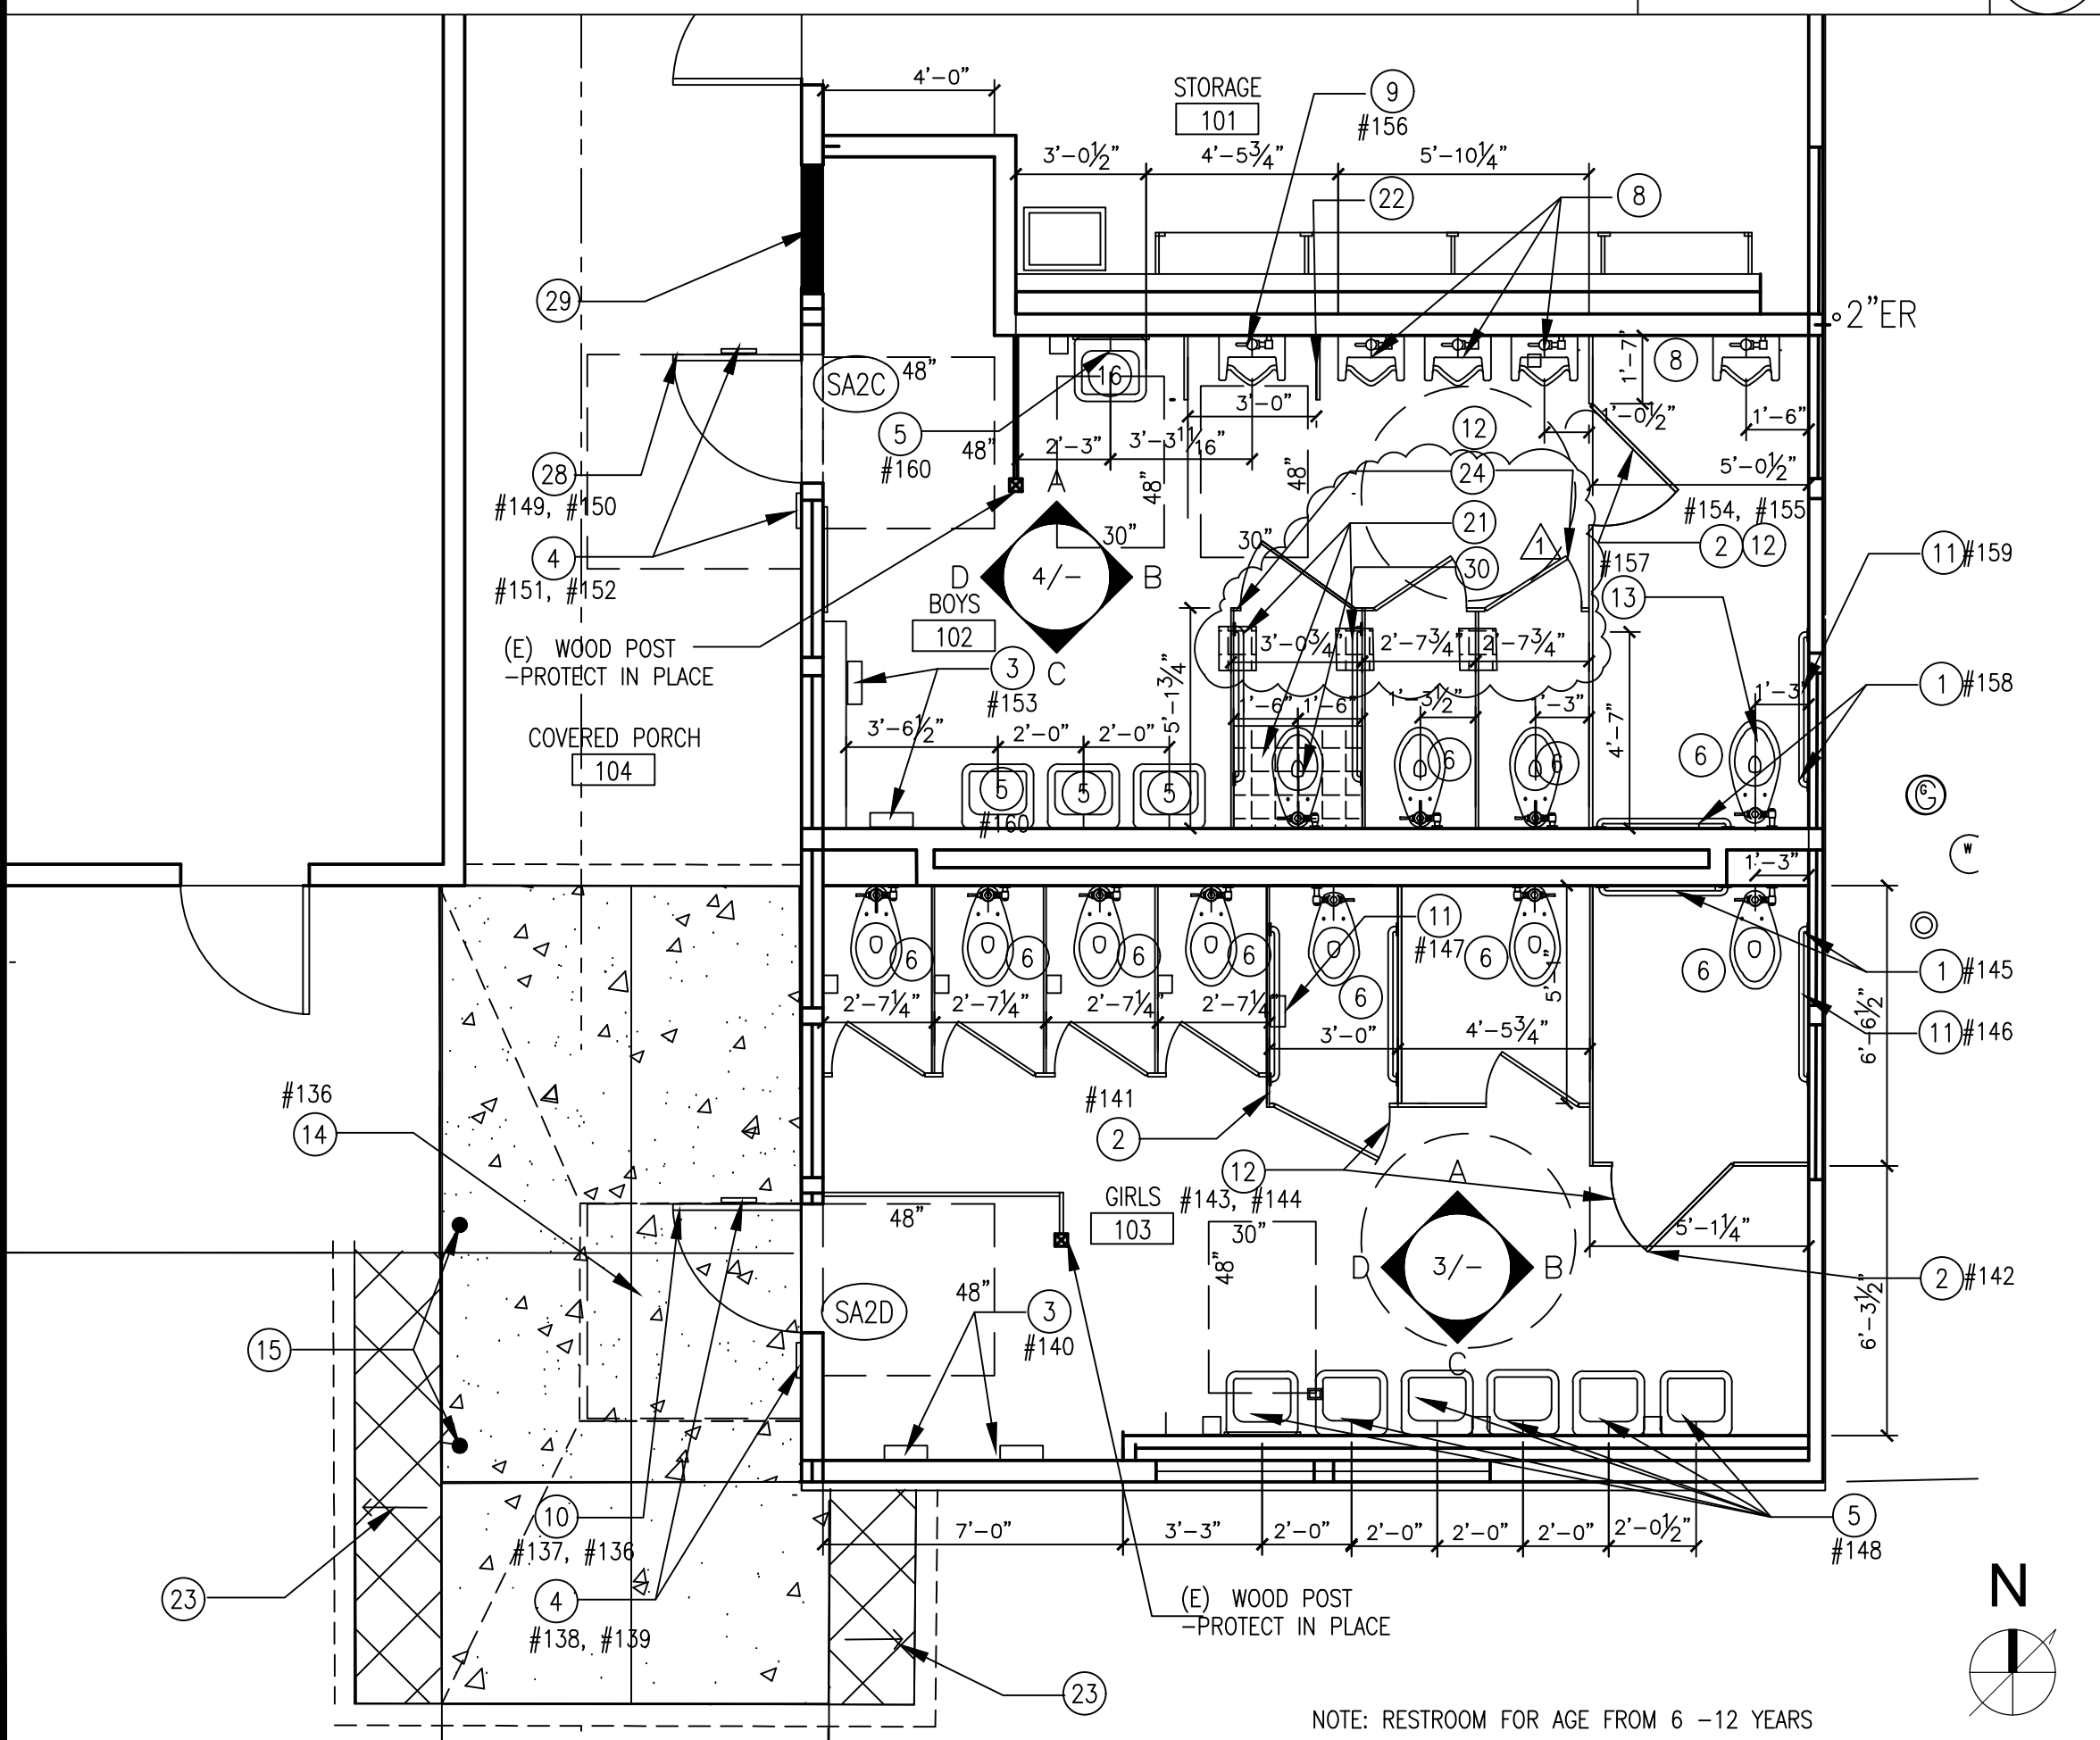

NEW FLOOR PLAN SANITARY #2

SCALE
1/4"=1'-0"


2

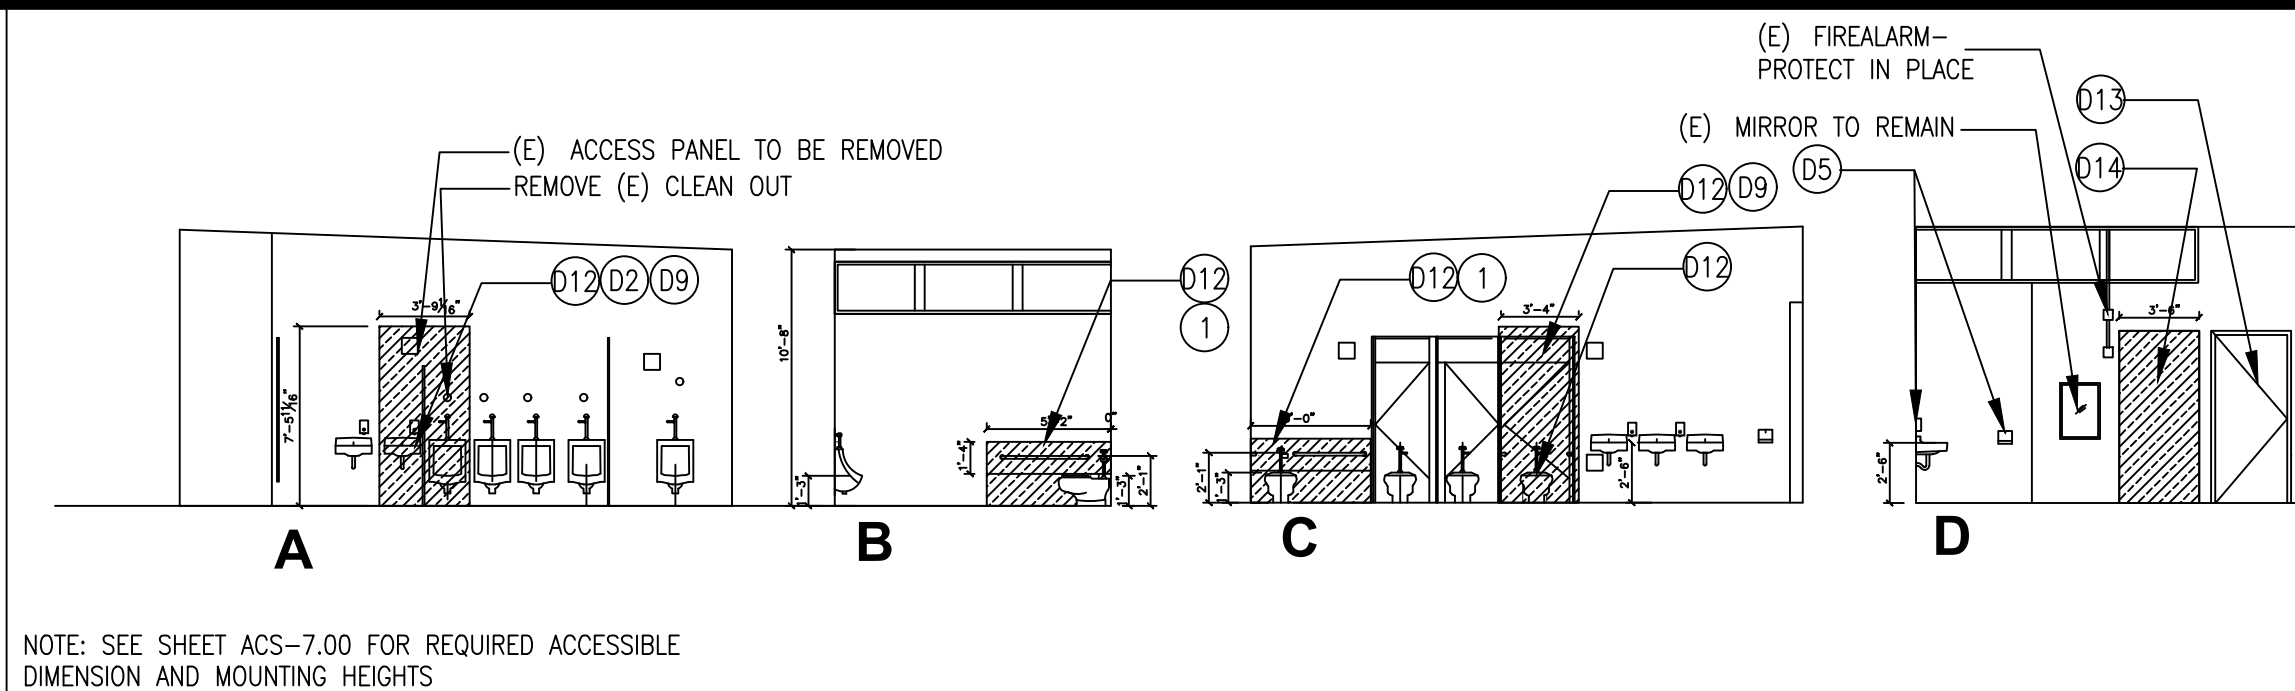

DEMO BOYS RESTROOM INTERIOR ELEVATION

SCALE
1/8"=1'-0"


5

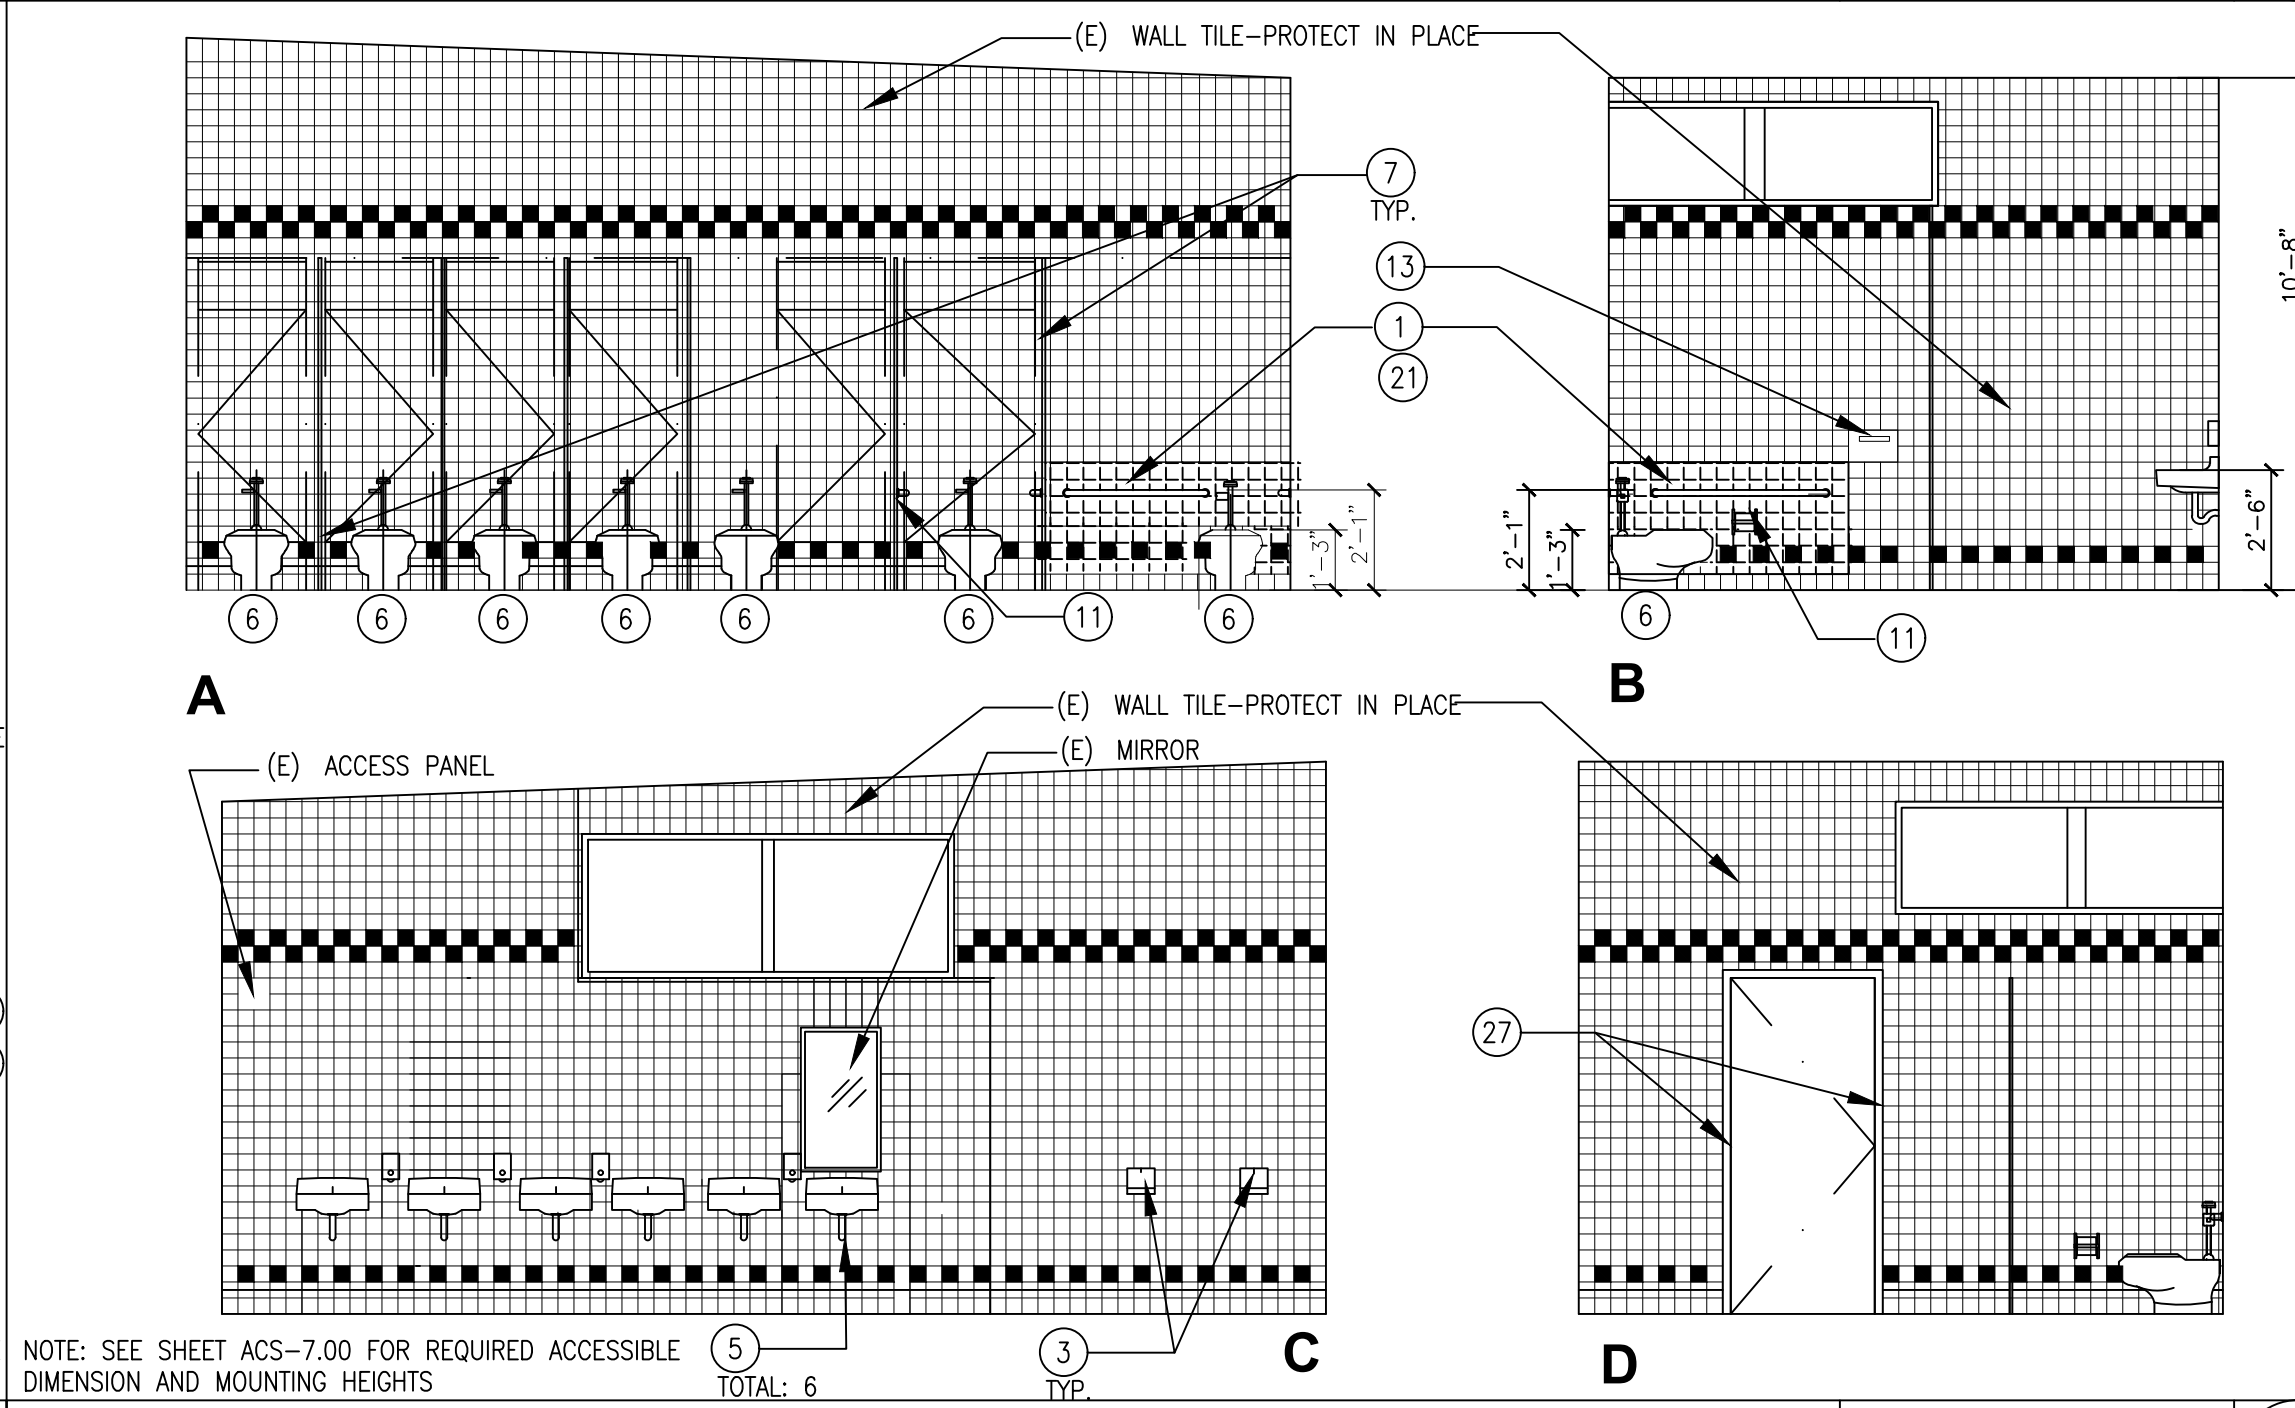

GIRL'S RESTROOM INTERIOR ELEVATION

SCALE
1/4"=1'-0"

3

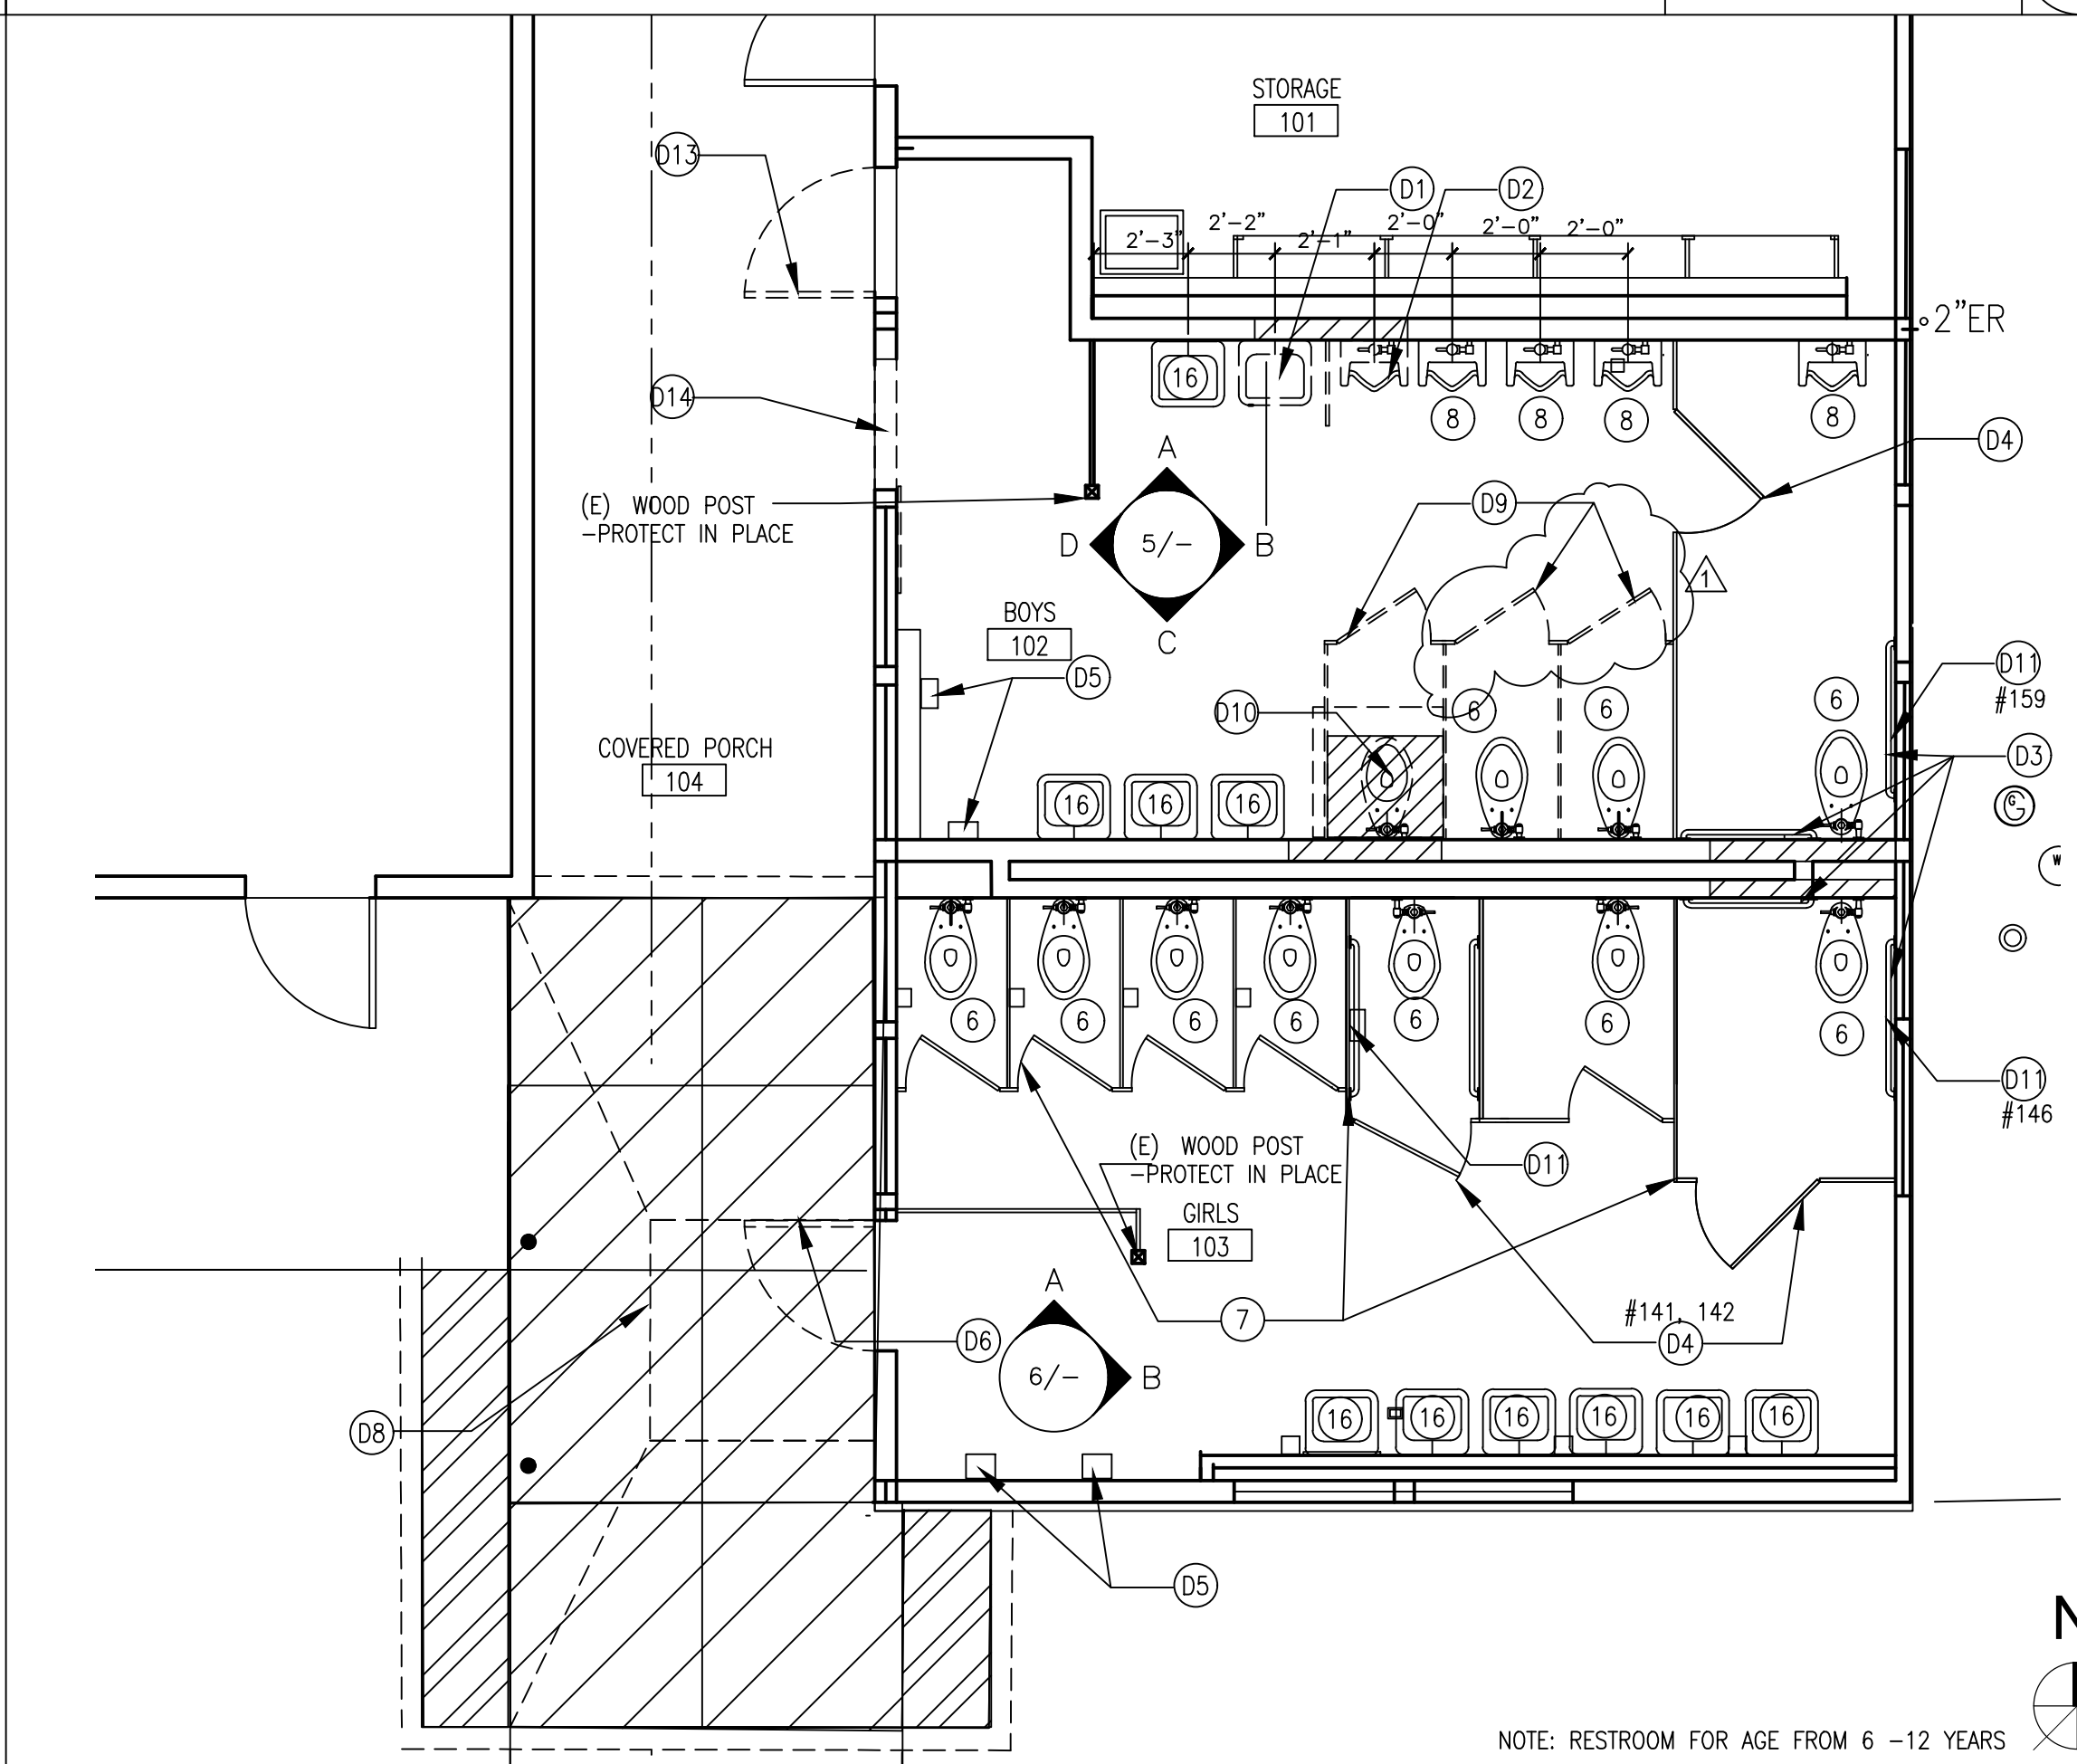

DEMO FLOOR PLAN SANITARY #2

SCALE
1/4"=1'-0"

1

GENERAL KEY NOTES

- 1- USE DETAIL BLOCKING 12/ACS-7.00 FOR ALL MOUNTING ACCESSORIES AND GRAB BAR AND WALL MOUNT PLUMBING FIXTURES.
- 2- USE BLOCKING DETAIL 17, 9/ACS-7.00 FOR PARTITION TOILET PANEL.
- 3- FOR ACCESSIBLE DIMENSIONS AND MOUNTING HEIGHTS. SEE SHEET ACS-7.00

DEMO KEY NOTES


- (D1) REMOVE EXISTING WALL HUNG LAVATORY.
- (D2) REMOVE (E) WALL MOUNT URINAL.
- (D3) REMOVE EXISTING STAINLESS STEEL GRAB BAR
- (D4) REMOVE (E) SELF CLOSER HINGE- PREP FOR NEW ONE
- (D5) REMOVE (E) WALL ELEC. HAND DRYER
- (D6) REMOVE (E) WOOD DOOR, HARDWARE, THRESHOLD AND WOOD DOOR FRAME- PREP FOR NEW HM. DOOR FRAME AND NEW DOOR WITH NEW HARDWARE
- (D7) REMOVE (E) MIRROR AND FRAME
- (D8) REMOVE PORTION (E) 4" THICK CONCRETE PAVING AND REBAR. SEE DETAIL 15/ACS-1.00
- (D9) REMOVE (E) PORTION TOILET PANEL AND DOOR- PREP TO RECEIVE NEW PANEL PATCH FINISH FLOORS AND WALL TO MATCH (E), SEE DETAIL 9/ACS-7.00
- (D10) REMOVE (E) FLOOR MOUNT TOILET, PREP SEWER LINE TO RECEIVE NEW WATER CLOSET
- (D11) REMOVE (E) SURFACE MOUNT TOILET PAPER DISPENSER
- (D12) REMOVE PORTION (E) WALL TILE (E) 1/2" PLYWOOD FOR NEW WORK. OPEN PLYWOOD FROM STUD TO STUD ALLOW TO RE-INSTALL PLYWOOD TO (E) STUD
- (D13) REMOVE (E) WOOD DOOR, FRAME AND HARDWARE- PREP INFILL IN (E) OPENING
- (D14) NEW OPENING (E) WALL TO INSTALL NEW DOOR, HM. DOOR FRAME AND NEW HARDWARE

KEY NOTES

- (1) INSTALL NEW BLOCKING AND GRAB BAR AT MOUNTING HEIGHT COMPLY ADA, SEE 4,12,15 ACS-7.00
- (2) INSTALL (N) SELF CLOSING HINGE AT ALL DOOR ACCESSIBLE AT COMPARTMENT DOOR
- (3) INSTALL NEW ADA ELEC. HAND DRYER TO (E) ELEC. OUTLET. SEE 14 ACS-7.00
- (4) INSTALL RESTROOM SIGNAGE. SEE DETAIL 6 ACS-6.00
- (5) WRAP INSULATED PIPING AT (E) LAVATORY
- (6) (E) WATER CLOSET- PROTECT IN PLACE
- (7) (E) TOILET PARTITION PANEL AND DOOR-PROTECT IN PLACE
- (8) (E) WALL MOUNT URINAL-PROTECT IN PLACE
- (9) ADA WALL MOUNT URINAL WITH PRIVACY PANEL AT BOTH SIDE. SEE 1 ACS-7.00
- (10) NEW DOOR, DOOR HARDWARE AND HM. DOOR FRAME. SEE DOOR SCHEDULE A-8.00
- (11) INSTALL NEW TOILET PAPER DISPENSER TO NEW BLOCKING. SEE DETAIL 4,12,15/ACS-7.00
- (12) INSTALL DOOR PULL AT ACCESSIBLE AND SEMI-AMBULATORY COMPARTMENT
- (13) INSTALL NEW TOILET SEAT (NO MORE THAN 2" THICK MAINTAINING HEIGHT 17" TO 19" AFF)
- (14) NEW CONCRETE PAVING. SEE CIVIL DWG. C-3.01
- (15) PROTECT IN PLACE (E) CONCRETE FOOTING OF STEEL COL.
- (16) EXISTING LAVATORY- PROTECT IN PLACE
- (17) INSTALL SOAP DISPENSER TO (E) ADA LAVATORY COMPLY WITH ADA MOUNTING HEIGHT (FOR ELEMENTARY SCHOOL). SEE 14,15 ACS-7.00
- (18) NEW CERAMIC TILE OVER 8" CEMENT BOARD TO MATCH (E) FINISH. SIM. DETAIL 2/ACS-1.00
- (19) WALL HUNG NEW ACCESSIBLE LAVATORY. SEE DETAIL 7,11,15 ACS-7.00
- (20) RE-INSTALL MIRROR, MOUNTING HIGH. SEE DETAIL 14 ACS-7.00
- (21) PATCH HOLE AT (E) CONCRETE FLOOR AND FINISH TILE FLOOR TO MATCH (E) CERAMIC TILE
- (22) NEW PRIVACY SCREEN. SEE 1/ACS-7.00
- (23) NEW ASPHALT PAVING WITH SLOPE 1% MIN. AWAY BLDGS. SEE CIVIL C-3.01
- (24) INSTALL NEW PARTITION PANEL AND CONTINUOUS HINGE SELF CLOSING DOOR AND DOOR HANDLES.. SEE 2/ACS-7.00 FOR BLOCKING. SEE 17/ACS-7.00
- (25) EXISTING CLEAN OUT WITH COVER- PROTECT IN PLACE
- (26) EXISTING SOV W/AP-PROTECT IN PLACE
- (27) NEW WALL TILE AND PREP EXT. PLASTER AT NEW HM. DOOR FRAME
- (28) NEW SOLID DOOR WITH WOOD HARDWARE AND HM. DOOR FRAME. SEE DOOR SCHEDULE ACS-8.00
- (29) IN FILL WOOD STUD WITH PLASTER OUTSIDE AND CERAMIC INSIDE. SEE 11/ACS-9.00 AND 11/ACS-1.00
- (30) NEW FLOOR MOUNT ADA WATER CLOSET WITH GRAB BAR BOTH SIDE. SEE 2/ACS-7.00

LEGEND

- EXISTING WOOD STUD WALL
- DEMO ASPHALT
- NEW ASPHALT PAVING. SEE SHEET C-3.01
- OPEN WALL FOR PLUMBING WORK AND BLOCKING
- NEW CONCRETE PAVING. SEE SHEET C-3.01
- DEMO (E) CONCRETE PAVING OR SLAB
- PATCH CONCRETE FLOOR AND FINISH TILE FLOOR AND WALL MATCH (E) FINISH
- EXISTING CERAMIC TO (E) WALL
- IN FILL (E) OPENING WALL OPENING. SEE 11/ACS-9.00
- DEMO OPENING FOR NEW DOOR
- REMOVE PORTION (E) WALL TILE AND (E) 1/2" PLYWOOD FOR NEW WORK.

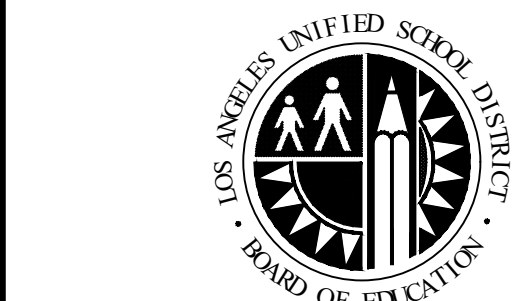

**LOS ANGELES UNIFIED
SCHOOL DISTRICT**
**ASSET MANAGEMENT
FACILITIES SERVICES DIVISION**
333 S. BEAUDRY AVENUE, 23RD FLOOR
LOS ANGELES, CALIFORNIA 90017

PROJECT TITLE AND SCHOOL LOCATION


**STRATHERN STREET
SCHOOL**
**VOLUNTARY BARRIER
REMOVAL**
7939 ST. CLAIRE AVENUE.
N. HOLLYWOOD, CA 91605
COLIN ID No.: 10373687

DSA# 03-125645

COMMISSIONED ARCHITECT

MLA
ML ARCHITECTURE
355 PASADENA AVENUE
SOUTH PASADENA, CA 91030


STAMPS/SEALS

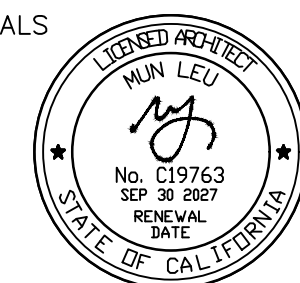

CONSULTANT

STAMPS/SEALS

KEY PLAN

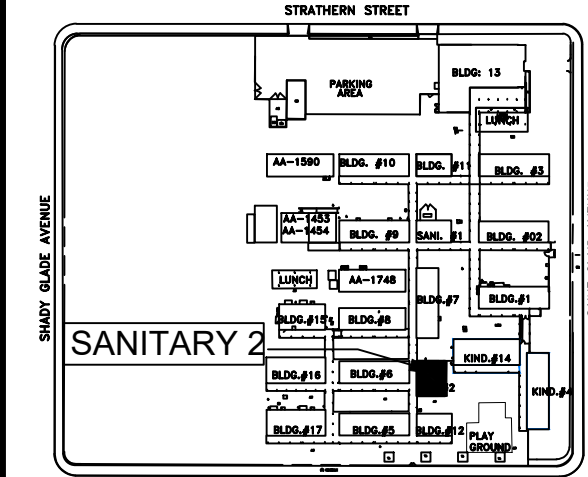

ADDEDUM 1 06/02/26

SHEET TITLE:

**SANITARY 2
FLOOR PLAN**

PROJECT NO.: 23004

PROJECT ARCH: ML ARCHITECTURE

DRAWN: T PHAN


CHECKED: MUN LEU

SHEET NUMBER

A-5.01

DATE: 10-24-2025

SHEET: OF:

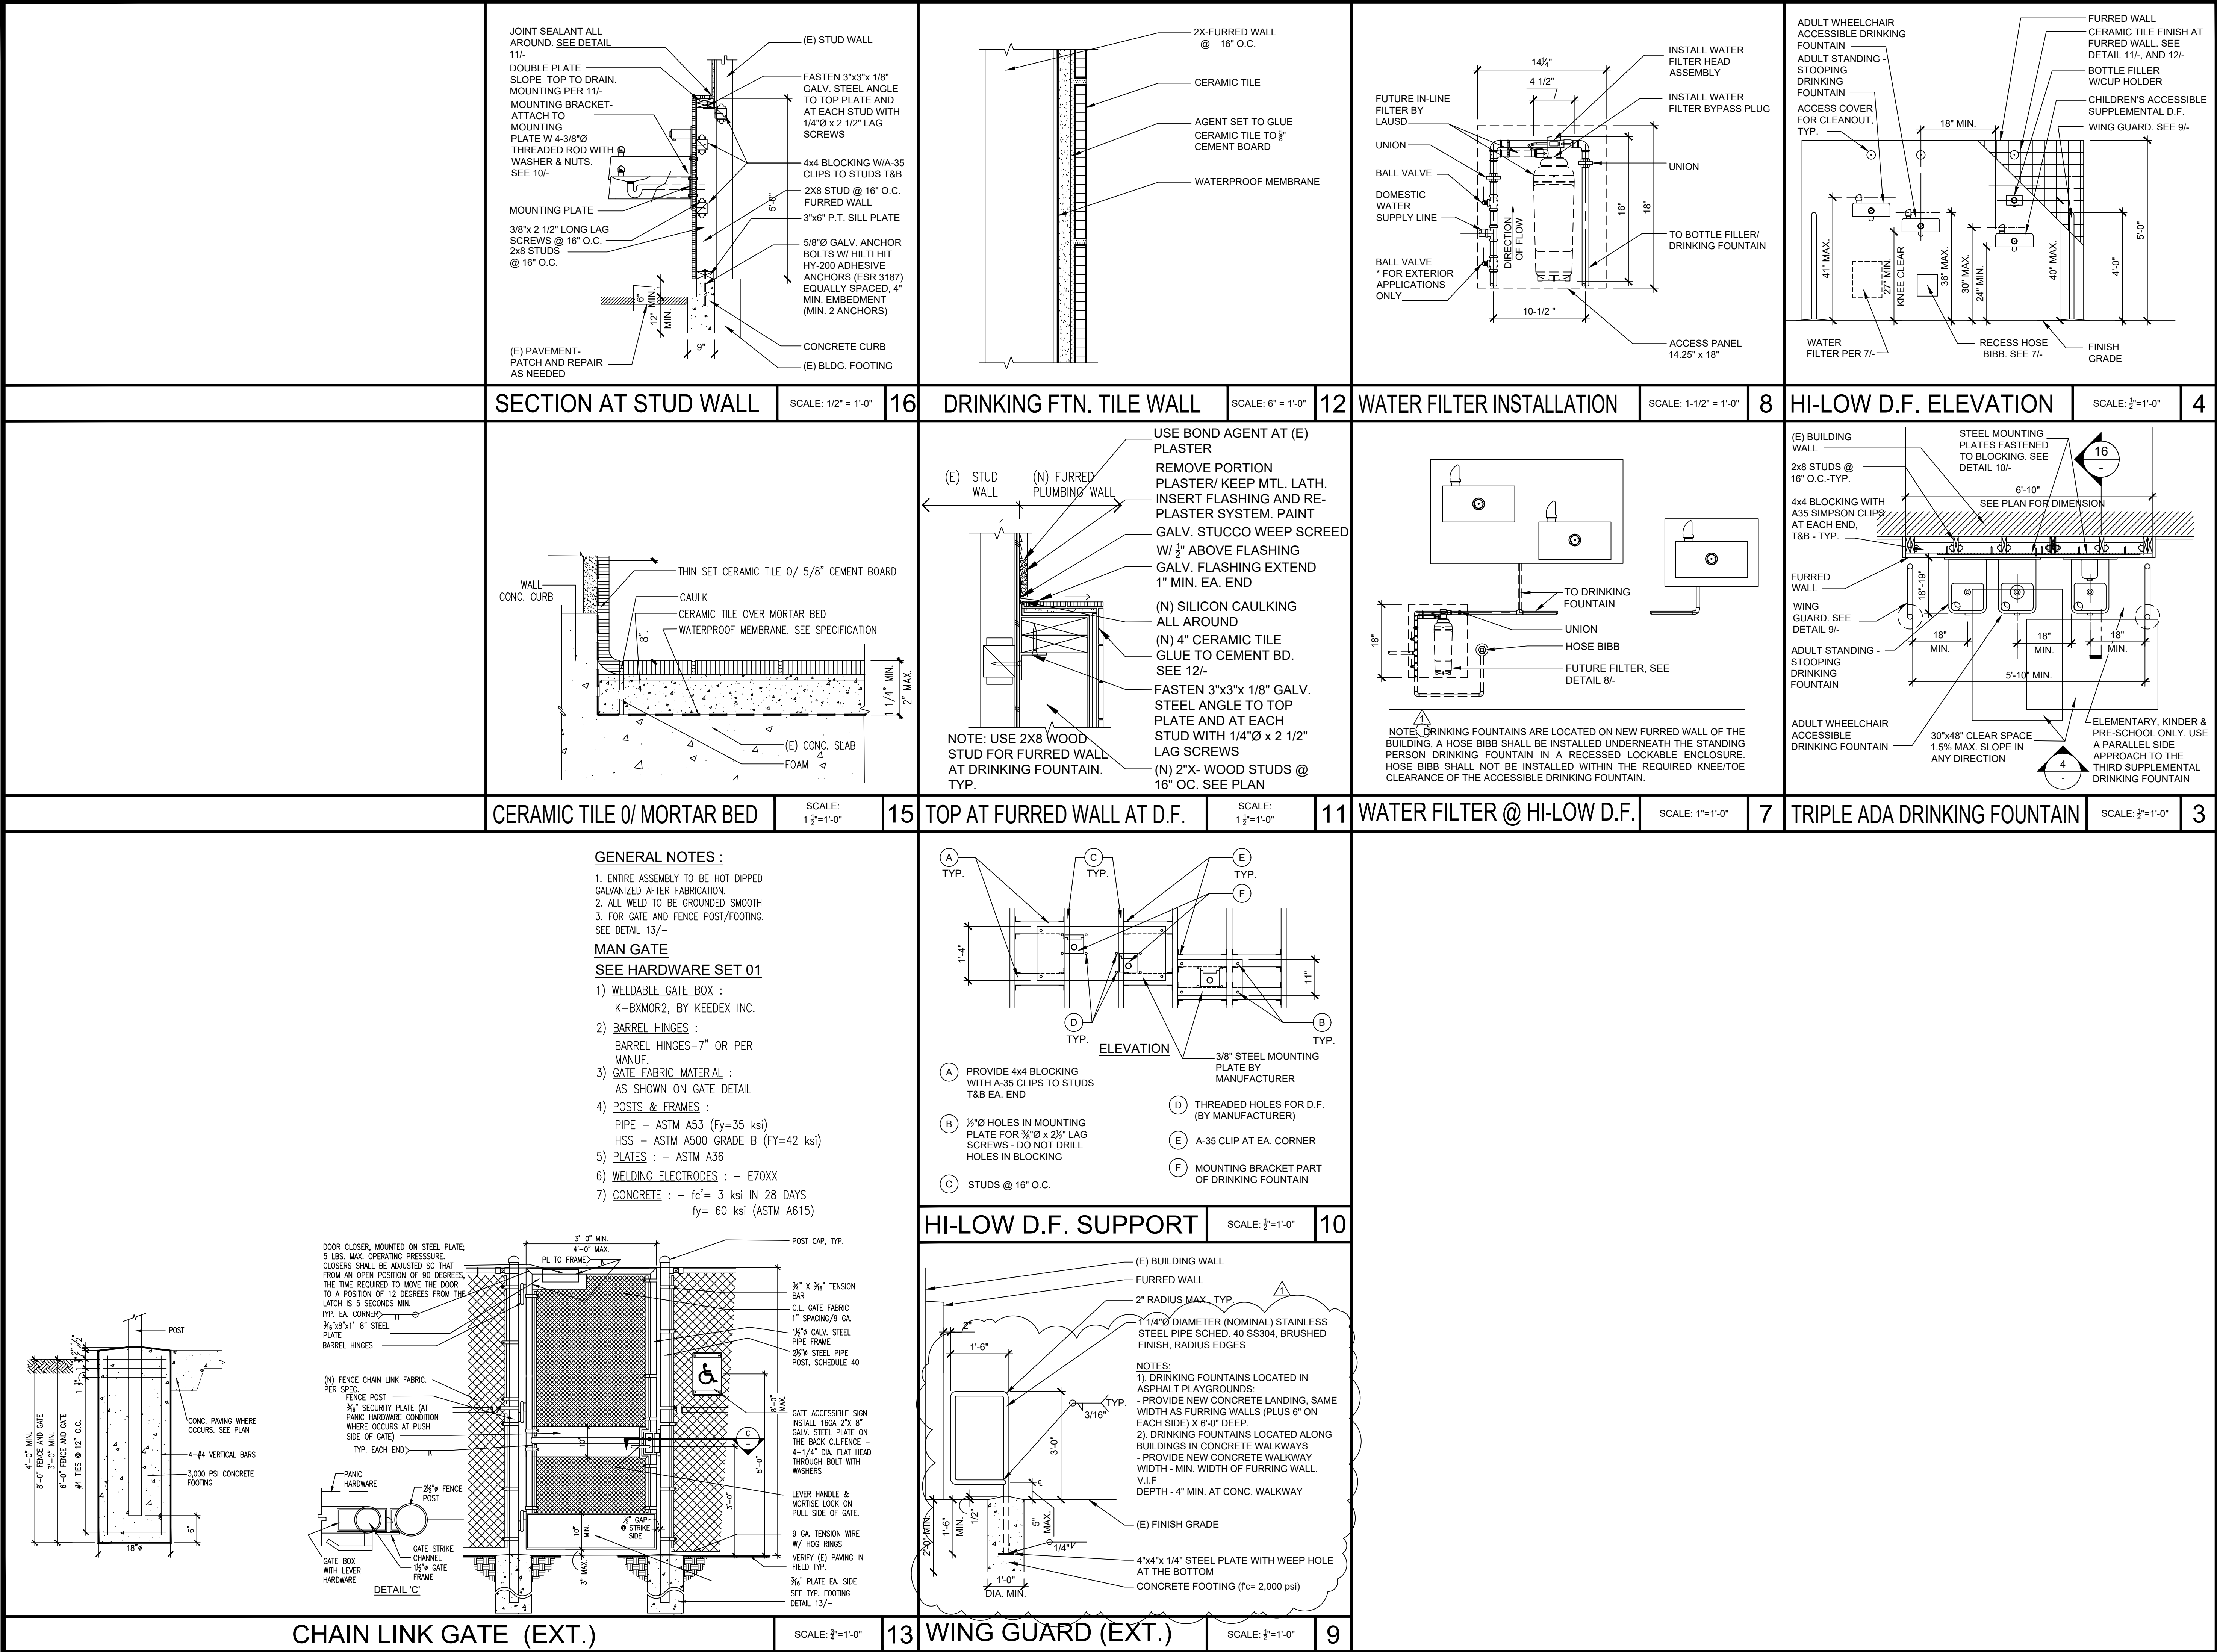

LOS ANGELES UNIFIED SCHOOL DISTRICT
ASSET MANAGEMENT
FACILITIES SERVICES DIVISION
333 S. BEAUDRY AVENUE, 23RD FLOOR
LOS ANGELES, CALIFORNIA 90017

PROJECT TITLE AND SCHOOL LOCATION
STRATHERN STREET SCHOOL
VOLUNTARY BARRIER REMOVAL
7939 ST. CLAIRE AVENUE.
N. HOLLYWOOD, CA 91605
COLIN ID No.: 10373687


DSA# 03-125645

COMMISSIONED ARCHITECT



ML ARCHITECTURE
355 PASADENA AVENUE
SOUTH PASADENA, CA 91030


STAMPS/SEALS

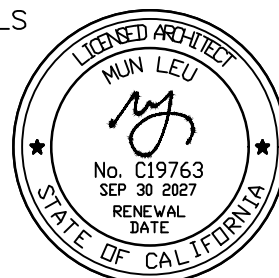

CONSULTANT

STAMPS/SEALS

KEY PLAN

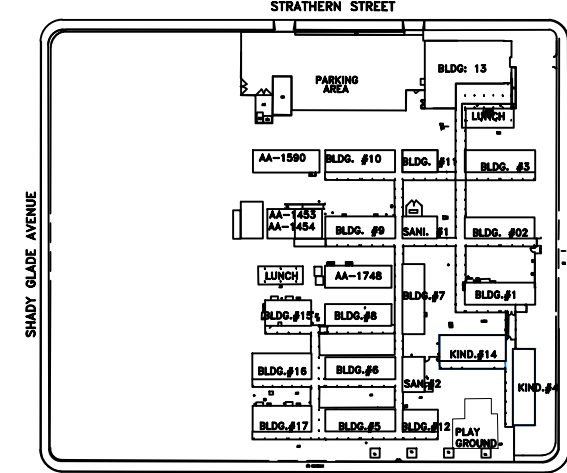

ADDEDUM 1 06/02/26

SHEET TITLE:

DRINKING FOUNTAINS
DETAILS


PROJECT NO.: 23004 PROJECT ARCH: ML ARCHITECTURE
DRAWN: T PHAN CHECKED: MUN LEU
SHEET NUMBER

ACS-5.00


DATE: 10-24-2025 SHEET: OF:

DOOR DESCRIPTION													FRAME					REMARKS
SHT. NO.	BLDG. NAME	ROOM NAME	DOOR NO.	TYPE	MATERIAL	WIDTH	HEIGHT	THICKNESS	FINISH	EXIT DEVICE	MATERIAL	JAMB (STRIKE)	HINGE	HEAD	THRESHOLD	HARDWARE SET	FINISH	
		CLASSROOM RM. 101	(101.63)	A	(E) WOOD	(E) 3'-0"	(E) 7'-0"	(E) 1 3/4"			(E)	(E)	(N)	(E)	(2 -)	EXIST-01	NON-RATED	NEW ADA THRESHOLD
		CLASSROOM BLDG. # 8	(101.60)	A	(E) WOOD	(E) 3'-0"	(E) 7'-0"	(E) 1 3/4"			(E)	(E)	(N)	(E)	(2 -)	09	NON-RATED	NEW HARDWARE (PREP. DOOR)
A-2.10		LIBRARY RM. 101	(101.61)	A	(N) WOOD	(N) 3'-0"	(N) 7'-0"	(N) 1 3/4"			(E)	(E)	(N)	(E)	(2.SIM -)	05A	PAINT	NEW DOOR HARDWARE (NEW DOOR)
		LIBRARY RM. 101	(101.62)	A	(N) WOOD	(N) 3'-0"	(N) 7'-0"	(N) 1 3/4"			(E)	(E)	(N)	(E)	(2 -)	05A	PAINT	NEW DOOR HARDWARE (NEW DOOR)
A-5.00		SANITARY 1	BOYS RESTROOM RM. SA1A	(SA1A)	A	(N) WOOD	(N) 3'-0"	(N) 7'-0"	(N) 1 3/4"		(N) HM.	(5 -)	(N)	(5 -)	(3 -)	16	PAINT	NEW DOOR HARDWARE
			GIRLS RESTROOM RM. SA1B	(SA1B)	A	(N) WOOD	(N) 3'-0"	(N) 7'-0"	(N) 1 3/4"		(N) HM.	(5 -)	(N)	(5 -)	(3 -)	16	PAINT	NEW DOOR HARDWARE
A-5.01		SANITARY 2	BOYS RESTROOM RM. SA1A	(SA2C)	A	(N) WOOD	(N) 3'-0"	(N) 7'-0"	(N) 1 3/4"		(N) HM.	(5 -)	(N)	(5 -)	(3 -)	08B	PAINT	NEW DOOR HARDWARE
			GIRLS RESTROOM RM. SA1B	(SA2D)	A	(N) WOOD	(N) 3'-0"	(N) 7'-0"	(N) 1 3/4"		(N) HM.	(5 -)	(N)	(5 -)	(3 -)	08B	PAINT	NEW DOOR HARDWARE


GENERAL NOTES:
 1. REMOVE AND CUT EXISTING DOOR TO MAX 3/4" TO 1" MAX. AT BOTTOM OPENING AND REPAINT DOOR (TYP.) AT DOOR LANDING
 2. PREP. DOOR: REMOVE (E) ALL HARDWARE AND REPAIR TO RECEIVE NEW DOOR HARDWARE INCLUDE THRESHOLD WHERE OCCURS.

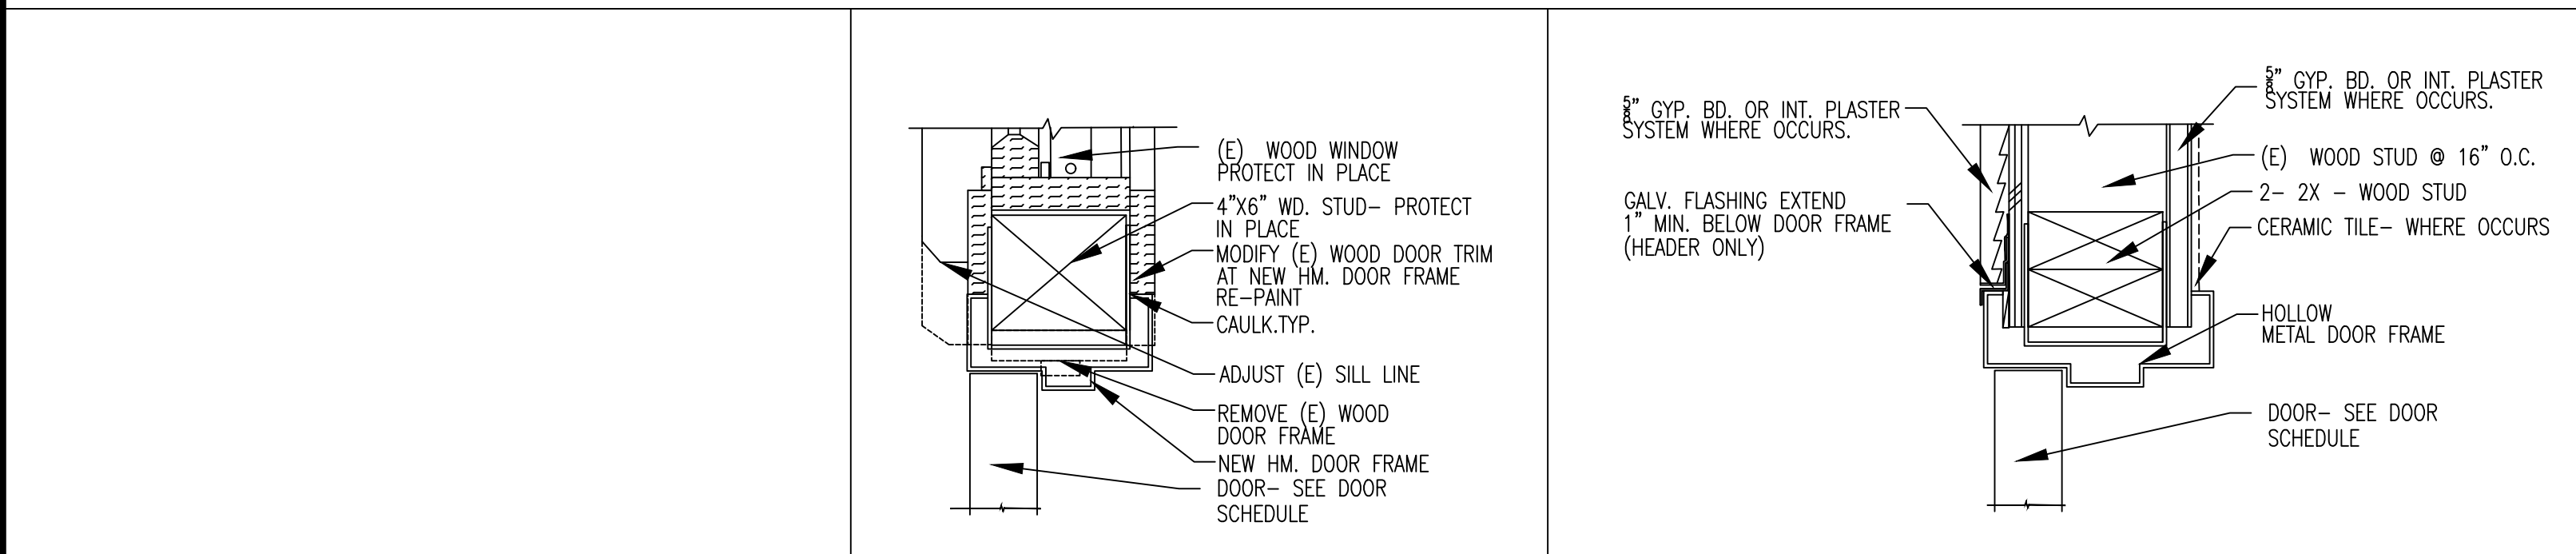

DOOR JAMB @ WINDOW (SIM. HEAD, HINGE)	SCALE: 3'-1'-0"	6	DOOR HEADER/ SIM JAMB	SCALE: 3'-1'-0"	5
---------------------------------------	-----------------	---	-----------------------	-----------------	---

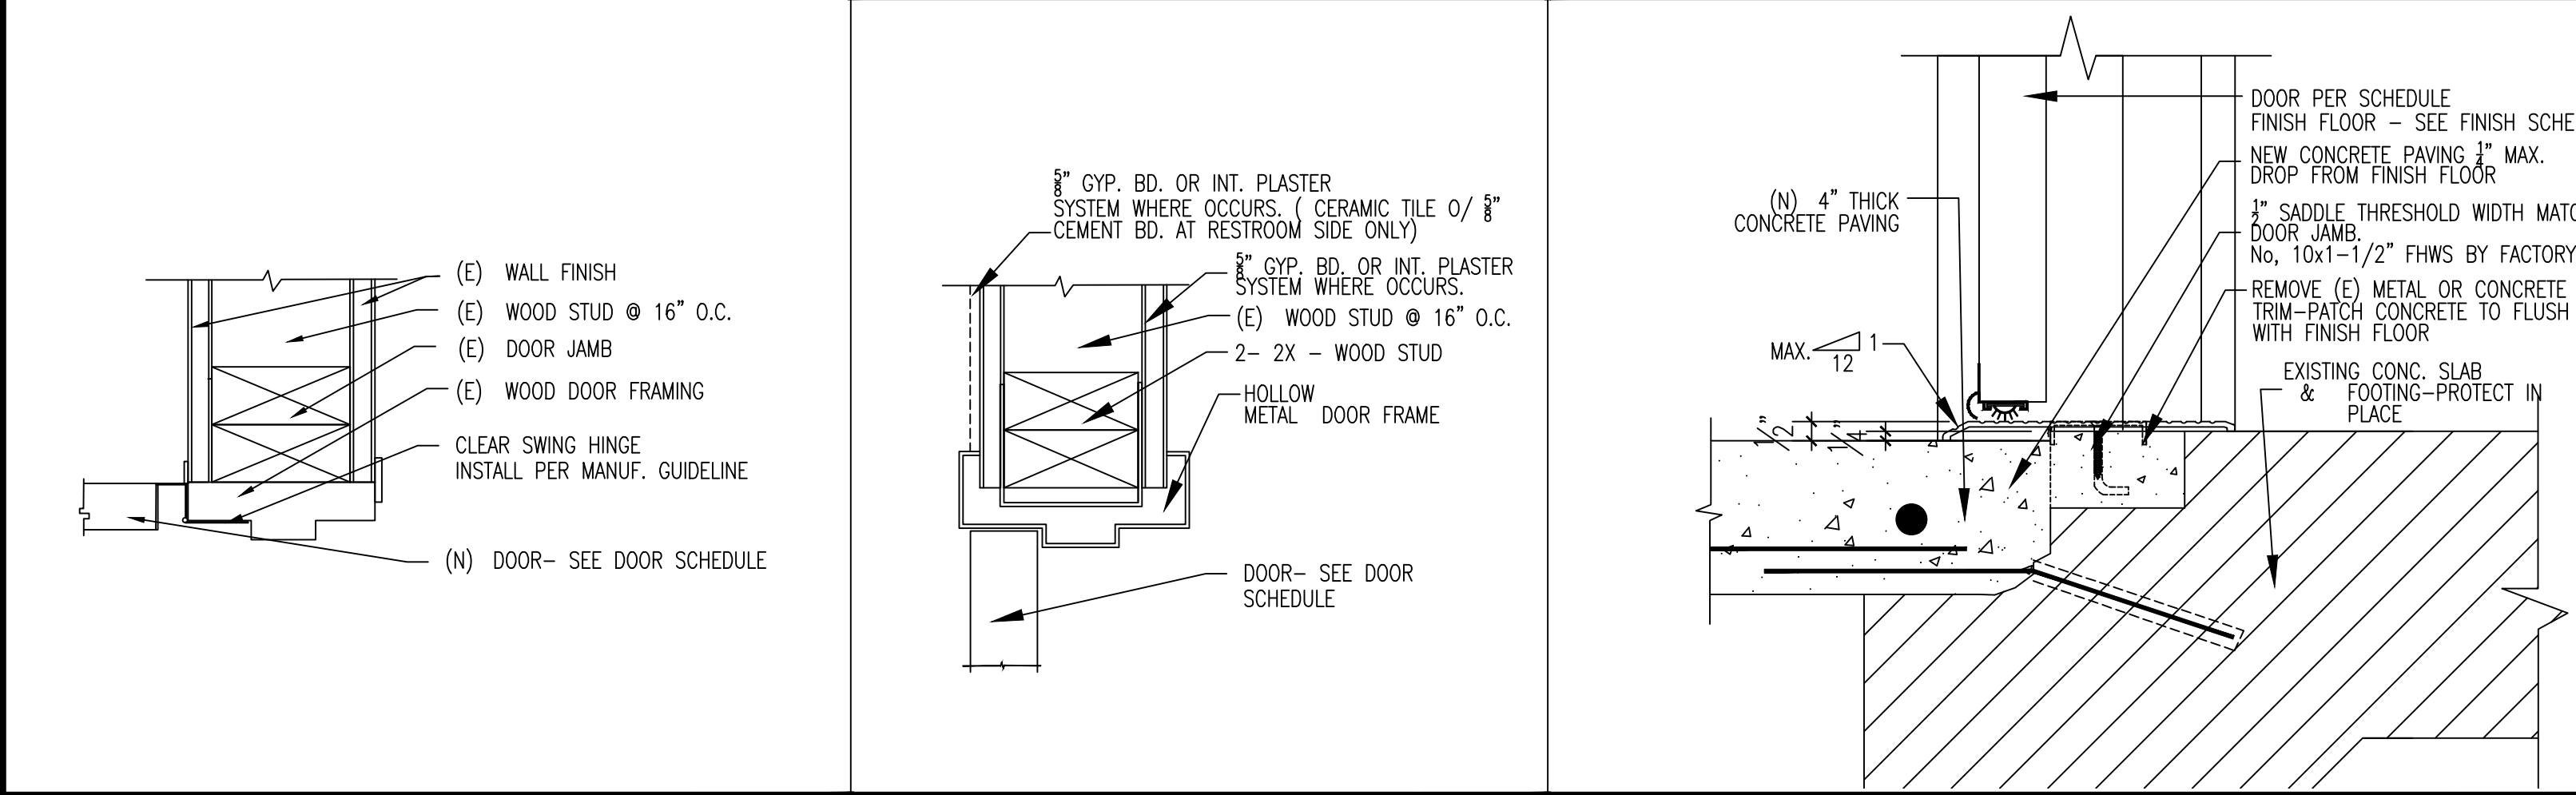


DOOR JAMB CLEAR SWING HINGE	SCALE: 3'-1'-0"	6	DOOR JAMB (SIM. HEAD, HINGE)	SCALE: 3'-1'-0"	4	THRESHOLD DETAIL	SCALE: 3'-1'-0"	2
-----------------------------	-----------------	---	------------------------------	-----------------	---	------------------	-----------------	---

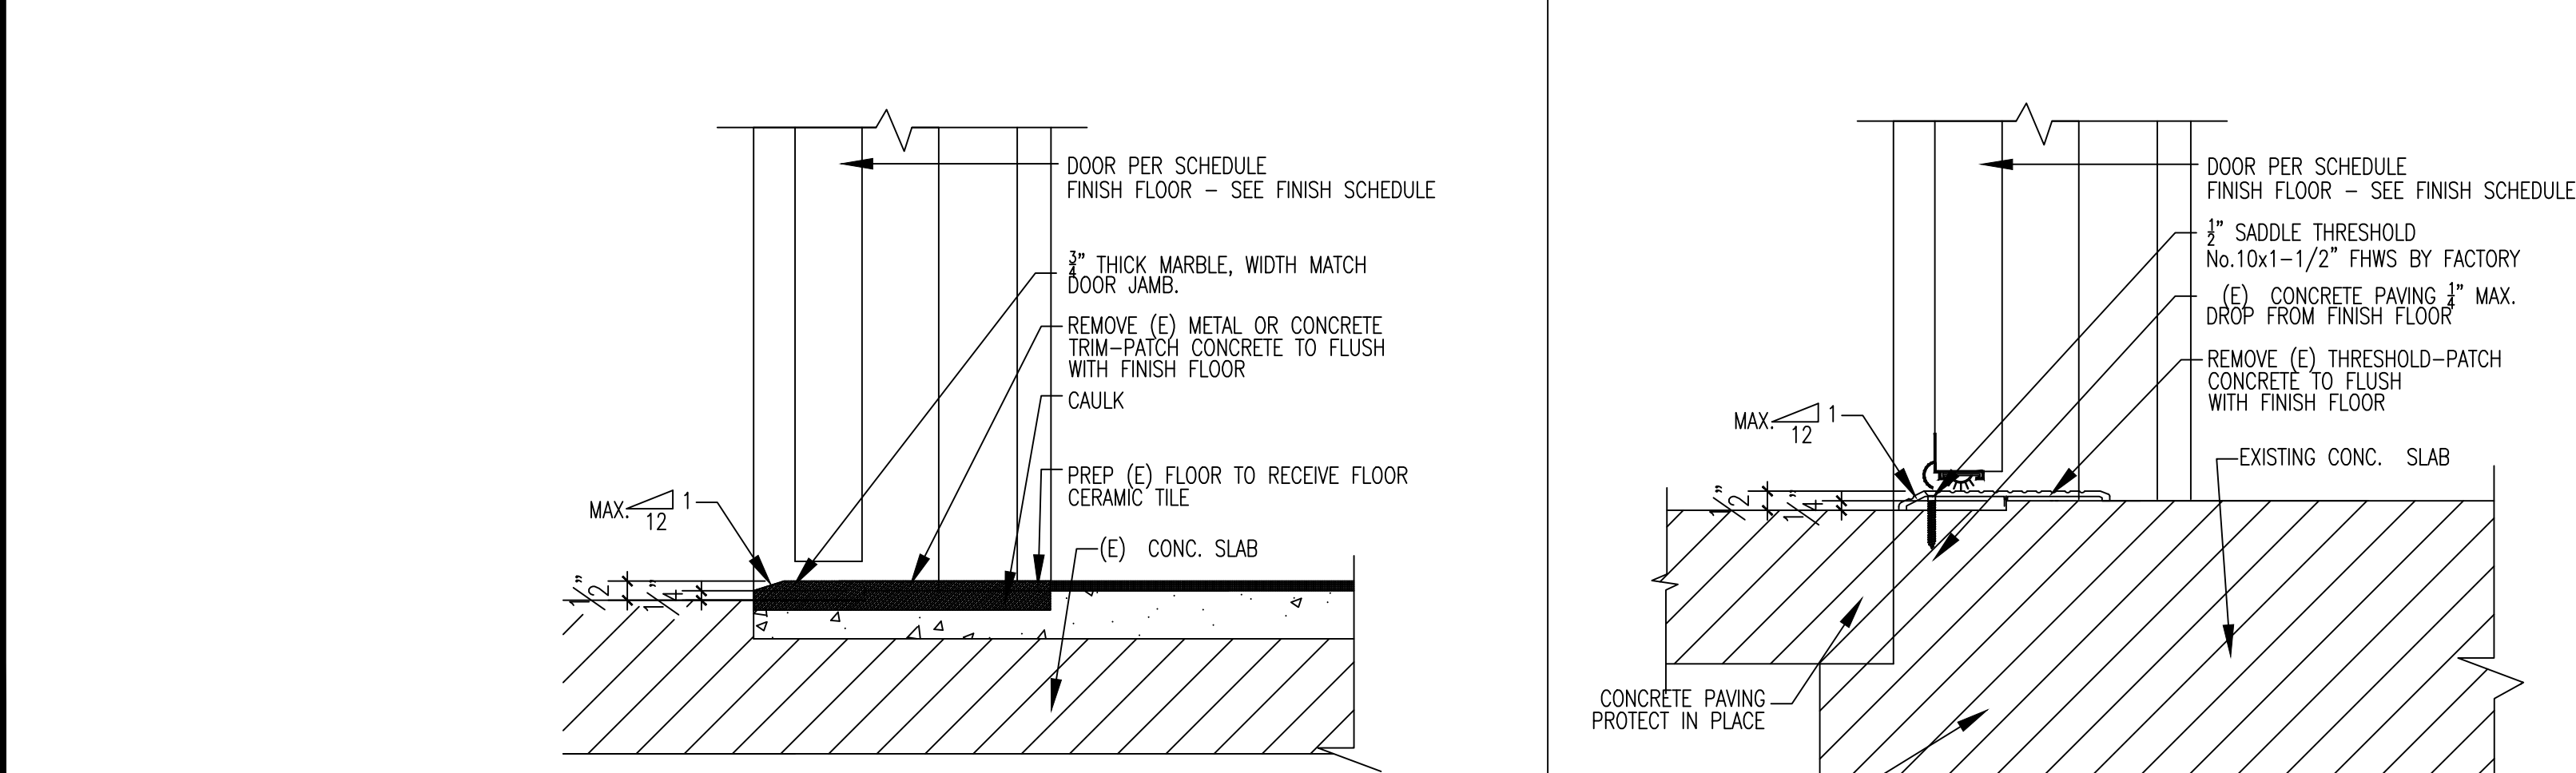

MARBLE THRESHOLD DETAIL	SCALE: 3'-1'-0"	3	THRESHOLD DETAIL	SCALE: 3'-1'-0"	1
-------------------------	-----------------	---	------------------	-----------------	---

DOOR DESCRIPTION											FRAME							FIRE RATING	PANIC HARDWARE	REMARKS
SHT. NO.	BLDG. NAME	ROOM NAME	DOOR NO.	TYPE	MATERIAL (N=NEW, E=EXISTING)	WIDTH	HEIGHT	THICKNESS	FINISH	EXIT DEVICE	MATERIAL	JAMB (STRIKE)	HINGE	HEAD	THRESHOLD	HARDWARE SET	FINISH			
A-2.00	ASSEMBLY-BLDG. #13 (1ST FLOOR)	ASSEMBLY MAIN ENTRY 100	(100A)	B	(N) WOOD	2'-3'-0"	7'-0"	1 3/4"	INT. STAIN EXT. PAINT	EXIT DEVICE	(E)	(E)	(N)	(E)	(1 -)	01	NA	NON-RATED	YES	NEW HARDWARE
		ASSEMBLY 101	(101A)	A	(N) WOOD	4'-0"	7'-0"	1 3/4"	INT. STAIN EXT. PAINT	EXIT DEVICE	(E)HM.	(E)HM.	(N)	(E)	(2 -)	02	NA		YES	NEW HARDWARE (PANIC HARDWARE (PREP. DOOR))
		ASSEMBLY 101	(101B)	B	(N) WOOD	2'-2'-0" 3'-0"	7'-0"	1 3/4" (E)	INT. STAIN EXT. PAINT	EXIT DEVICE	(E)	(E)	(N)	(E)		03	PAINT		YES	NEW HARDWARE
		KITCHEN 112	(112.1)	A	(E) WOOD	(E) 3'-0"	(E) 7'-0"	(E)	PAINT		(E)	(E)		(E)		04	PAINT			NEW HARDWARE
			(112.2)	A	(E) WOOD	3'-0"	7'-0"	(E)	PAINT		(E)	(E)		(E)		04	PAINT			NEW HARDWARE
A-2.01	OFFICE/LIBRARY BLDG. #02	LIBRARY 101	(101.6)	A	(E) WOOD	(E) 3'-0"	(E) 7'-0"	(E) 1 3/4"	(E)		(E)	(E)	(N)	(E)	(2 -)	09		NON-RATED		NEW HARDWARE
		LIBRARY 101	(101.7)	A	(E) WOOD	3'-0"	7'-0"	1 3/4"	(E)		(E)	(E)	(N)	(E)		09				NEW HARDWARE
		BREAK RM. 102	(102.8)	A	(E) WOOD	3'-0"	7'-0"	1 3/4"	(E)		(E)	(E)	(N)	(E)		09				NEW HARDWARE (SWEEP (PREP. DOOR))
		HALLWAY 103	(103.9)	A	(E) WOOD	3'-0"	7'-0"	1 3/4"	(E)		(E)	(E)	(N)	(E)		09				NEW HARDWARE (SWEEP (PREP. DOOR))
A-2.02	ADMIN / MAIN OFFICE BLDG. # 1	RECEPTION 101	(101.10)	A	(E) WOOD	3'-0"	7'-0"	1 3/4"	(E)		(E)	(E)	(N)	(E)	(2 -)	05B				NEW HARDWARE (AUTO DOOR)
		RECEPTION 101	(101.11)	A	(E) WOOD	3'-0"	7'-0"	1 3/4"	(E)		(E)	(E)	(N)	(E)		05A				NEW HARDWARE (SWEEP (PREP. DOOR))
		OFFICE 102	(102.12)	A	(E) WOOD	3'-0"	7'-0"	1 3/4"	(E)		(E)	(E)	(N)	(E)		09B				NEW HARDWARE (SWEEP (PREP. DOOR))
		WORK RM. 109	(109.13)	A	(E) WOOD	3'-0"	7'-0"	1 3/4"	(E)		(E)	(E)	(N)	(E)		09A				NEW HARDWARE (SWEEP (PREP. DOOR)) (HOLD OPEN ARM)
		WORK RM. 109	(109.14)	A	(E) WOOD	3'-0"	7'-0"	1 3/4"	(E)		(E)	(E)	(N)	(E)	(2 -)	09A				NEW HARDWARE (ADA THRESHOLD (HOLD OPEN ARM))
		SUPPLY RM. 110	(110.14)	A	(E) WOOD	3'-0"	7'-0"	1 3/4"	(E)		(E)	(E)	(N)	(E)		08				NEW HARDWARE (SWEEP (PREP. DOOR))
		ALL GENDER 111	(111.15)	A	(N) WOOD	3'-0"	7'-0"	1 3/4"	PAINT		(N) HM.	(4 -)	(N)	(4 -)	(3 -)	11				NEW HARDWARE (NO CLOSER, NEW DOOR & NEW HM DOOR FRAME)
		SUPPLY RM 108	(108A)	A	(N) WOOD	(E) 2'-9"	(E) 7'-0"	1 3/4"	PAINT		(E)	(E)	(6 -)	(E)		18	PAINT			NEW HARDWARE (NO CLEAR SWING HINGE, MODIFY WOOD DOOR FRAME)
			(108B)	A	(N) WOOD	(E) 2'-9"	(E) 7'-0"	1 3/4"	PAINT		(E)	(E)	(6 -)	(E)		19	PAINT			NEW HARDWARE (NO CLEAR SWING HINGE, MODIFY WOOD DOOR FRAME)
		OFFICE 104	(104A)	A	(N) WOOD	3'-0"	7'-0"	1 3/4"	PAINT		(N) HM.	(5 -)	(N) 5/-	(5 -)		17A	PAINT			NEW HARDWARE
		OFFICE 102	(102A)	A	(N) WOOD	3'-0"	7'-0"	1 3/4"	PAINT		(N) HM.	(5 -)	(N) 5/-	(5 -)		17	PAINT			NEW HARDWARE
A-2.03	KINDERGARTEN BLDG. # 4	STORAGE 101	(101.22)	A	(N) WOOD	(N) 3'-0"	(N) 7'-0"	(N) 1 3/4"	PAINT		(N) HM.	(4 -)	(N)	(4 -)		06				NEW HARDWARE
		STORAGE 101	(101.24)	A	(N) WOOD	(N) 3'-0"	(N) 7'-0"	(N) 1 3/4"	PAINT		(N) HM.	(4 -)	(N)	(4 -)		06	PAINT			NEW HARDWARE
		KINDERGARTEN #2 102	(102.20)	A	(E) WOOD	3'-0"	7'-0"	1 3/4"	PAINT		(E)	(E)	(N)	(E)	(2 -)	09	PAINT			NEW HARDWARE (PREP. DOOR)
			(102.21)	A	(E) WOOD	3'-0"	7'-0"	1 3/4"	PAINT		(E)	(E)	(N)	(E)		09	PAINT			NEW HARDWARE (PREP. DOOR)
		KINDERGARTEN #1 103	(103.25)	A	(E) WOOD	3'-0"	7'-0"	1 3/4"	PAINT		(E)	(E)	(N)	(E)		09	PAINT			NEW HARDWARE (PREP. DOOR)
		ALL GENDER 104	(104.23)	C	(N) WOOD	3'-0"	7'-0"	1 3/4"	PAINT		(N) HM.	(4 -)	(N)	(4 -)	(3 -)	10	PAINT			NEW HARDWARE (PREP. DOOR)
			(G2)	D	(N) C.L. GATE	(N) 4'-0"	(N) 8'-0"	(N)	GALV			(13 ACS-5.00)	(13 ACS-5.00)	(13 ACS-5.00)		GATE-01				
A-2.04	KINDERGARTEN #14 BLDG. # 14	KINDERGARTEN #01 RM. 101	(101.30)	A	(N) WOOD	(N) 3'-0"	(N) 7'-0"	(N) 1 3/4"	PAINT		(N) HM.	(6 -)	(N)	(5 -)	(2 -)	09B		NON-RATED		NEW HARDWARE (N) DOOR & HM FRAME
			(101.31)	A	(E) WOOD	(E) 3'-0"	(E) 7'-0"	1 3/4"	PAINT		(E)	(E)	(N)	(E)		09				NEW HARDWARE (PREP. DOOR)
		KINDERGARTEN #02 RM. 102	(102.33)	A	(E) WOOD	3'-0"	7'-0"	1 3/4"	PAINT		(E)	(E)	(N)	(E)		09				NEW HARDWARE (PREP. DOOR)
			(102.32)	A	(N) WOOD	(N) 3'-0"	(N) 7'-0"	(N) 1 3/4"	PAINT		(N) HM.	(6 -)	(N)	(5 -)		09B				NEW HARDWARE (N) DOOR & HM FRAME
		STORAGE 103	(103.34)	A	(E) WOOD	3'-0"	7'-0"	1 3/4"	PAINT		(E)	(E)	(N)	(E)	(2 -)	08A				NEW HARDWARE (PREP. DOOR)
		ALL GENDER 104	(104.35)	C	(N) WOOD	(N) 3'-0"	(N) 7'-0"	(N) 1 3/4"	PAINT		(N) HM.	(4 -)	(N)	(4 -)	(3 -)	12	PAINT			NEW HARDWARE (MARBLE THRESHOLD NO CLOSER)
			(104.36)	C	(N) WOOD	3'-0"	7'-0"	1 3/4"	PAINT		(N) HM.	(4 -)	(N)	(4 -)	(3 -)	12	PAINT			NEW HARDWARE (MARBLE THRESHOLD NO CLOSER)
			(G1)	D	(N) CL GATE	(N) 3'-6"	(N) 7'-0"	(N)	GALV			(13 ACS-5.00)	(13 ACS-5.00)	(13 ACS-5.00)		GATE-01				CHAIN LINK GATE: HARDWARE SEE 19 ACS-5.00
A-2.05	CLASSROOM BLDG. # 12	CLASSROOM 12 RM. 001	(05.42)	A	(E) WOOD	3'-0"	7'-0"	1 3/4"	PAINT		(E)	(E)	(N)	(E)	(2 -)	09		NON-RATED		NEW HARDWARE (PREP. DOOR)
	CLASSROOM BLDG. # 05	CLASSROOM 101 RM. 101	(101.41)	A	(E) WOOD	3'-0"	7'-0"	1 3/4"	PAINT		(E)	(E)	(N)	(E)	(2 -)	09		NON-RATED		NEW HARDWARE (PREP. DOOR)
A-2.06	CLASSROOM BLDG. # 16	CLASSROOM 012 RM. 012	(012.47)	A	(E) WOOD	(E) 3'-0"	(E) 7'-0"	1 3/4"	PAINT		(E)	(E)	(N)	(E)	(2 -)	09		NON-RATED		NEW HARDWARE (PREP. DOOR)
		CLASSROOM 013 RM. 013	(013.46)	A	(E) WOOD	(E) 3'-0"	7'-0"	1 3/4"	PAINT		(E)	(E)	(N)	(E)	(2 -)	09		NON-RATED		NEW HARDWARE (PREP. DOOR)
A-2.07	CLASSROOM BLDG. # 15	PSYCH 001 RM. 001	(001.50)	A	(N) WOOD	(N) 3'-0"	(N) 7'-0"	(N) 1 3/4"	PAINT		HM.	(5 -)	(N)	(5 -)	(2 -)	07	PAINT	NON-RATED		NEW HARDWARE
			(001.51)	A	(E) WOOD	(E) 3'-0"	(E) 7'-0"	1 3/4"	PAINT		(E)	(E)	(N)	(E)	(1.SIM -)	07				NEW HARDWARE (PREP. DOOR)
		CLASSROOM RM. 014	(014.53)	A	(E) WOOD	(E) 3'-0"	7'-0"	1 3/4"	PAINT		(E)	(E)	(N)	(E)	(2 -)	09A	PAINT			NEW HARDWARE (PREP. DOOR)

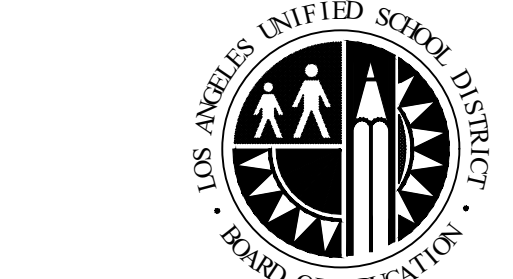

LOS ANGELES UNIFIED SCHOOL DISTRICT
ASSET MANAGEMENT
FACILITIES SERVICES DIVISION
 333 S. BEAUDRY AVENUE, 23RD FLOOR
 LOS ANGELES, CALIFORNIA 90017


PROJECT TITLE AND SCHOOL LOCATION
STRATHERN STREET SCHOOL
VOLUNTARY BARRIER REMOVAL
 7939 ST. CLAIRE AVENUE.
 N. HOLLYWOOD, CA 91605
 COLIN ID No.: 10373687

DSA# 03-125645
 COMMISSIONED ARCHITECT
MLA
 ML ARCHITECTURE
 355 PASADENA AVENUE
 SOUTH PASADENA, CA91030



CONSULTANT

STAMPS/SEALS

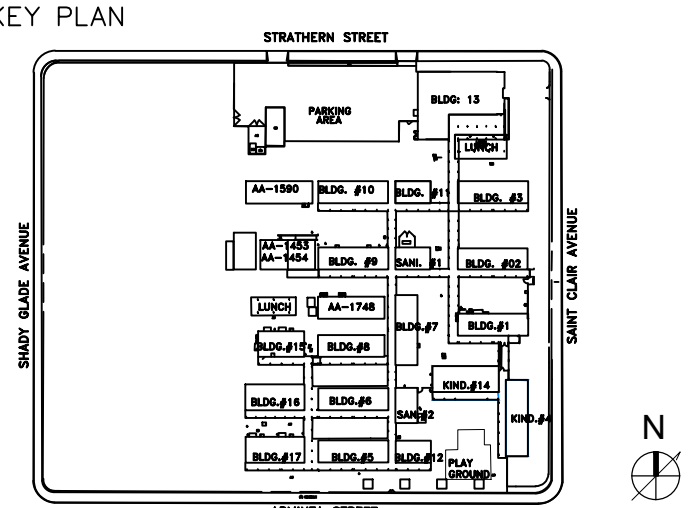

ADDEDUM 1 06/02/26


SHEET TITLE:

DOOR SCHEDULE AND DETAILS

PROJECT NO.: 23004 PROJECT ARCH: ML ARCHITECTURE
 DRAWN: T PHAN CHECKED: MUN LEU
 SHEET NUMBER

ACS-8.00

DATE: 10-24-2025 SHEET: OF:

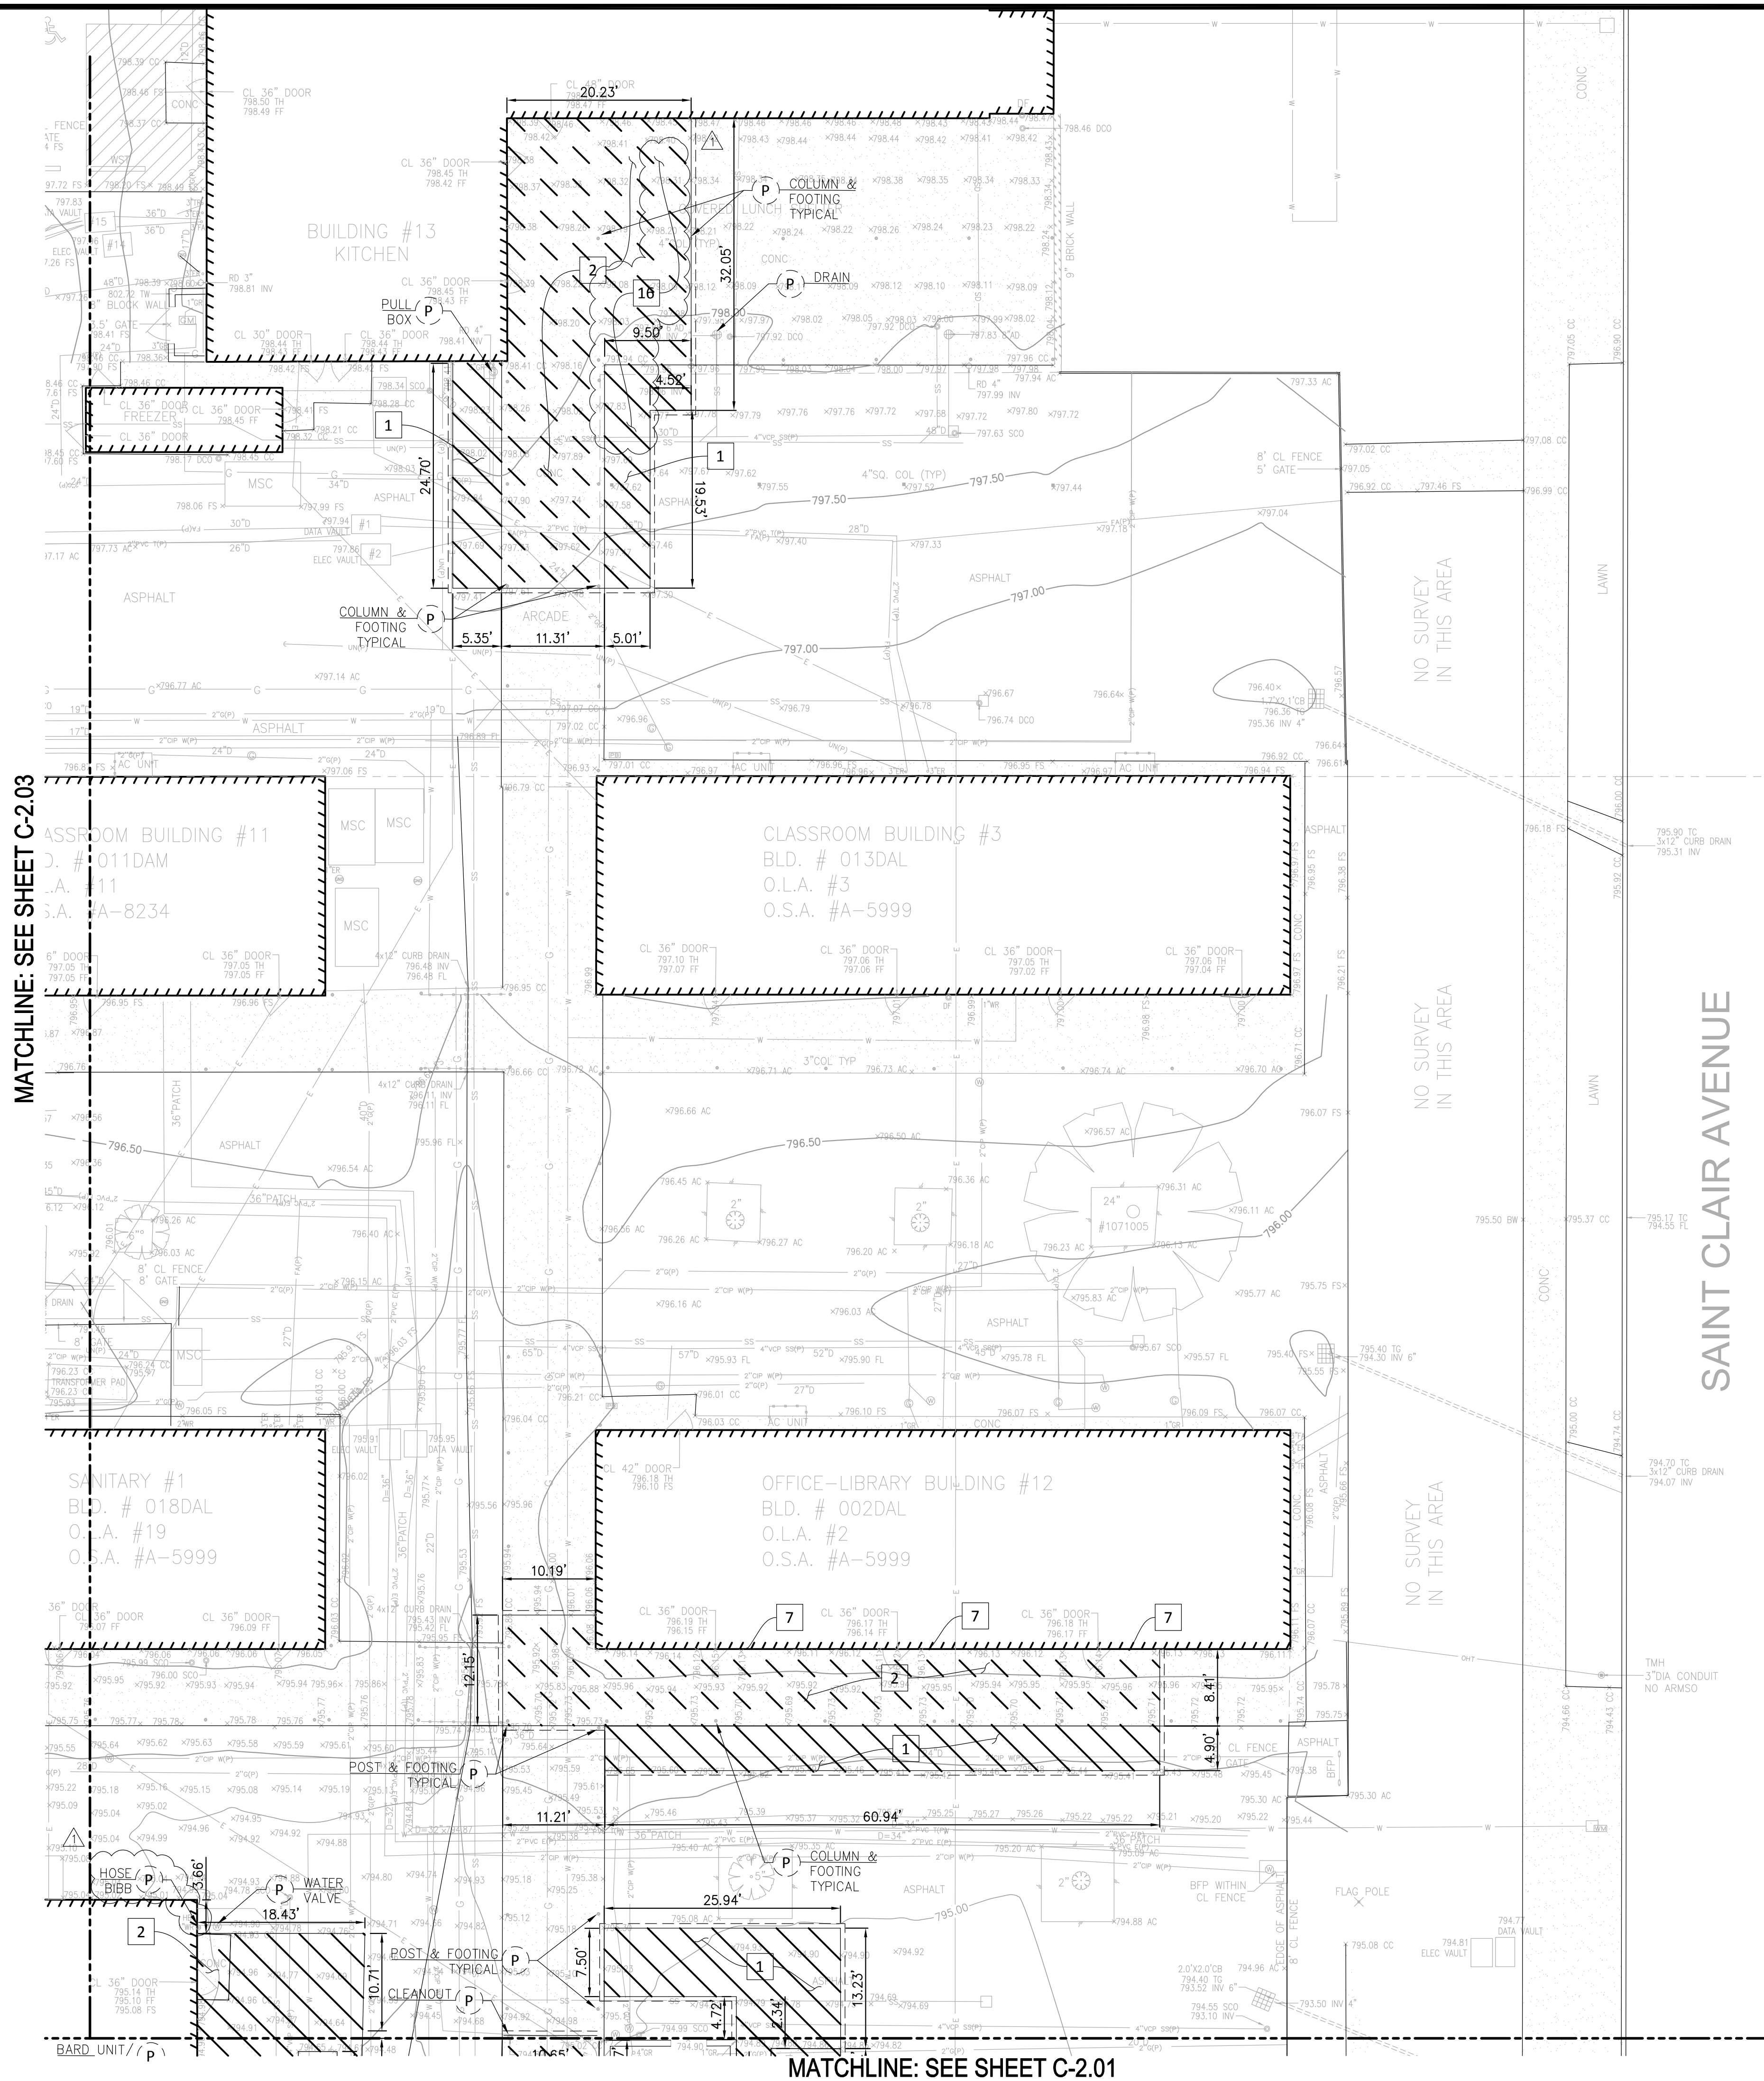

- DEMOLITION NOTES:
- 1 2" THICK ASPHALT CONCRETE PAVEMENT, 3" BASE
 - 2 4" THICK CONCRETE PAVEMENT, 4" BASE
 - 7 DOOR STOP
 - 16 TEMPORARILY RELOCATE LUNCH TABLES, AS NEEDED, FOR REMOVAL AND REPLACEMENT OF PAVEMENT
 - P PROTECT IN PLACE

- DEMOLITION GENERAL NOTES:
- 1. PROTECT EXISTING UTILITY LINES IN PLACE UNLESS OTHERWISE NOTED.
 - 2. THE CONTRACTOR SHALL TAKE NECESSARY MEASURES TO PROTECT THE INTEGRITY OF THE ADJACENT STRUCTURES AND ANY IMPROVEMENTS OF ADJACENT PROPERTIES DURING DEMOLITION AND CONSTRUCTION.
 - 3. THE CONTRACTOR SHALL REPAIR AND RESTORE ANY STRUCTURES OR ADJOINING WALLS THAT ARE DAMAGED DURING CONSTRUCTION.
 - 4. WHERE NEW PAVEMENT OR CURB IS TO BE CONSTRUCTED UNDER A FENCE, UNTIE AND REMOVE FENCE FABRIC TO PERMIT CONSTRUCTION. AFTER CONSTRUCTION, ADD OR CUT AND KNUCKLE FABRIC TO FIT NEW SURFACE AND RE-INSTALL.
 - 5. IN ADDITION TO SCANNING AND LOCATING UNDERGROUND OR IN-WALL UTILITIES, CONTRACTOR TO CAREFULLY HAND CHIP AT EXISTING UTILITY LINES AND RISERS IN DEMOLITION FOOTPRINTS.

- LEGEND:
- REMOVE EXISTING CONCRETE PAVEMENT 2
 - REMOVE EXISTING ASPHALT CONCRETE PAVEMENT 1
 - SAWCUT & JOIN LINE
 - # REMOVE (UNLESS OTHERWISE NOTED)

LOS ANGELES UNIFIED SCHOOL DISTRICT
BOARD OF EDUCATION

**LOS ANGELES UNIFIED SCHOOL DISTRICT
ASSET MANAGEMENT
FACILITIES SERVICES DIVISION**

333 S. BEAUDRY AVENUE, 23RD FLOOR
LOS ANGELES, CALIFORNIA 90017

PROJECT TITLE AND SCHOOL LOCATION
**STRATHERN STREET
SCHOOL
VOLUNTARY BARRIER
REMOVAL**

7939 ST. CLAIRE AVENUE
N. HOLLYWOOD, CA 91605
COLIN ID NO.: 10373687

DSA# 03-125645

COMMISSIONED ARCHITECT

MLA
ML ARCHITECTURE
355 PASADENA AVENUE
SOUTH PASADENA, CA 91030

STAMPS/SEALS


LEO ARCHITECT
MLA LEU
No. C19763
SEP 30 2021
RENEWAL
DATE
STATE OF CALIFORNIA

CONSULTANT

MOLLENHAUER GROUP
CIVIL ENGINEERING
SURVEYING+MAPPING
LAND DEVELOPMENT
213 624 2661 TEL
919 W. GLENDALE BLVD.,
2ND FLOOR
GLENDALE, CALIFORNIA
91202

STAMPS/SEALS

REGISTERED PROFESSIONAL ENGINEER
No. 82464
CIVIL
STATE OF CALIFORNIA

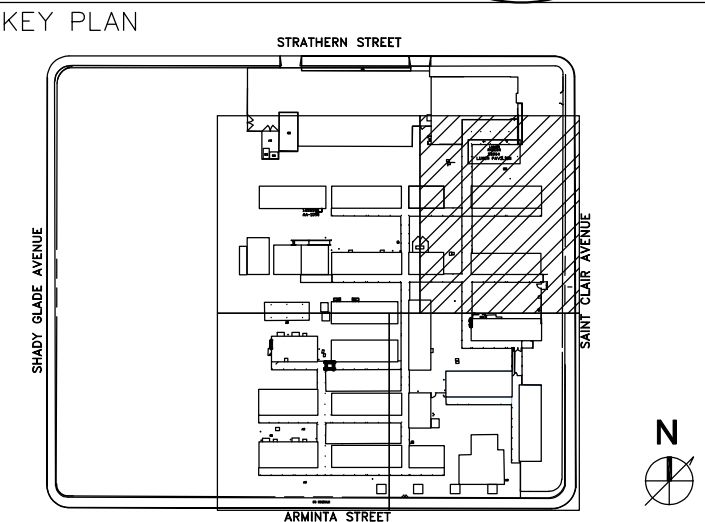

ADDENDUM 1 06/02/26


SHEET TITLE:

**DEMOLITION PLAN
NORTHEAST**

PROJECT NO.: 23004 PROJECT ARCH: ML ARCHITECTURE
DRAWN: MK CHECKED: TT
SHEET NUMBER

C-2.02

DATE: 10-24-2025 SHEET: OF:

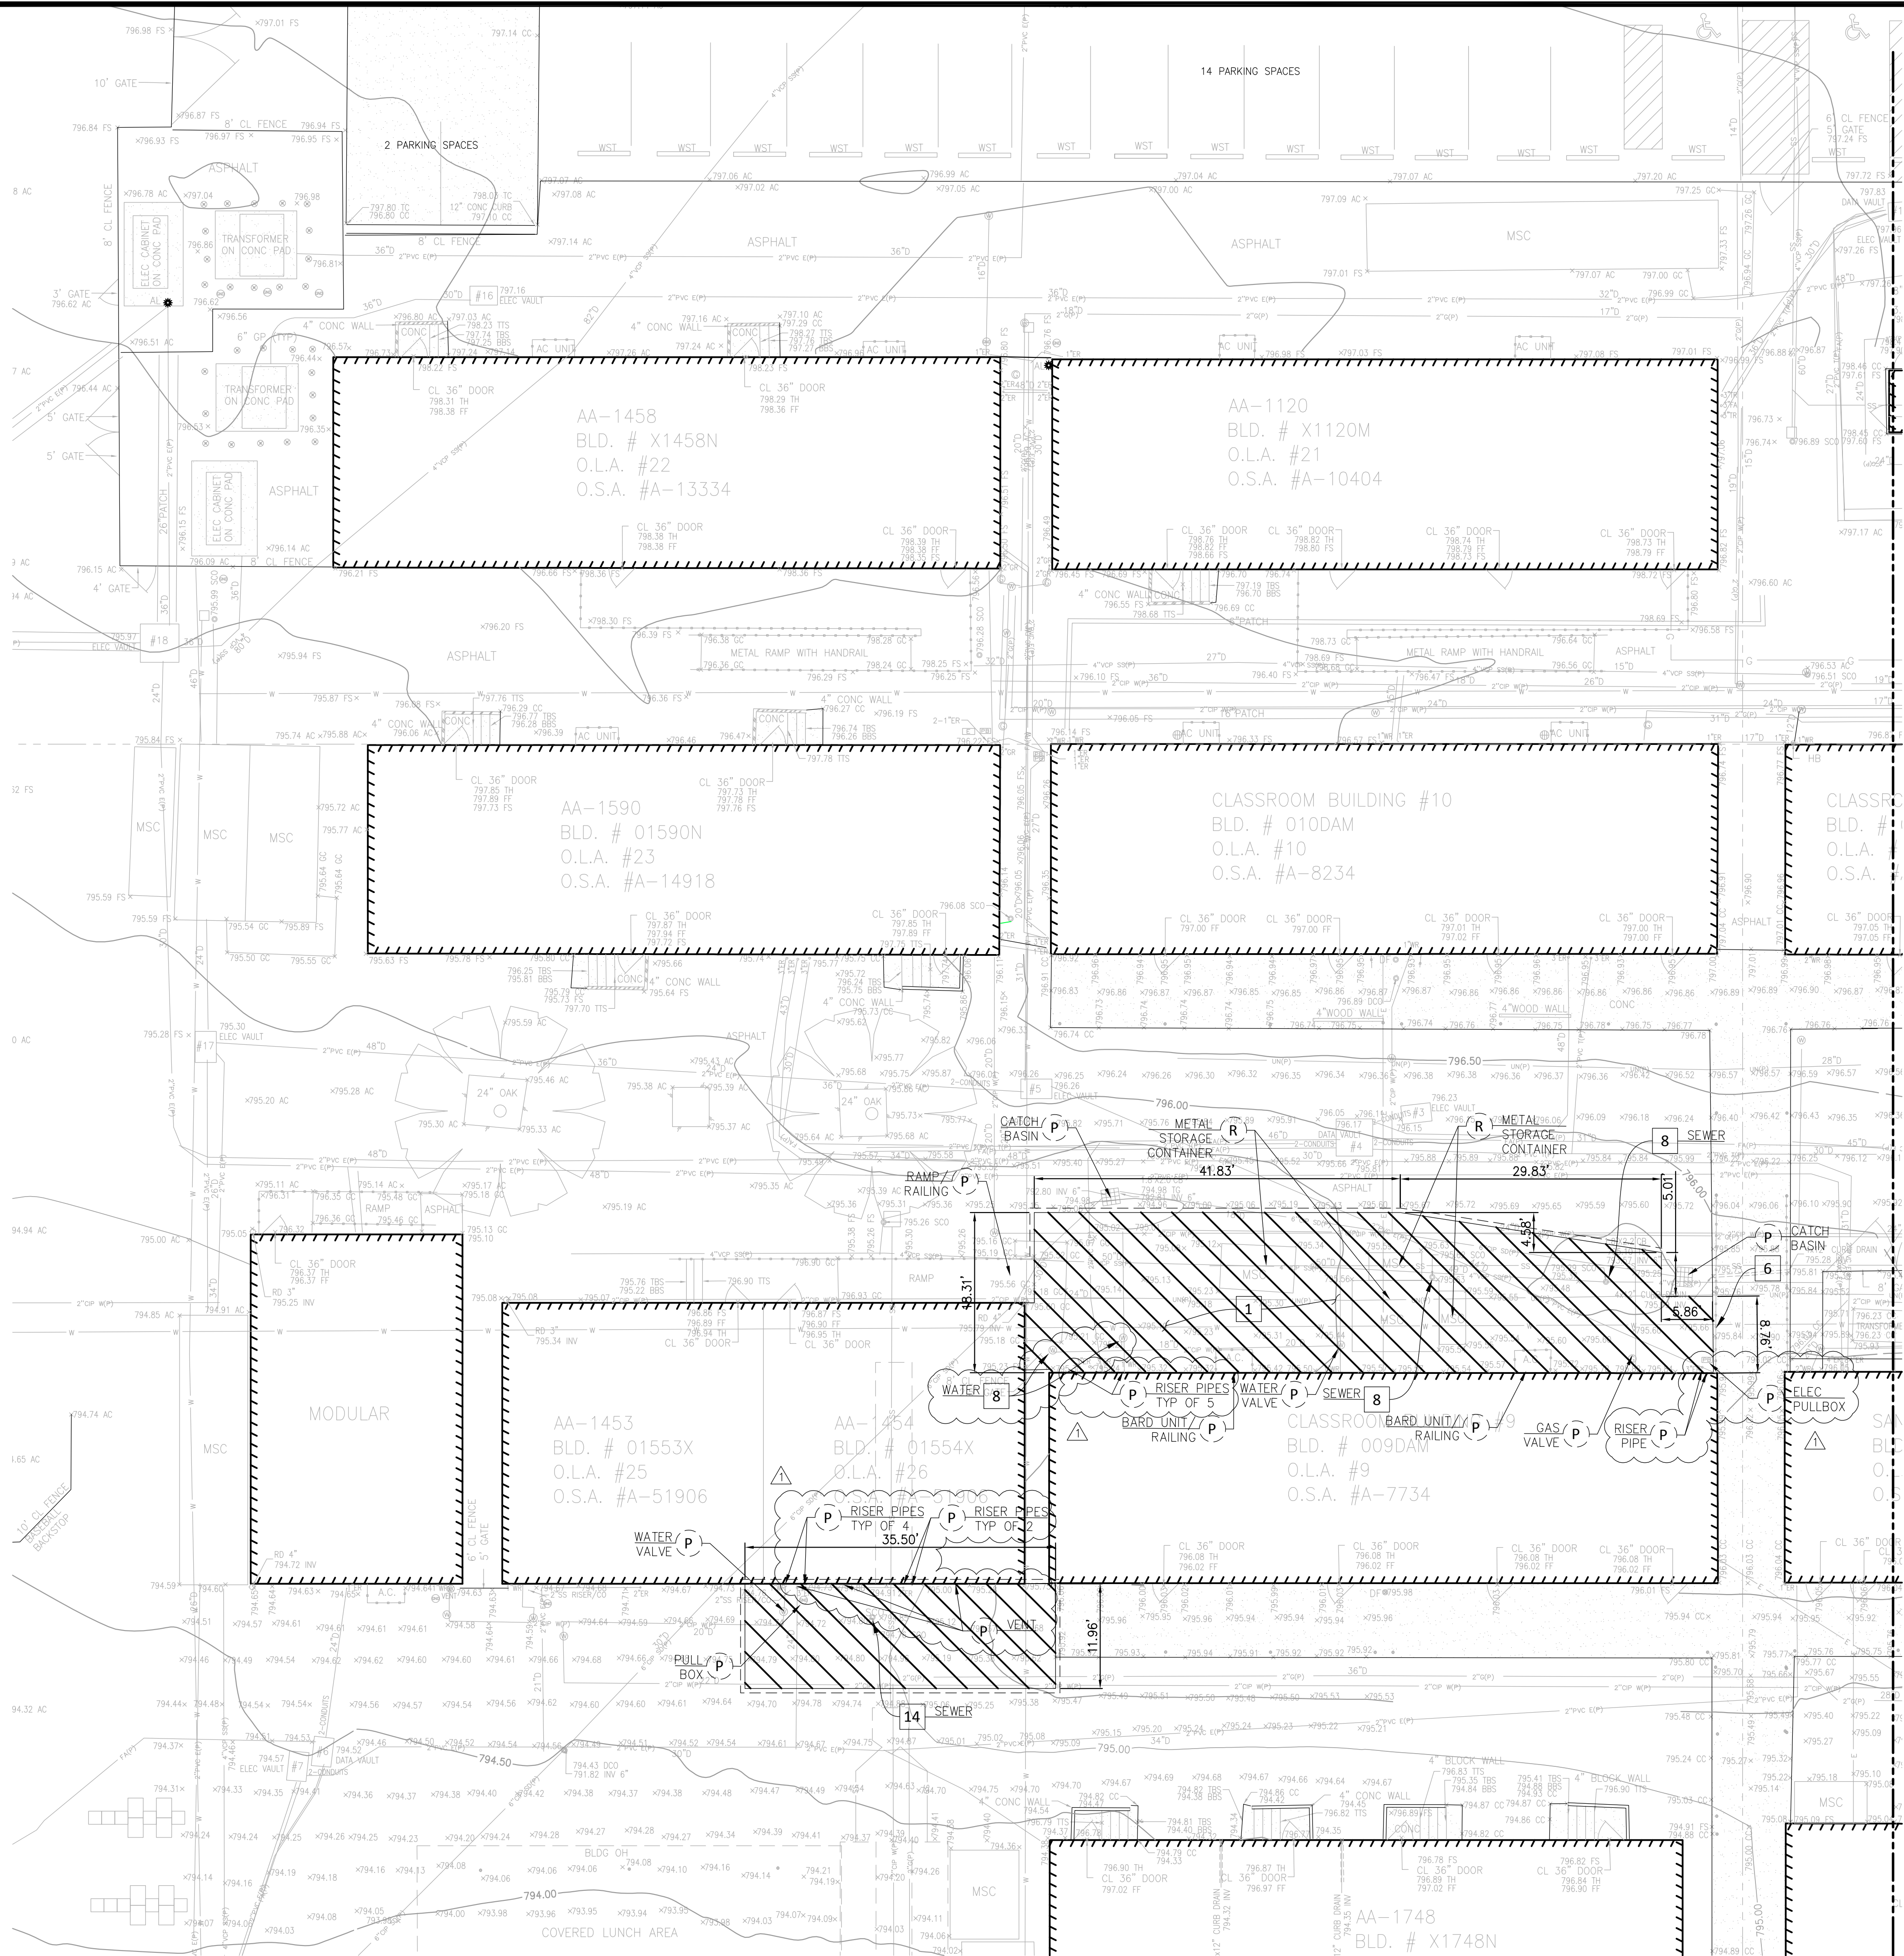

DEMOLITION NOTES:


- 1 2" THICK ASPHALT CONCRETE PAVEMENT, 3" BASE
- 6 HANDRAIL
- 8 YARD BOX
- 14 CLEANOUT
- P PROTECT IN PLACE
- R RELOCATE EXISTING ITEM, SEE ARCHITECTURAL SITE PLAN A-1.01 FOR LOCATION.

DEMOLITION GENERAL NOTES:

1. PROTECT EXISTING UTILITY LINES IN PLACE UNLESS OTHERWISE NOTED.
2. THE CONTRACTOR SHALL TAKE NECESSARY MEASURES TO PROTECT THE INTEGRITY OF THE ADJACENT STRUCTURES AND ANY IMPROVEMENTS OF ADJACENT PROPERTIES DURING DEMOLITION AND CONSTRUCTION.
3. THE CONTRACTOR SHALL REPAIR AND RESTORE ANY STRUCTURES OR ADJOINING WALLS THAT ARE DAMAGED DURING CONSTRUCTION.
4. WHERE NEW PAVEMENT OR CURB IS TO BE CONSTRUCTED UNDER A FENCE, UNTIE AND REMOVE FENCE FABRIC TO PERMIT CONSTRUCTION. AFTER CONSTRUCTION, ADD OR CUT AND KNUCKLE FABRIC TO FIT NEW SURFACE AND RE-INSTALL.
5. IN ADDITION TO SCANNING AND LOCATING UNDERGROUND OR IN-WALL UTILITIES, CONTRACTOR TO CAREFULLY HAND CHIP AT EXISTING UTILITY LINES AND RISERS IN DEMOLITION FOOTPRINTS.
6. WHERE NEW PAVEMENT ABUTS AGAINST AN EXISTING MODULAR BUILDING, PRESSURE TREATED WOOD BLOCKS/EDGING SHALL BE ADDED ALONG THE BUILDING SKIRT TO ACT AS TRIM FOR PLACEMENT OF PAVEMENT.

LEGEND:

- REMOVE EXISTING CONCRETE PAVEMENT 2
- REMOVE EXISTING ASPHALT CONCRETE PAVEMENT 1
- SAWCUT & JOIN LINE
- # REMOVE (UNLESS OTHERWISE NOTED)

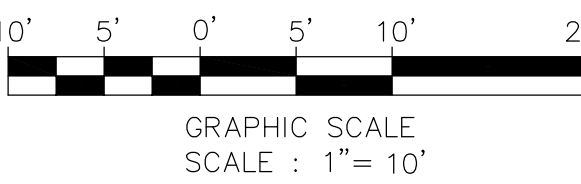

LOS ANGELES UNIFIED SCHOOL DISTRICT
ASSET MANAGEMENT
FACILITIES SERVICES DIVISION
333 S. BEAUDRY AVENUE, 23RD FLOOR
LOS ANGELES, CALIFORNIA 90017

PROJECT TITLE AND SCHOOL LOCATION

STRATHERN STREET
SCHOOL
VOLUNTARY BARRIER
REMOVAL
7939 ST. CLAIRE AVENUE
N. HOLLYWOOD, CA 91605
COLIN ID No.: 10373687

DSA# 03-125645

COMMISSIONED ARCHITECT



MLA ARCHITECTURE
355 PASADENA AVENUE
SOUTH PASADENA, CA91030

STAMPS/SEALS



CONSULTANT




CIVIL ENGINEERING
SURVEYING+MAPPING
LAND DEVELOPMENT
213 624 2661 TEL
919 W. GLENDALE BLVD.,
2ND FLOOR
GLENDALE, CALIFORNIA
91202

STAMPS/SEALS



KEY PLAN

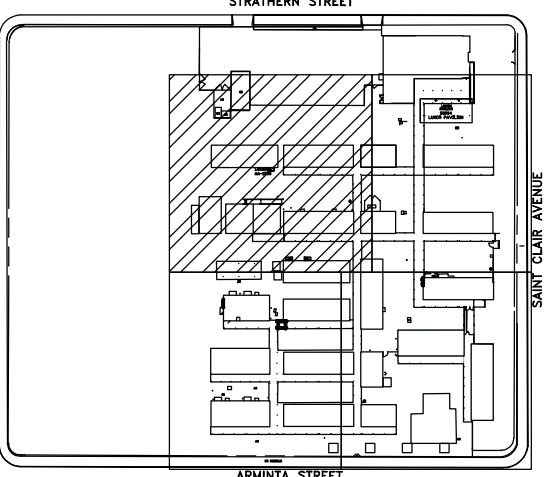

ADDENDUM 1 06/02/26

SHEET TITLE:

DEMOLITION PLAN
NORTH

PROJECT NO.: 23004

PROJECT ARCH: ML ARCHITECTURE

DRAWN: MK

CHECKED: TT


SHEET NUMBER

C-2.03

DATE: 10-24-2025

SHEET: OF:

MATCHLINE: SEE SHEET C-2.03

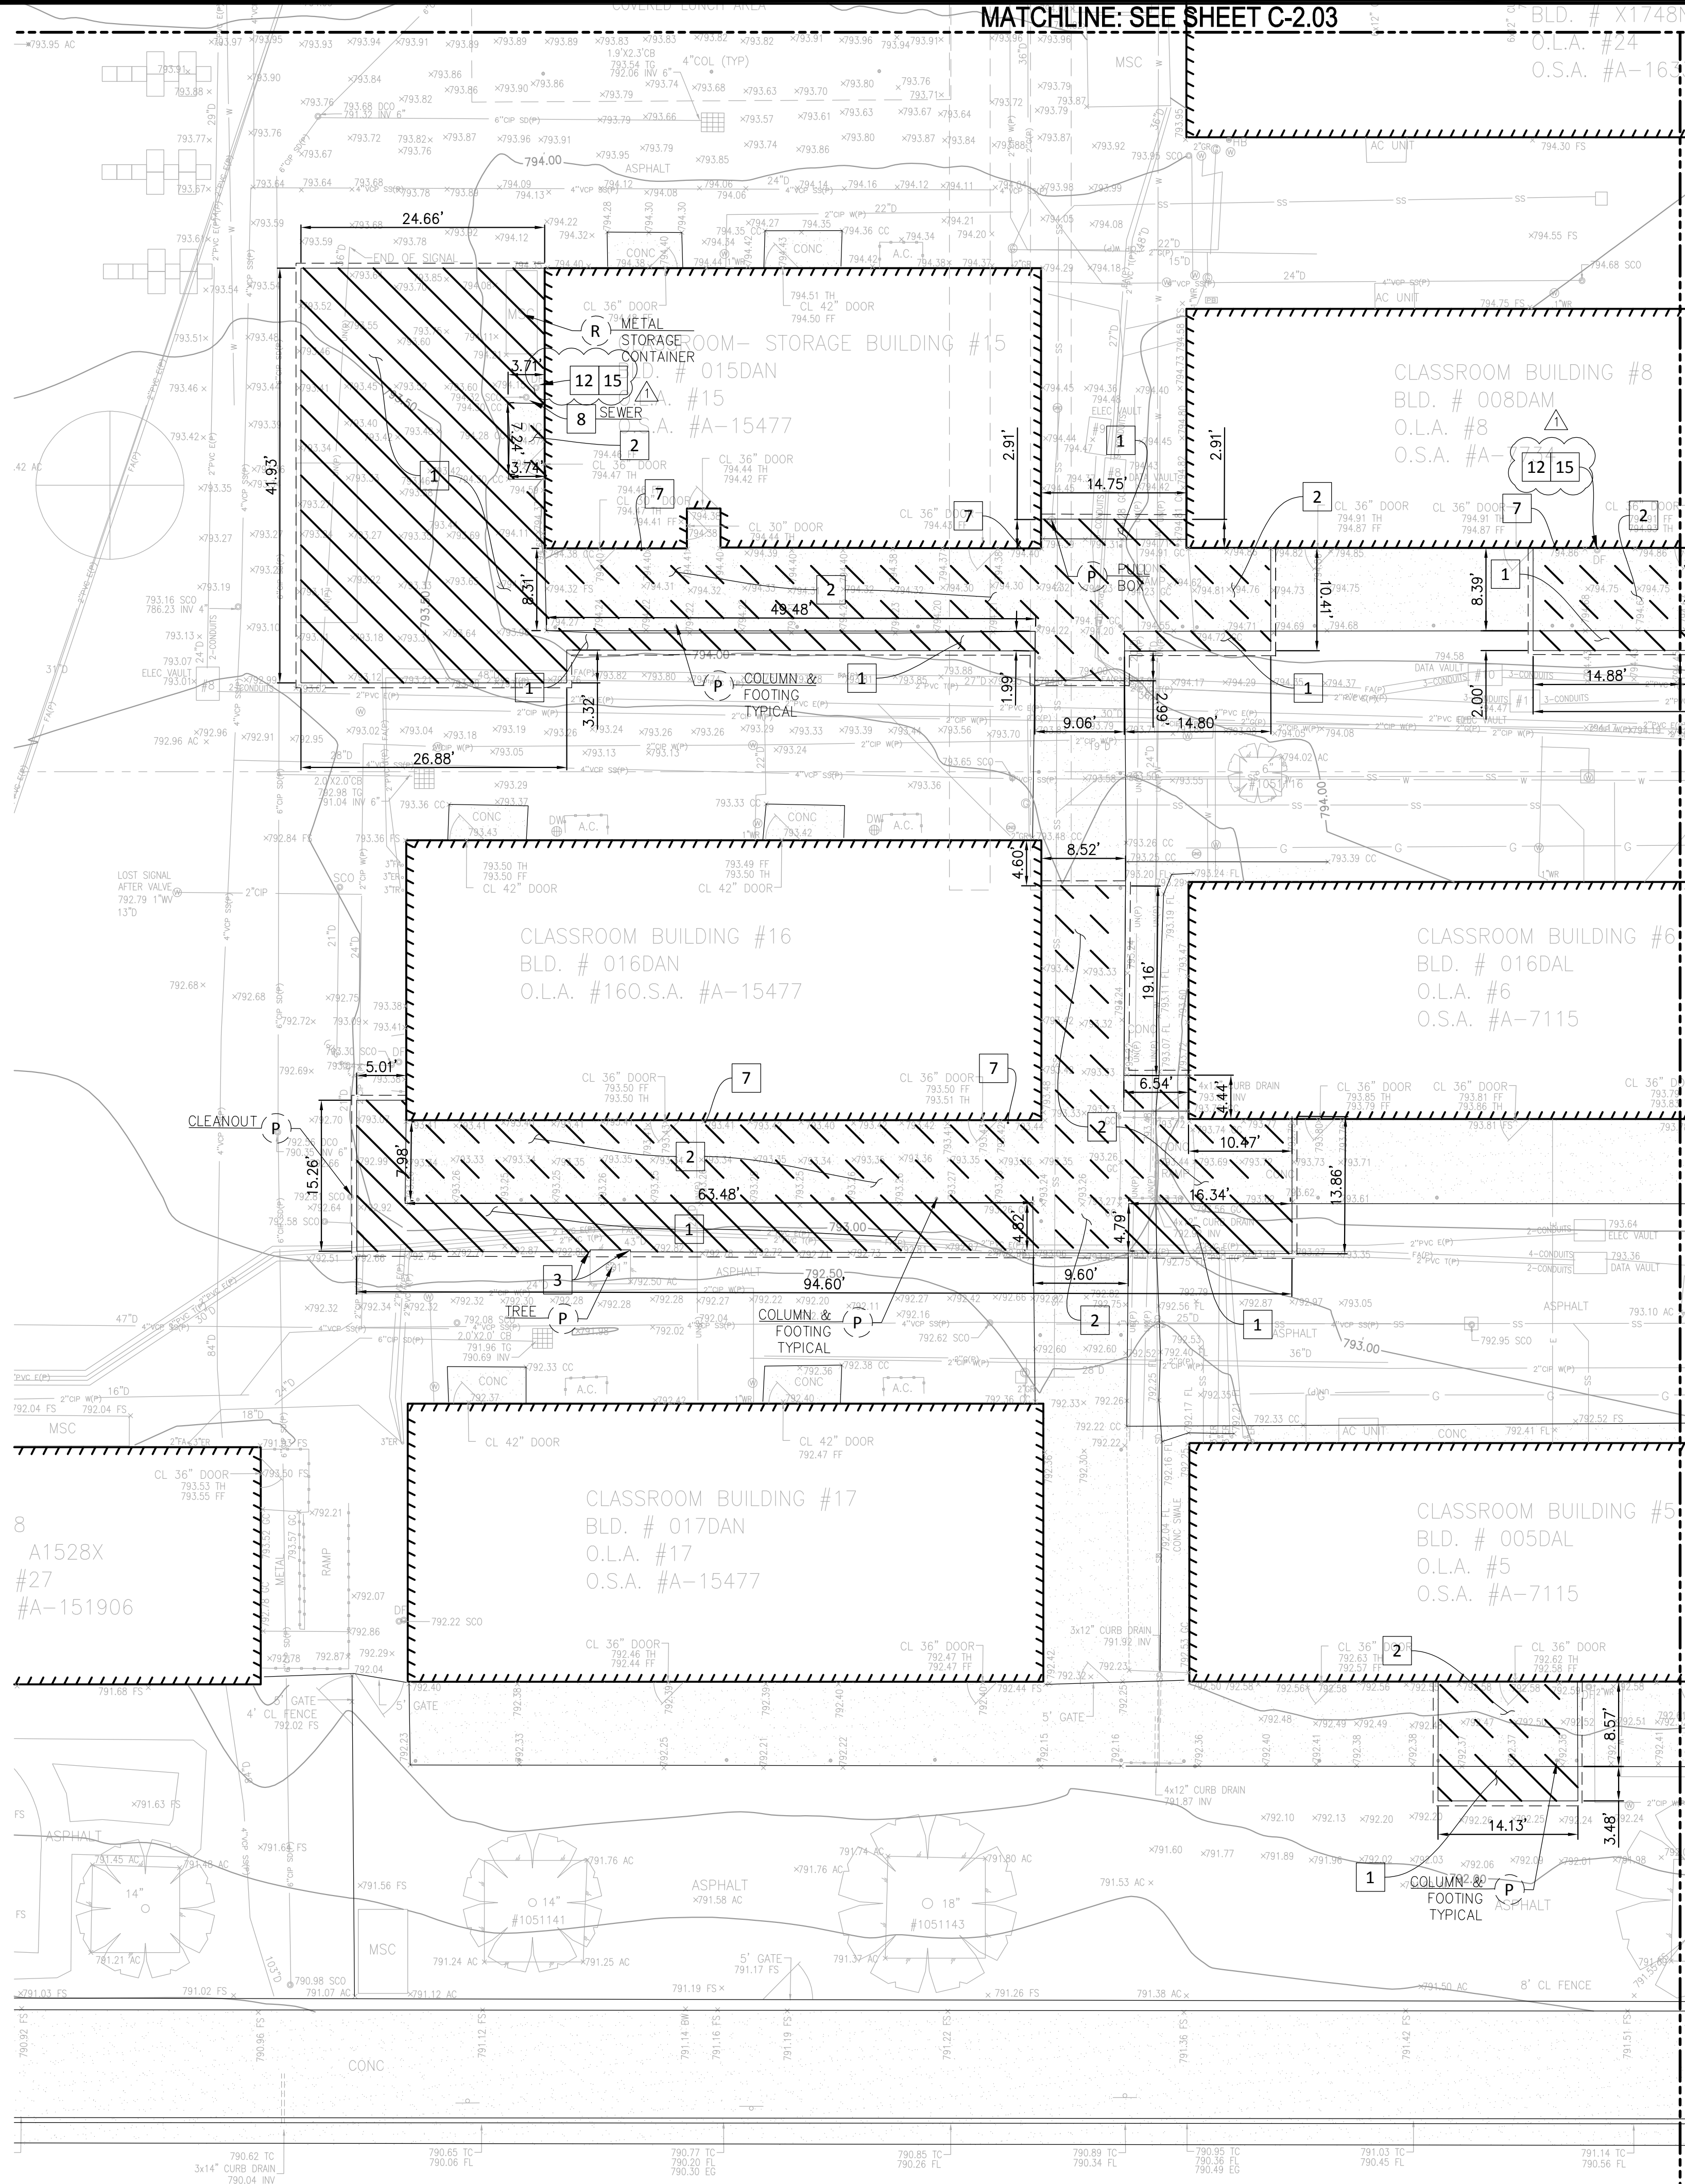

MATCHLINE: SEE SHEET C-2.01

DEMOLITION NOTES:

- 1 2" THICK ASPHALT CONCRETE PAVEMENT, 3" BASE
- 2 4" THICK CONCRETE PAVEMENT, 4" BASE
- 3 REDWOOD HEADER
- 7 DOOR STOP
- 8 YARD BOX
- 12 DRINKING FOUNTAIN
- 15 WATER FILTER



- (P) PROTECT IN PLACE
- (R) RELOCATE EXISTING ITEM, SEE ARCHITECTURAL SITE PLAN A-1.01 FOR LOCATION.

DEMOLITION GENERAL NOTES:

- PROTECT EXISTING UTILITY LINES IN PLACE UNLESS OTHERWISE NOTED.
- THE CONTRACTOR SHALL TAKE NECESSARY MEASURES TO PROTECT THE INTEGRITY OF THE ADJACENT STRUCTURES AND ANY IMPROVEMENTS OF ADJACENT PROPERTIES DURING DEMOLITION AND CONSTRUCTION.
- THE CONTRACTOR SHALL REPAIR AND RESTORE ANY STRUCTURES OR ADJOINING WALLS THAT ARE DAMAGED DURING CONSTRUCTION.
- WHERE NEW PAVEMENT OR CURB IS TO BE CONSTRUCTED UNDER A FENCE, UNTIE AND REMOVE FENCE FABRIC TO PERMIT CONSTRUCTION. AFTER CONSTRUCTION, ADD OR CUT AND KNUCKLE FABRIC TO FIT NEW SURFACE AND RE-INSTALL.
- IN ADDITION TO SCANNING AND LOCATING UNDERGROUND OR IN-WALL UTILITIES, CONTRACTOR TO CAREFULLY HAND CHIP AT EXISTING UTILITY LINES AND RISERS IN DEMOLITION FOOTPRINTS.

LEGEND:

- REMOVE EXISTING CONCRETE PAVEMENT (1)
- REMOVE EXISTING ASPHALT CONCRETE PAVEMENT (2)
- SAWCUT & JOIN LINE
- REMOVE (UNLESS OTHERWISE NOTED) (#)

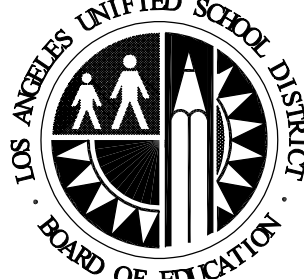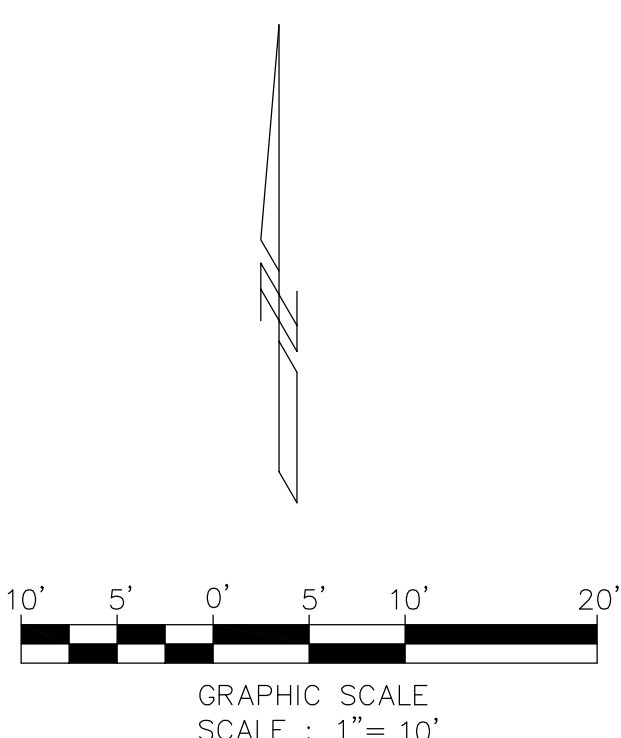

LOS ANGELES UNIFIED SCHOOL DISTRICT
ASSET MANAGEMENT
FACILITIES SERVICES DIVISION
333 S. BEAUDRY AVENUE, 23RD FLOOR
LOS ANGELES, CALIFORNIA 90017

PROJECT TITLE AND SCHOOL LOCATION

STRATHERN STREET
SCHOOL
VOLUNTARY BARRIER
REMOVAL

7939 ST. CLAIRE AVENUE
N. HOLLYWOOD, CA 91605
COLIN ID No.: 10373687


DSA# 03-125645

COMMISSIONED ARCHITECT

MLA

ML ARCHITECTURE
355 PASADENA AVENUE
SOUTH PASADENA, CA91030

STAMPS/SEALS

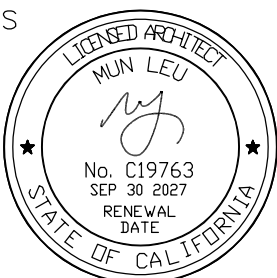

CONSULTANT


MOLLENHAUER GROUP

CIVIL ENGINEERING
SURVEYING-MAPPING
LAND DEVELOPMENT
213 624 2661 TEL
919 W. GLENDALE BLVD.,
2ND FLOOR
GLENDALE, CALIFORNIA
91202

STAMPS/SEALS



KEY PLAN

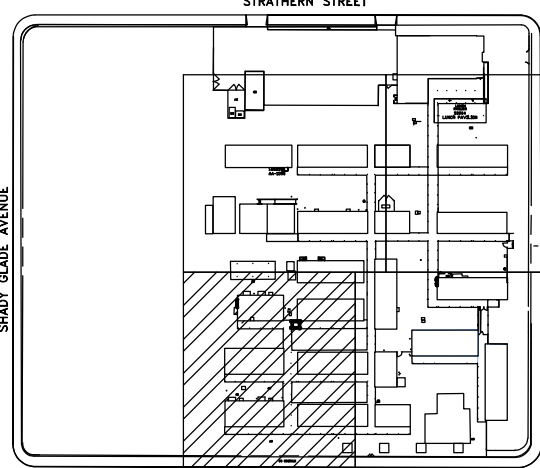

ADDENDUM 1 06/02/26

SHEET TITLE:

DEMOLITION PLAN
SOUTH

PROJECT NO.: 23004

PROJECT ARCH: ML ARCHITECTURE

DRAWN: MK

CHECKED: TT

SHEET NUMBER


C-2.04

DATE: 10-24-2025

SHEET: OF:

MATCHLINE: SEE SHEET C-3.02

MATCHLINE: SEE SHEET C-3.04

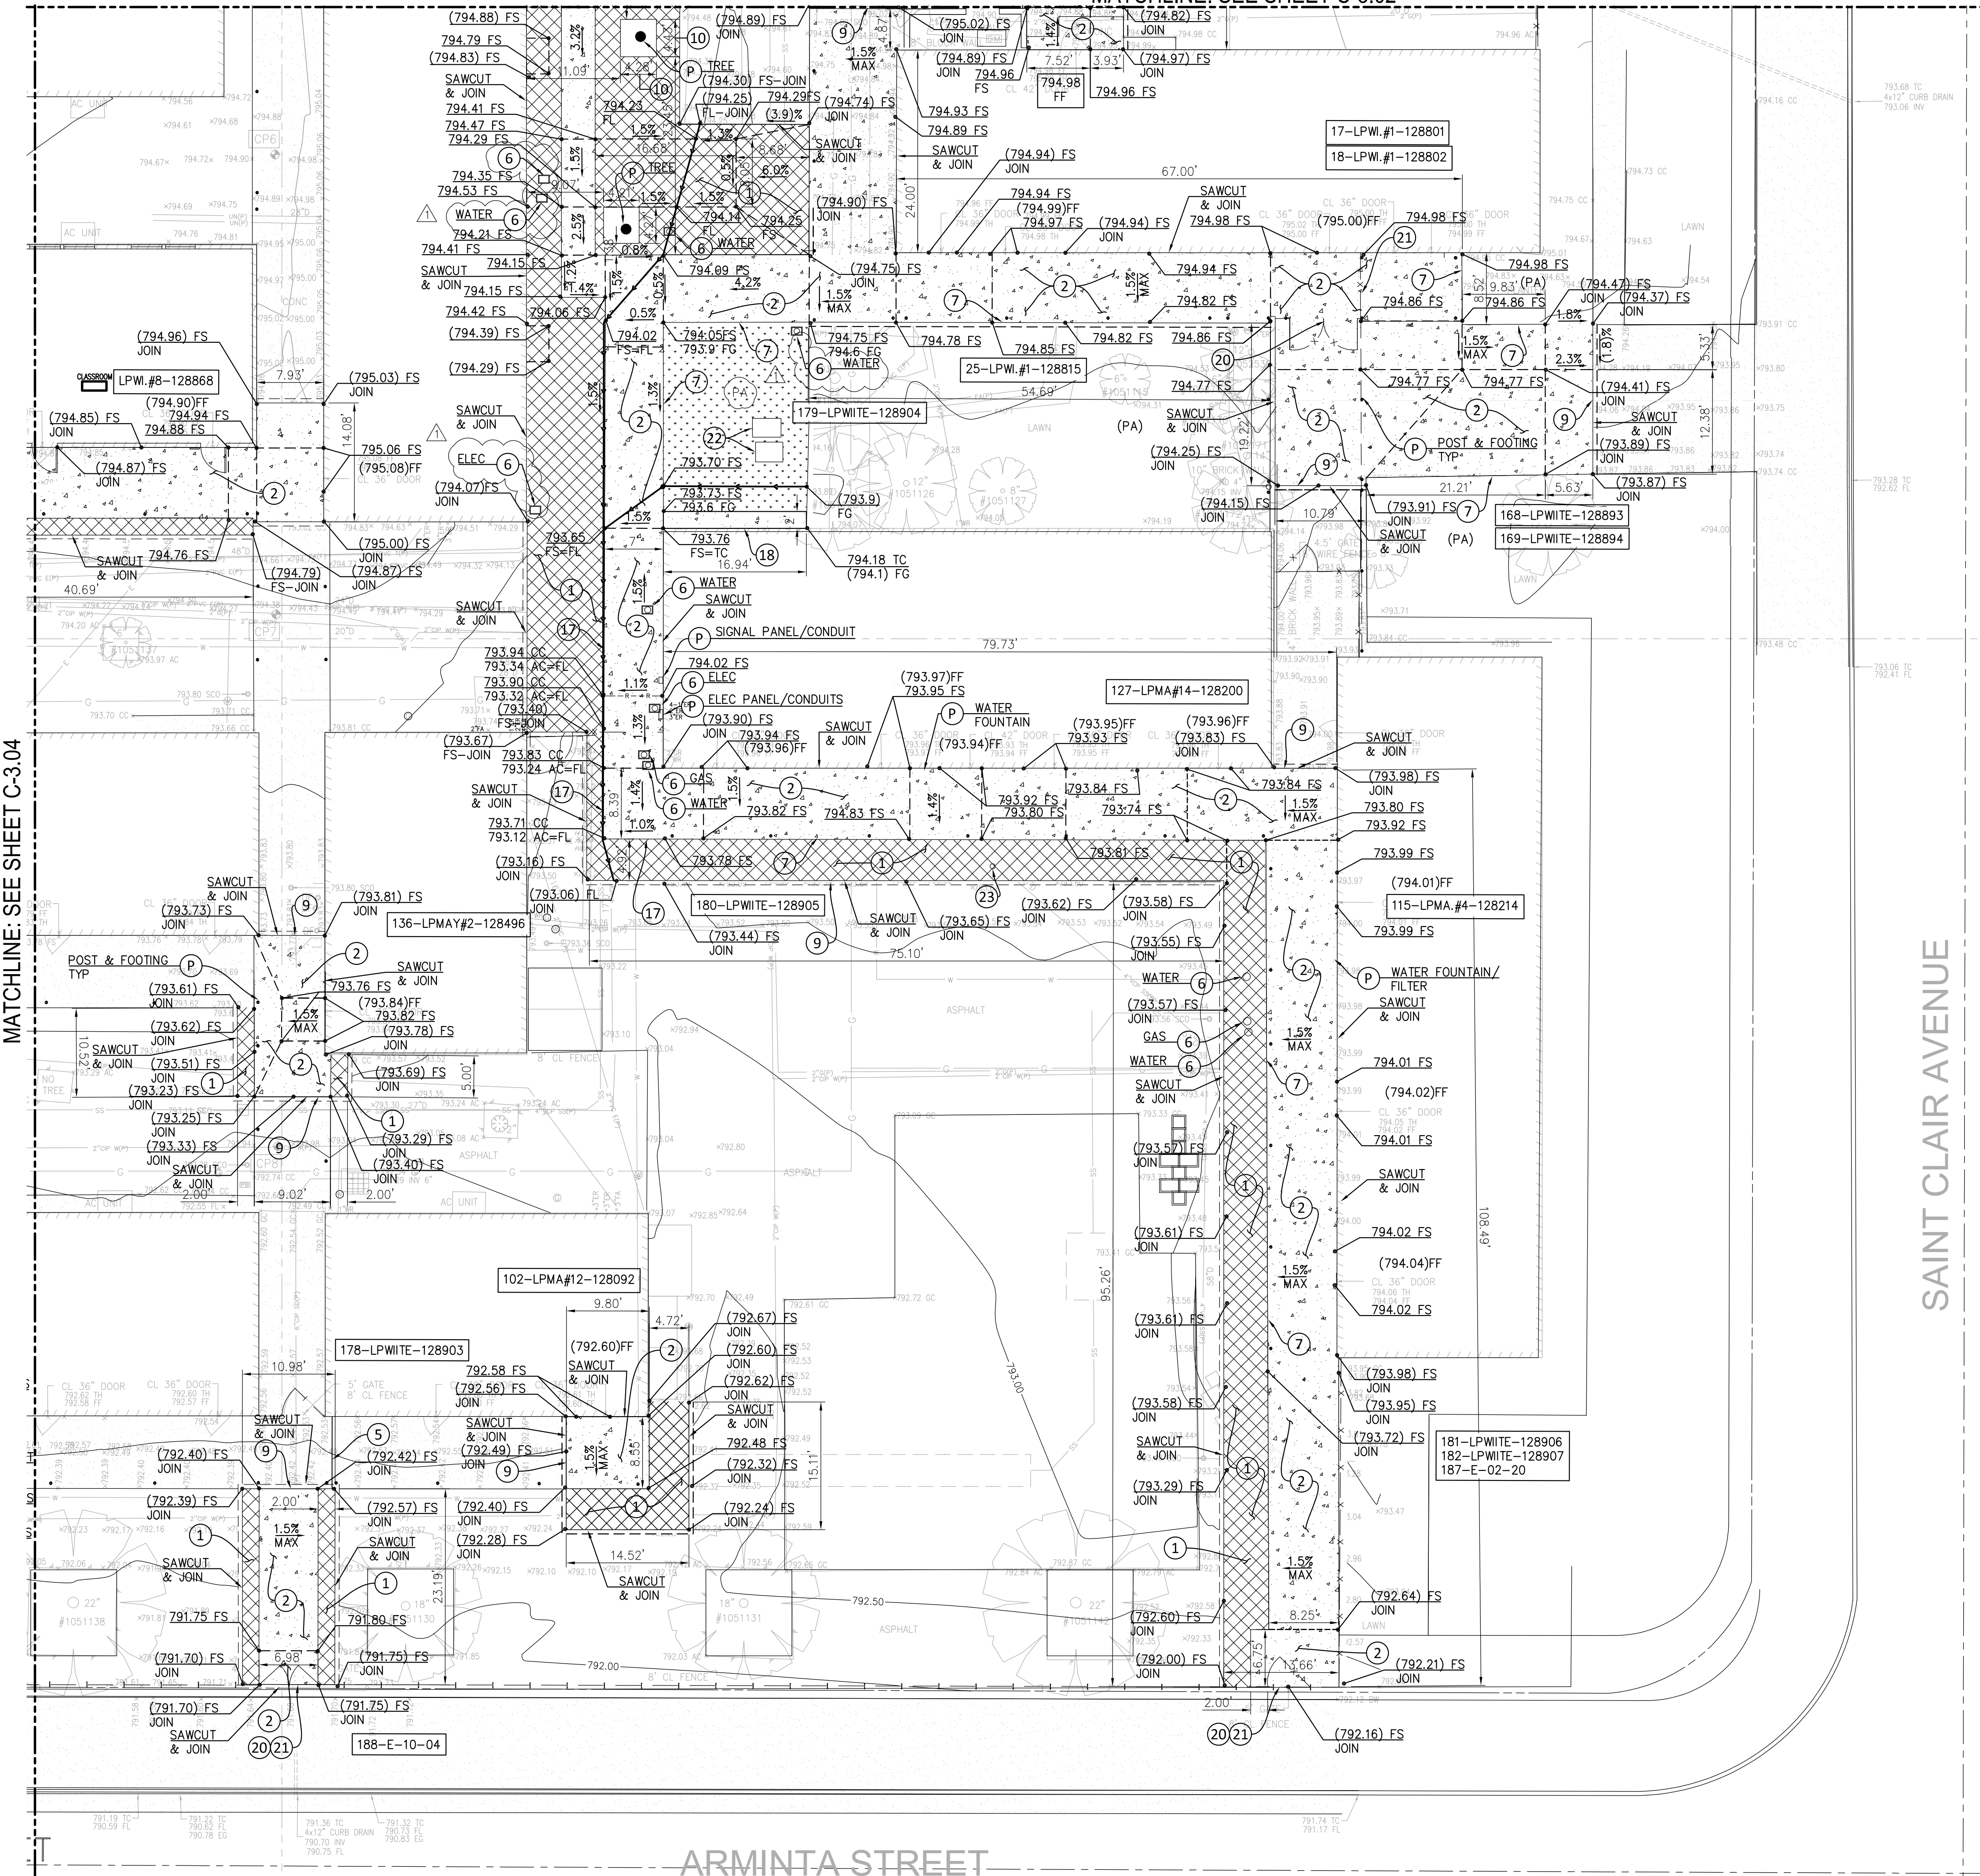

CONSTRUCTION NOTES:


- ① ASPHALT CONCRETE PAVEMENT PER DETAIL C-5.01
- ② CONCRETE PAVEMENT PER DETAIL C-5.01
- ⑤ EXPANSION JOINT FILLER PER DETAIL C-5.01 TYPE A
- ⑥ YARD BOX PER DETAIL C-5.01
- ⑦ THICKENED EDGE PER DETAIL C-5.01 SEE GENERAL NOTE 2 HEREON
- ⑧ DOWEL #4 REBARS @ 18" O.C. PER DETAIL C-5.01 TYPE A ALTERNATIVE
- ⑩ REDWOOD HEADER PER DETAIL C-5.01
- ⑪ THICKENED EDGE WITH SAFETY RAIL PER DETAIL C-5.01
- ⑫ CONCRETE MOWING STRIP PER DETAIL C-5.01
- ⑬ REINSTALL GATE, SEE GENERAL NOTE 5
- ⑭ REINSTALL FENCE FABRIC, SEE GENERAL NOTE 4
- ⑮ ADJUST VAULT PER DETAIL C-5.01
- ⑯ SEWER CLEANOUT PER DETAIL C-5.01
- P PROTECT IN PLACE

LEGEND:

- ASPHALT CONCRETE PAVEMENT TYPE PER PLAN ① C-5.01
- PORTLAND CONCRETE PAVEMENT TYPE PER PLAN ② C-5.01
- NEW PLANTED AREA
- LIMIT OF WORK
- SAWCUT AND JOIN LINE
- GRADE BREAK
- RIDGE LINE
- FLOW LINE

GENERAL NOTES:

1. EXPANSION JOINTS SHALL BE CONSTRUCTED 20' FEET APART PER PROJECT SPECIFICATIONS. CONTRACTION JOINTS SHALL BE CONSTRUCTED AT INTERVALS OF 4' MINIMUM ON WALKWAYS/EXTERIOR SLABS.
2. THICKENED EDGE SHALL BE CONSTRUCTED ALONG ALL OUTER EDGES OF CONCRETE PAVEMENT.
3. SEE DETAIL 8/C5.01 WHERE NEW PAVEMENT JOINS EXISTING ASPHALT PAVEMENT.
4. WHERE NEW PAVEMENT OR CURB WILL BE CONSTRUCTED UNDER A FENCE, UNITE AND REMOVE FENCE FABRIC TO PERMIT CONSTRUCTION. AFTER CONSTRUCTION, ADD OR CUT AND KNUCKLE FABRIC TO FIT NEW SURFACE AND RE-INSTALL.
5. WHERE NEW PAVEMENT WILL BE CONSTRUCTED UNDER AN EXISTING GATE, REMOVE GATE TO PERMIT CONSTRUCTION AND RE-INSTALL AFTER PAVEMENT WORK IS COMPLETED.
6. WHERE NEW PAVEMENTS ABUTS AGAINST AN EXISTING BUILDING, PROVIDE A MINIMUM OF 1.00% POSITIVE SLOPE AWAY FROM THE BUILDING.
7. WHERE NEW PAVEMENT ABUTS AGAINST AN EXISTING DOOR LANDING, SEE ARCHITECTURAL PLAN DETAIL 2/ACS-8.00.

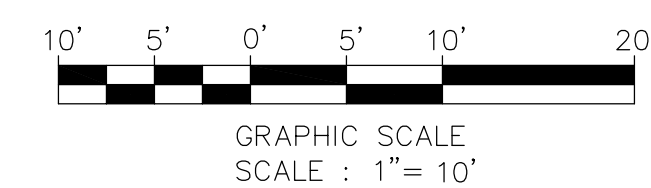

LOS ANGELES UNIFIED SCHOOL DISTRICT
ASSET MANAGEMENT
FACILITIES SERVICES DIVISION
333 S. BEAUDRY AVENUE, 23RD FLOOR
LOS ANGELES, CALIFORNIA 90017


PROJECT TITLE AND SCHOOL LOCATION
STRATHERN STREET SCHOOL
VOLUNTARY BARRIER REMOVAL
7939 ST. CLAIRE AVENUE
N. HOLLYWOOD, CA 91605
COLIN ID No.: 10373687

DSA# 03-125645

COMMISSIONED ARCHITECT

MLA
ML ARCHITECTURE
355 PASADENA AVENUE
SOUTH PASADENA, CA91030

STAMPS/SEALS

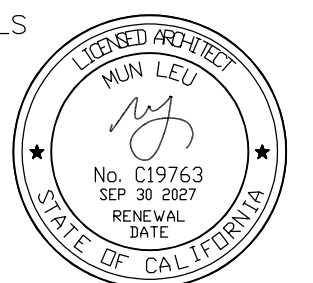


CONSULTANT

MOLLENHAUER GROUP
CIVIL ENGINEERING
SURVEYING+MAPPING
LAND DEVELOPMENT
213 624 2661 TEL
919 W. GLENDALE BLVD.,
2ND FLOOR
GLENDALE, CALIFORNIA
91202

STAMPS/SEALS



KEY PLAN

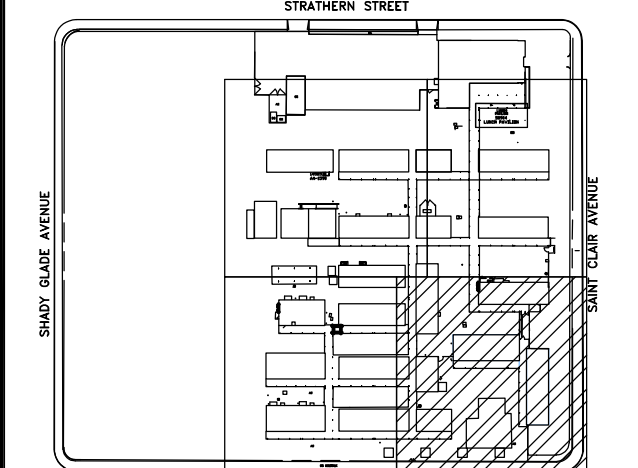

ADDENDUM 1 06/02/26

SHEET TITLE:

GRADING PLAN
SOUTHEAST

PROJECT NO.: 23004 PROJECT ARCH: ML ARCHITECTURE


DRAWN: MK CHECKED: TT

SHEET NUMBER

C-3.01

DATE: 10-24-2025


SHEET: OF:

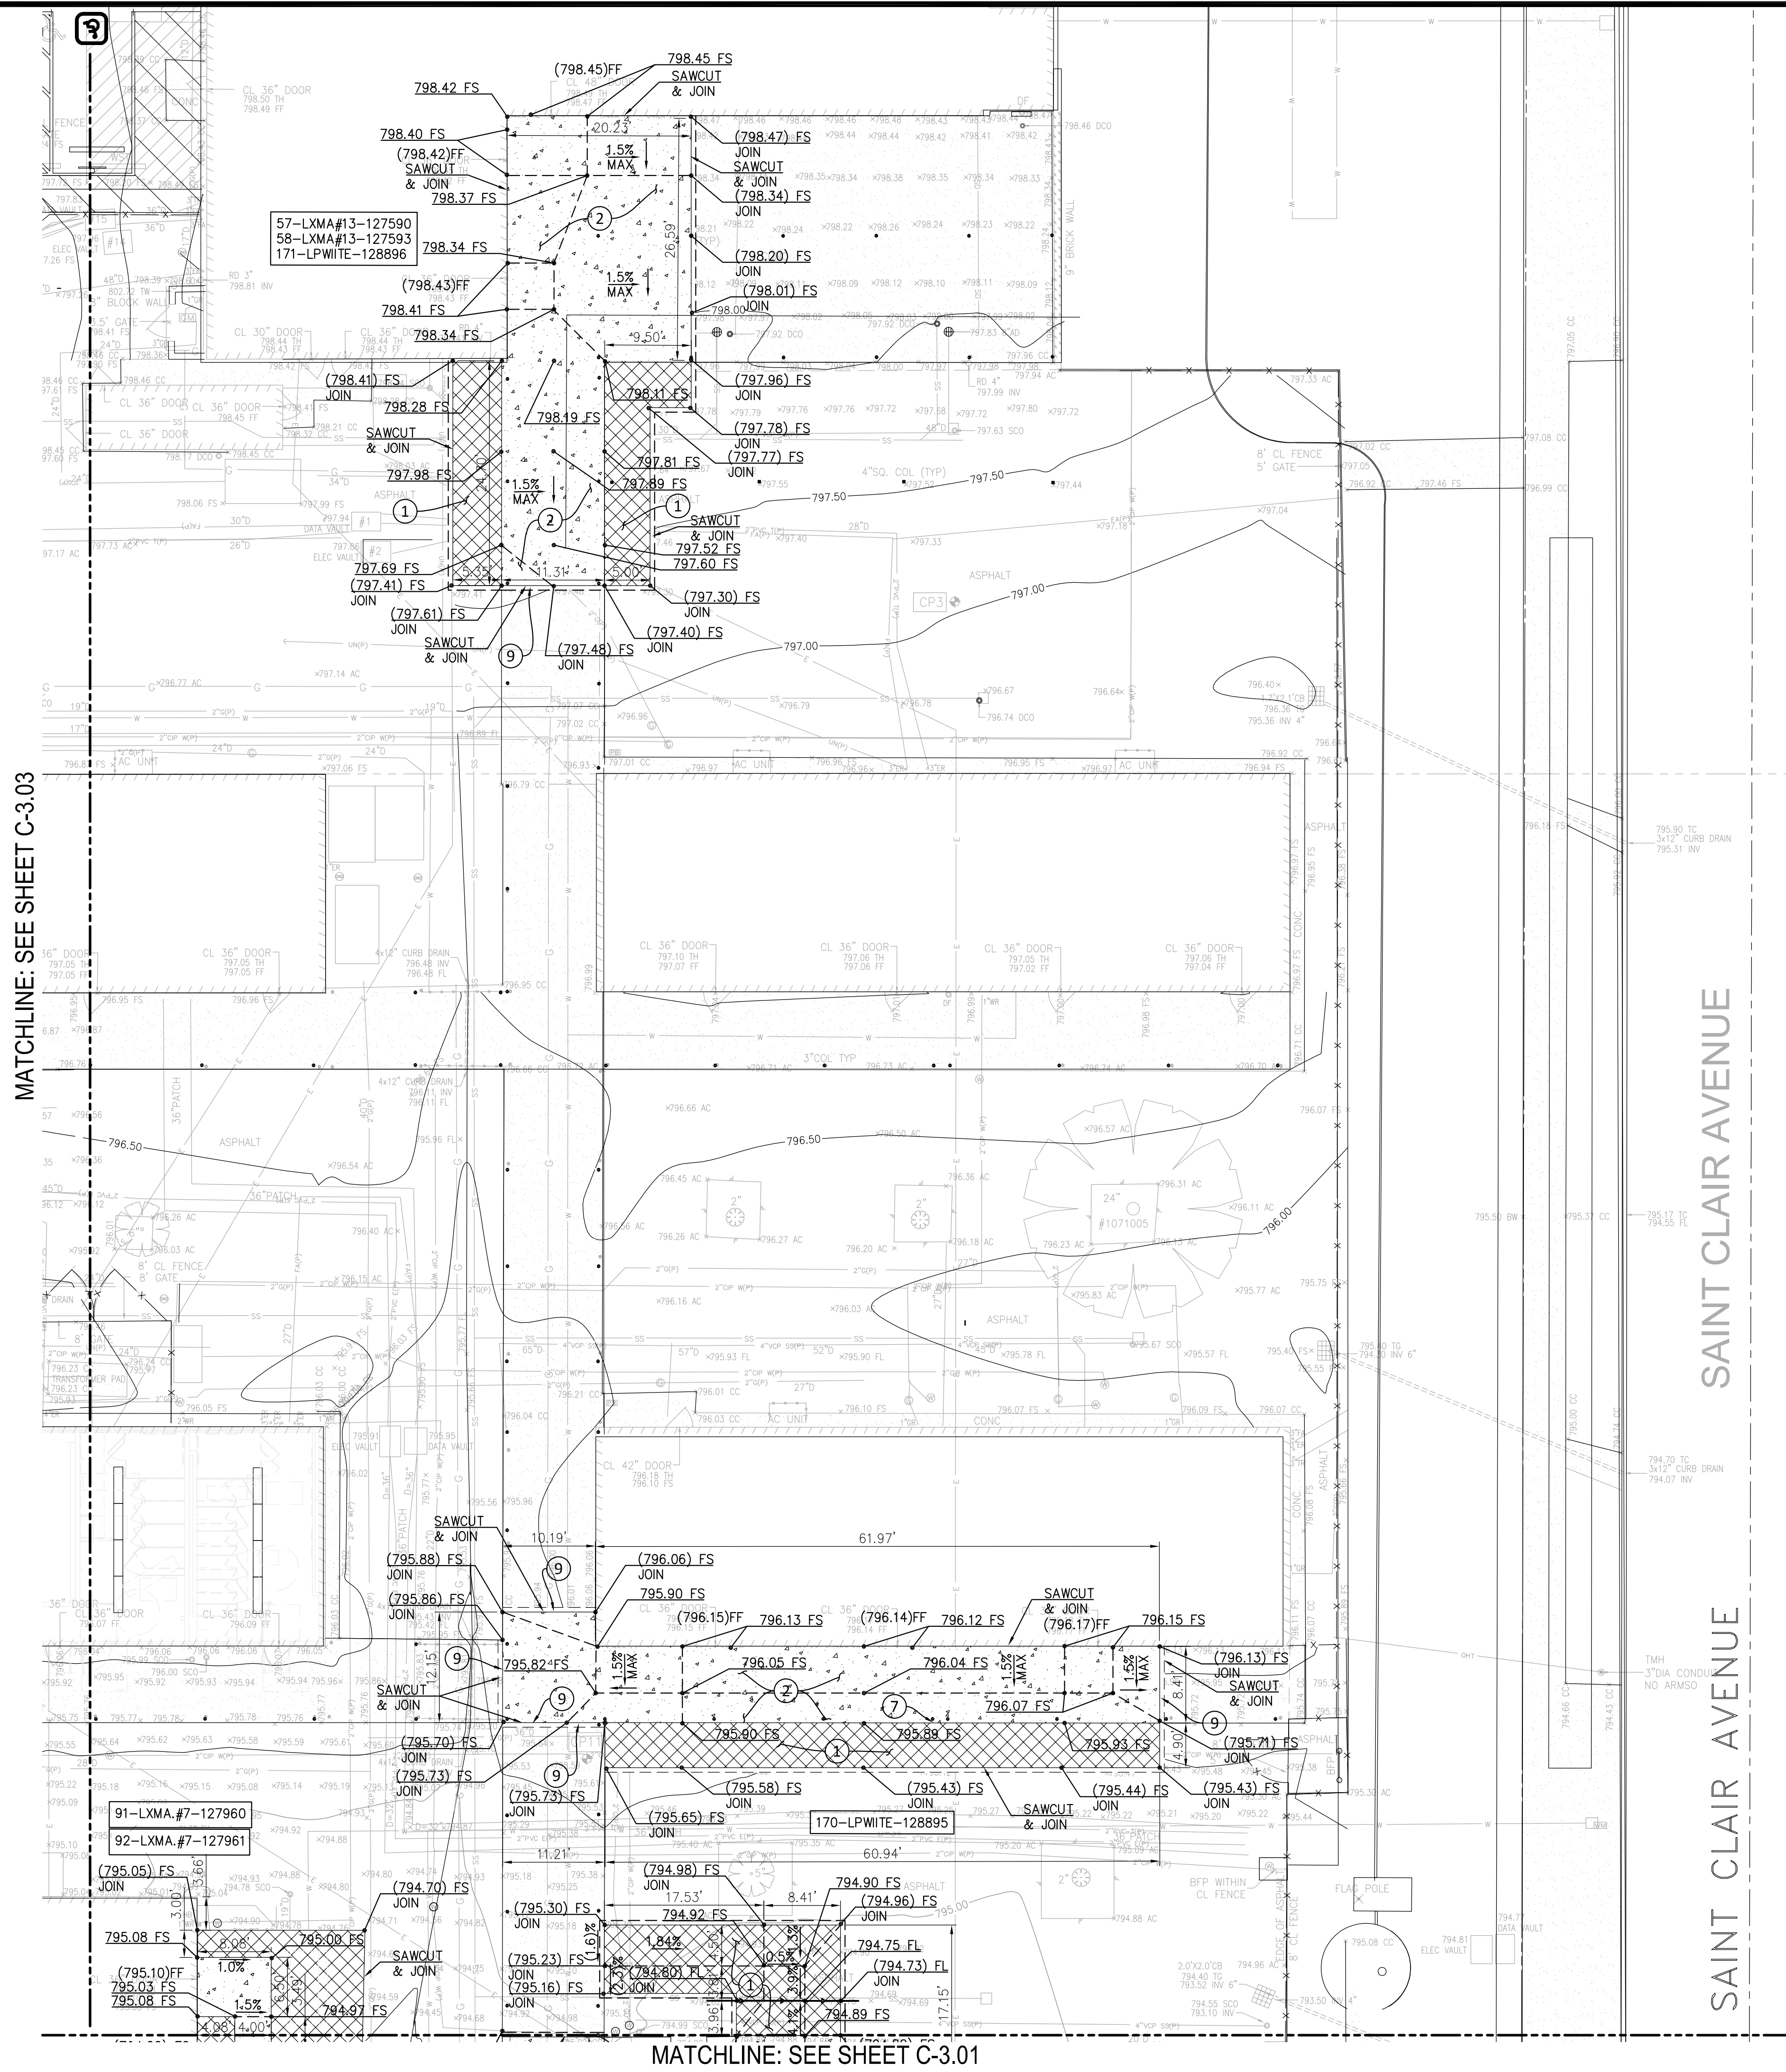

- CONSTRUCTION NOTES:
- 1 ASPHALT CONCRETE PAVEMENT PER DETAIL 1 C-5.01
 - 2 CONCRETE PAVEMENT PER DETAIL 2 C-5.01
 - 7 THICKENED EDGE PER DETAIL 7 C-5.01, SEE GENERAL NOTE 2 HEREON
 - 9 DOWEL #4 REBARS @ 18" O.C. PER DETAIL 3 C-5.01 TYPE A ALTERNATIVE
 - P PROTECT IN PLACE

- LEGEND:
- ASPHALT CONCRETE PAVEMENT TYPE PER PLAN 1 C-5.01
 - PORTLAND CONCRETE PAVEMENT TYPE PER PLAN 2 C-5.01
 - LIMIT OF WORK
 - SAWCUT AND JOIN LINE
 - GRADE BREAK
 - RIDGE LINE
 - FLOW LINE

- GENERAL NOTES:
- EXPANSION JOINTS SHALL BE CONSTRUCTED 20' FEET APART PER PROJECT SPECIFICATIONS. CONTRACTION JOINTS SHALL BE CONSTRUCTED AT INTERVALS OF 4' MINIMUM ON WALKWAYS/EXTERIOR SLABS.
 - THICKENED EDGE SHALL BE CONSTRUCTED ALONG ALL OUTER EDGES OF CONCRETE PAVEMENT.
 - SEE DETAIL 8/C5.01 WHERE NEW PAVEMENT JOINS EXISTING ASPHALT PAVEMENT.
 - WHERE NEW PAVEMENTS ABUTS AGAINST AN EXISTING BUILDING, PROVIDE A MINIMUM OF 1.00% POSITIVE SLOPE AWAY FROM THE BUILDING.
 - WHERE NEW PAVEMENT ABUTS AGAINST AN EXISTING DOOR LANDING, SEE ARCHITECTURAL PLAN DETAIL 2/ACS-8.00.

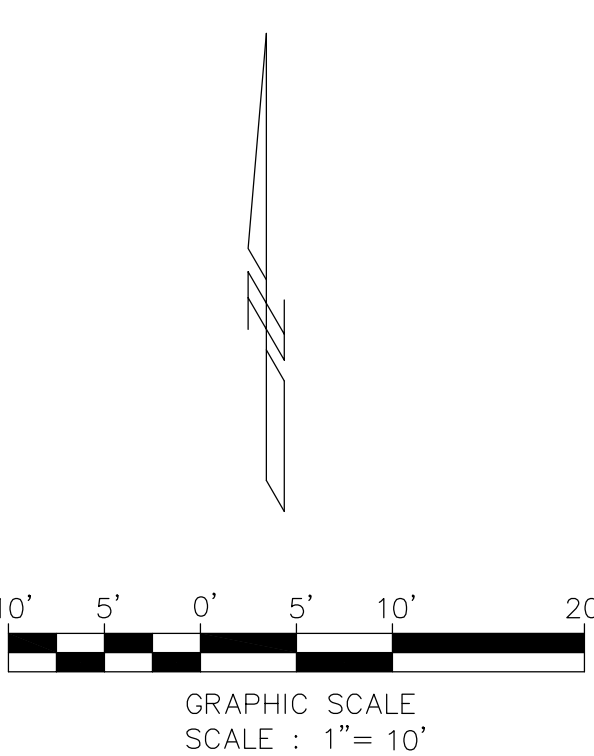

LOS ANGELES UNIFIED SCHOOL DISTRICT
BOARD OF EDUCATION
LOS ANGELES UNIFIED SCHOOL DISTRICT
ASSET MANAGEMENT
FACILITIES SERVICES DIVISION
333 S. BEAUDRY AVENUE, 23RD FLOOR
LOS ANGELES, CALIFORNIA 90017

PROJECT TITLE AND SCHOOL LOCATION
STRATHERN STREET SCHOOL
VOLUNTARY BARRIER REMOVAL
7939 ST. CLAIRE AVENUE
N. HOLLYWOOD, CA 91605
COLIN ID No.: 10373687


DSA# 03-125645

COMMISSIONED ARCHITECT
MLA
ML ARCHITECTURE
355 PASADENA AVENUE
SOUTH PASADENA, CA 91030

STAMPS/SEALS
LEED ARCHITECT
MLA LEU
No. C19763
SEP 30 2023
RENEWAL
DATE
STATE OF CALIFORNIA

CONSULTANT
MOLLENHAUER GROUP
CIVIL ENGINEERING
SURVEYING+MAPPING
LAND DEVELOPMENT
213 624 2661 TEL
919 W. GLENDALE BLVD.,
2ND FLOOR
GLENDALE, CALIFORNIA
91202

STAMPS/SEALS
REGISTERED PROFESSIONAL ENGINEER
No. 82464
CIVIL
STATE OF CALIFORNIA

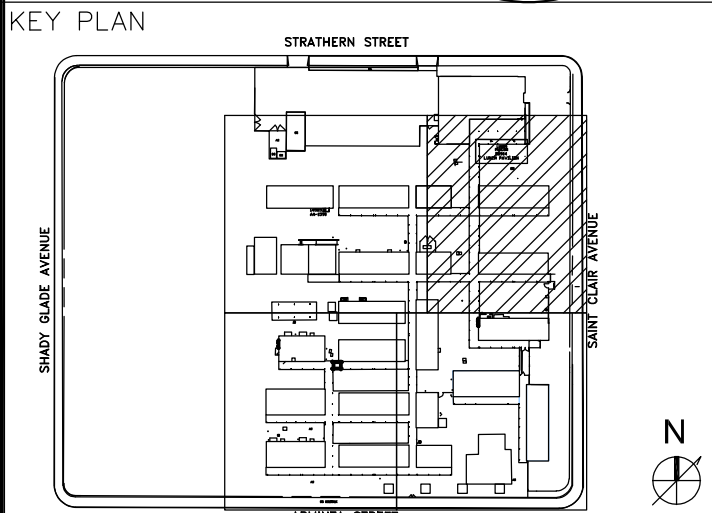


ADDENDUM 1 06/02/26

SHEET TITLE:

GRADING PLAN
NORTHEAST

PROJECT NO.: 23004 PROJECT ARCH: ML ARCHITECTURE
DRAWN: MK CHECKED: TT
SHEET NUMBER
C-3.02
DATE: 10-24-2025 SHEET: OF:

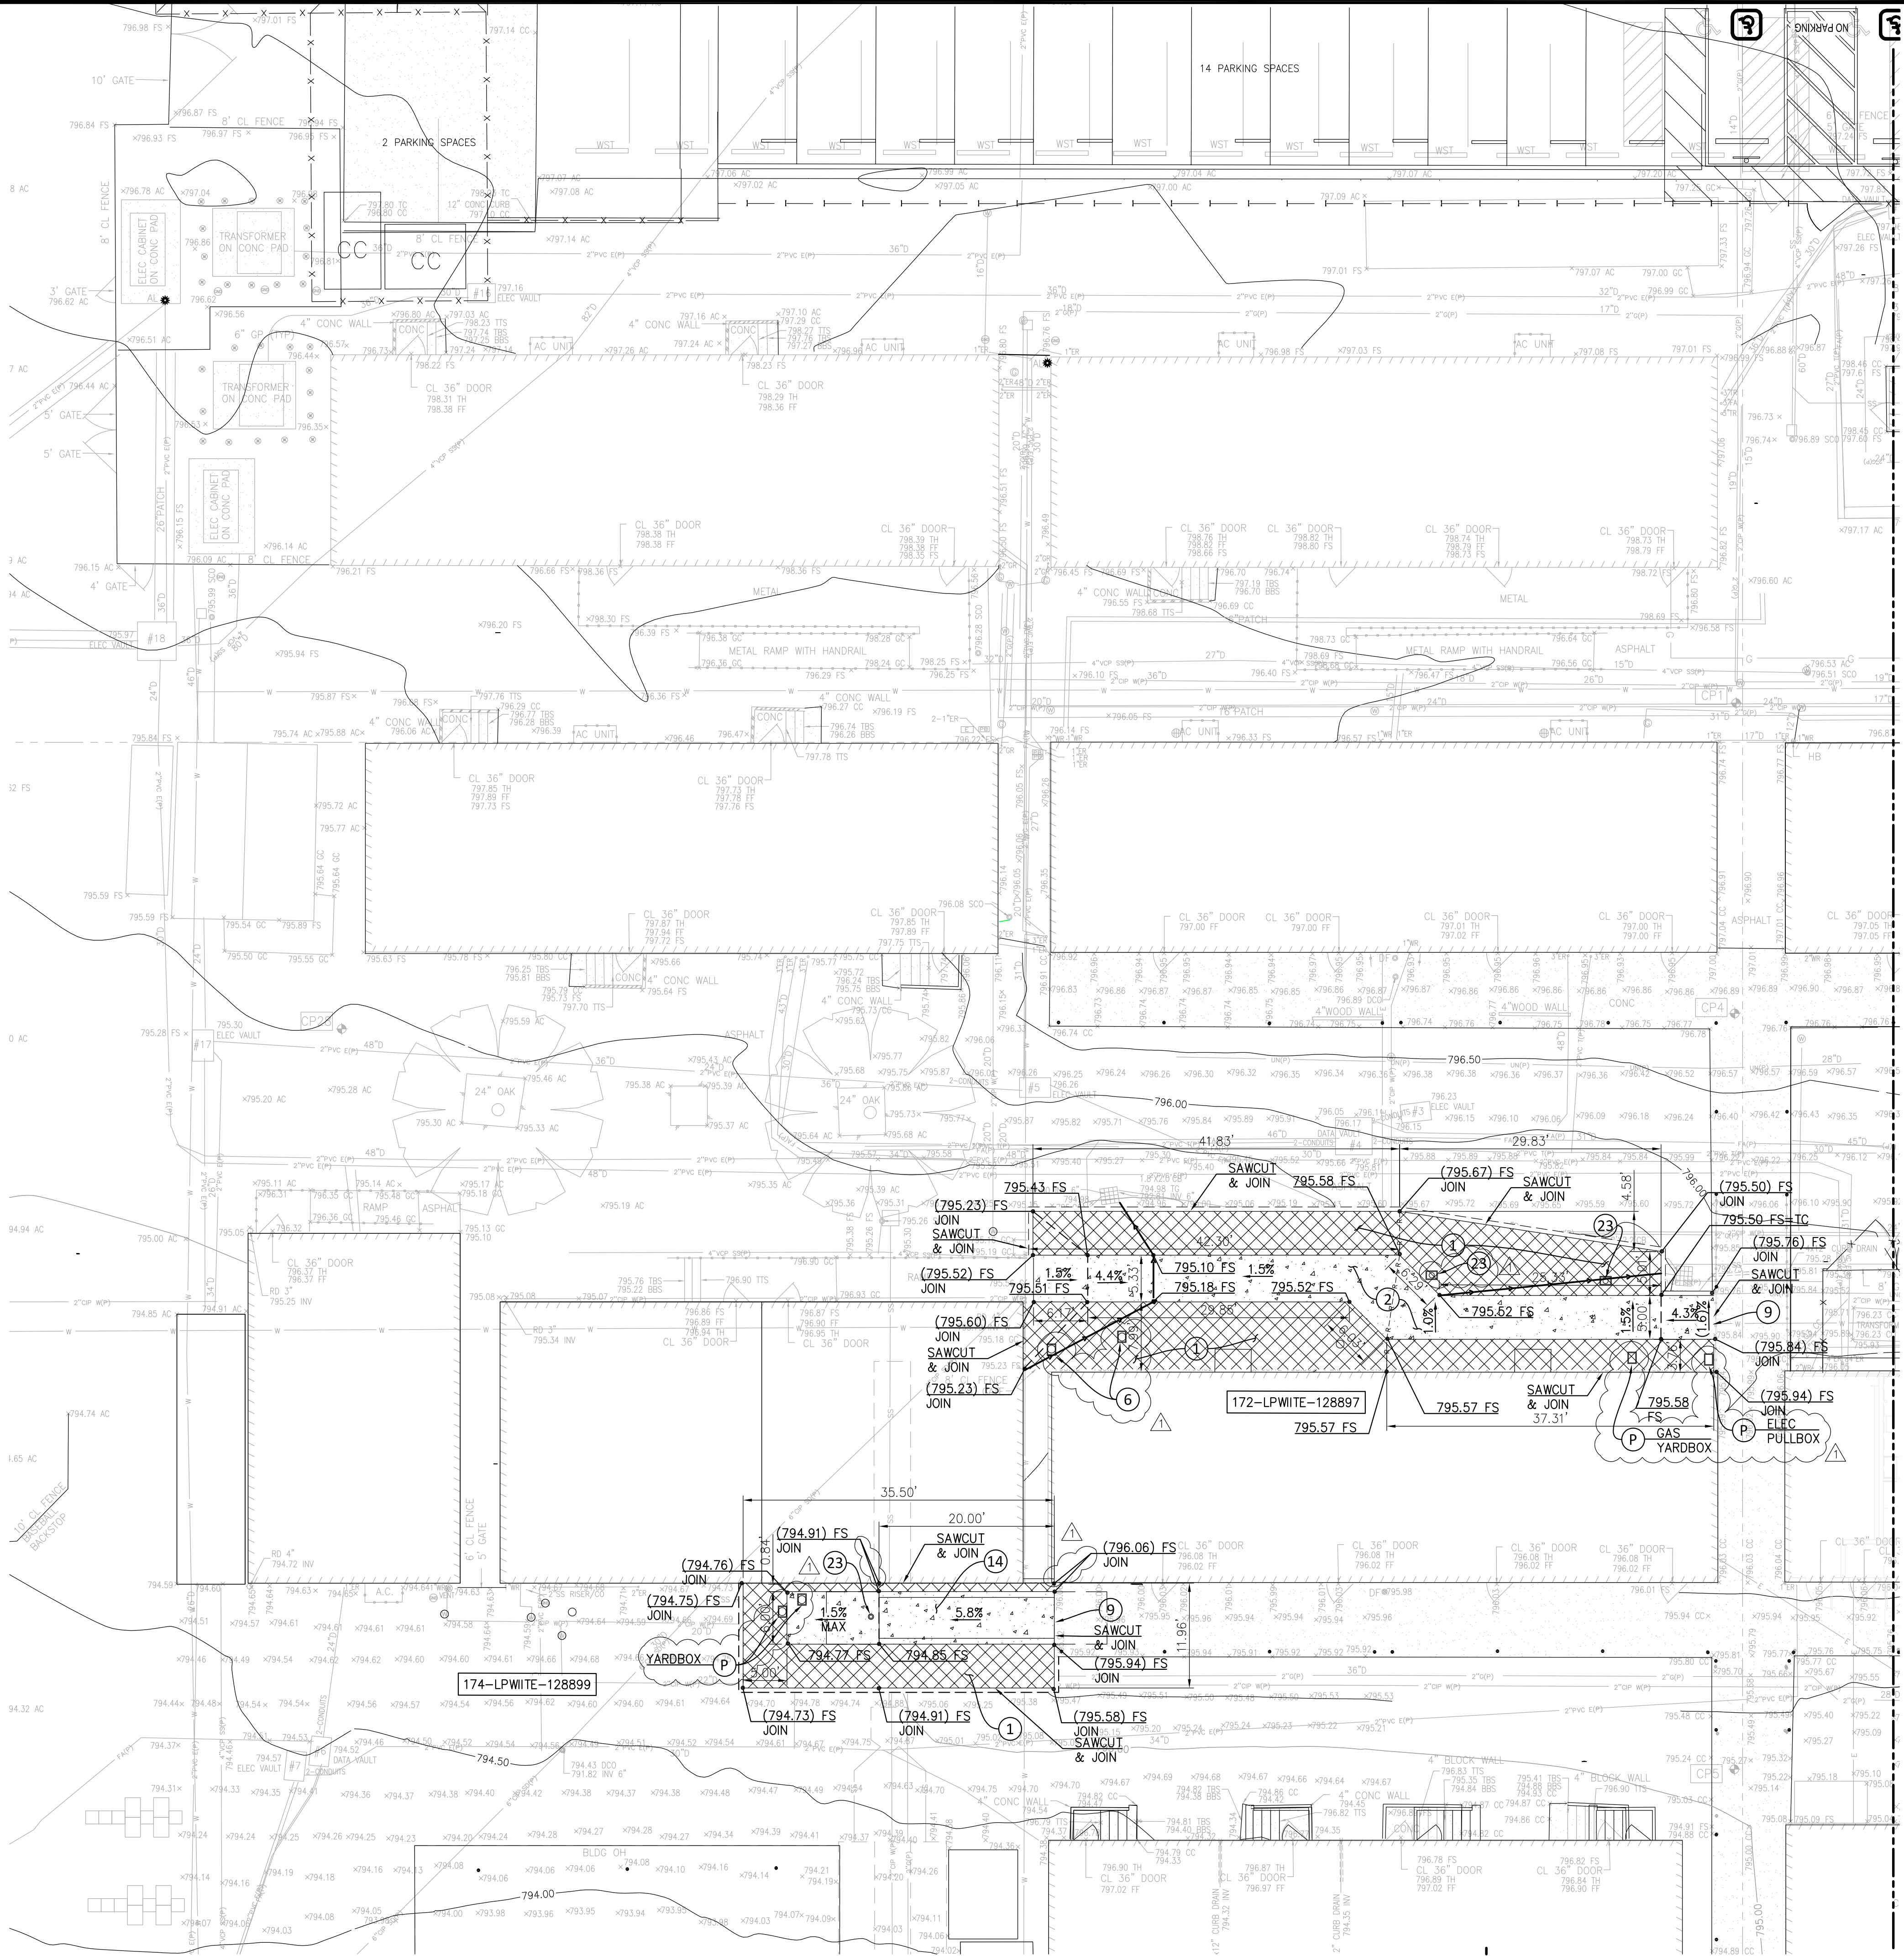

MATCHLINE: SEE SHEET C-3.02

CONSTRUCTION NOTES:


- 1 ASPHALT CONCRETE PAVEMENT PER DETAIL 1 C-5.01
- 2 CONCRETE PAVEMENT PER DETAIL 2 C-5.01
- 6 YARD BOX PER DETAIL 5 C-5.01
- 9 DOWEL #4 REBARS @ 18" O.C. PER DETAIL 3 C-5.01 TYPE A ALTERNATIVE
- 14 CONCRETE RAMP. SEE ARCHITECTURAL PLAN A-2.08 FOR DETAILS
- 23 SEWER CLEANOUT PER DETAIL 11 C-5.01
- P PROTECT IN PLACE

LEGEND:

- ASPHALT CONCRETE PAVEMENT TYPE PER PLAN 1 C-5.01
- PORTLAND CONCRETE PAVEMENT TYPE PER PLAN 2 C-5.01
- LIMIT OF WORK
- SAWCUT AND JOIN LINE
- GRADE BREAK
- RIDGE LINE
- FLOW LINE

GENERAL NOTES:

- EXPANSION JOINTS SHALL BE CONSTRUCTED 20' FEET APART PER PROJECT SPECIFICATIONS. CONTRACTION JOINTS SHALL BE CONSTRUCTED AT INTERVALS OF 4' MINIMUM ON WALKWAYS/EXTERIOR SLABS.
- THICKENED EDGE SHALL BE CONSTRUCTED ALONG ALL OUTER EDGES OF CONCRETE PAVEMENT.
- SEE DETAIL 8/C5.01 WHERE NEW PAVEMENT JOINS EXISTING ASPHALT PAVEMENT.
- WHERE NEW PAVEMENTS ABUTS AGAINST AN EXISTING BUILDING, PROVIDE A MINIMUM OF 1.00% POSITIVE SLOPE AWAY FROM THE BUILDING.
- WHERE NEW PAVEMENT ABUTS AGAINST AN EXISTING DOOR LANDING, SEE ARCHITECTURAL PLAN DETAIL 2/ACS-8.00.

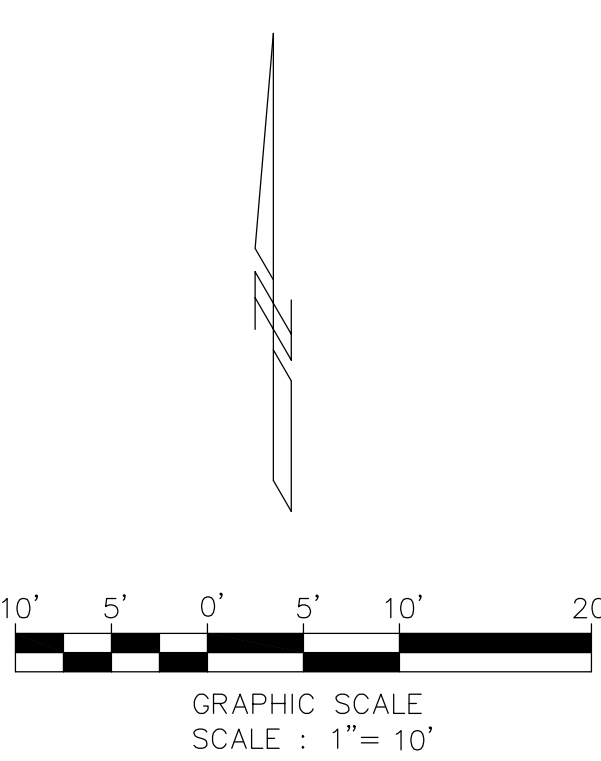




**LOS ANGELES UNIFIED
SCHOOL DISTRICT**
ASSET MANAGEMENT
FACILITIES SERVICES DIVISION
333 S. BEAUDRY AVENUE, 23RD FLOOR
LOS ANGELES, CALIFORNIA 90017

PROJECT TITLE AND SCHOOL LOCATION
**STRATHERN STREET
SCHOOL
VOLUNTARY BARRIER
REMOVAL**
7939 ST. CLAIRE AVENUE
N. HOLLYWOOD, CA 91605
COLIN ID No.: 10373687

DSA# 03-125645
COMMISSIONED ARCHITECT
MLA
ML ARCHITECTURE
355 PASADENA AVENUE
SOUTH PASADENA, CA91030

STAMPS/SEALS

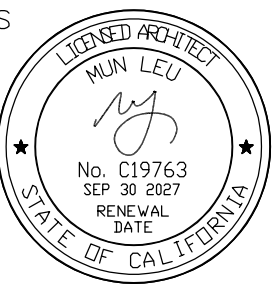


CONSULTANT



MOLLENHAUER GROUP
CIVIL ENGINEERING
SURVEYING+MAPPING
LAND DEVELOPMENT
213 624 2661 TEL
919 W. GLENDALE BLVD.,
2ND FLOOR
GLENDALE, CALIFORNIA
91202

STAMPS/SEALS



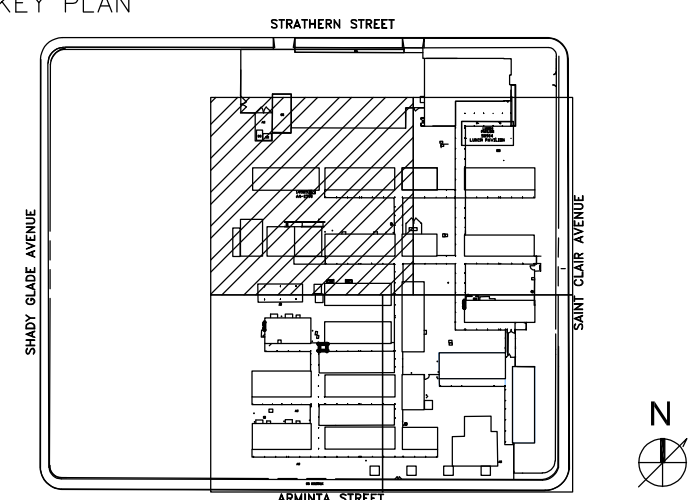

ADDENDUM 1 06/02/26

SHEET TITLE:

**GRADING PLAN
NORTH**


PROJECT NO.: 23004PROJECT ARCH: ML ARCHITECTURE

DRAWN: MKCHECKED: TT

SHEET NUMBER

C-3.03

DATE: 10-24-2025SHEET: OF:

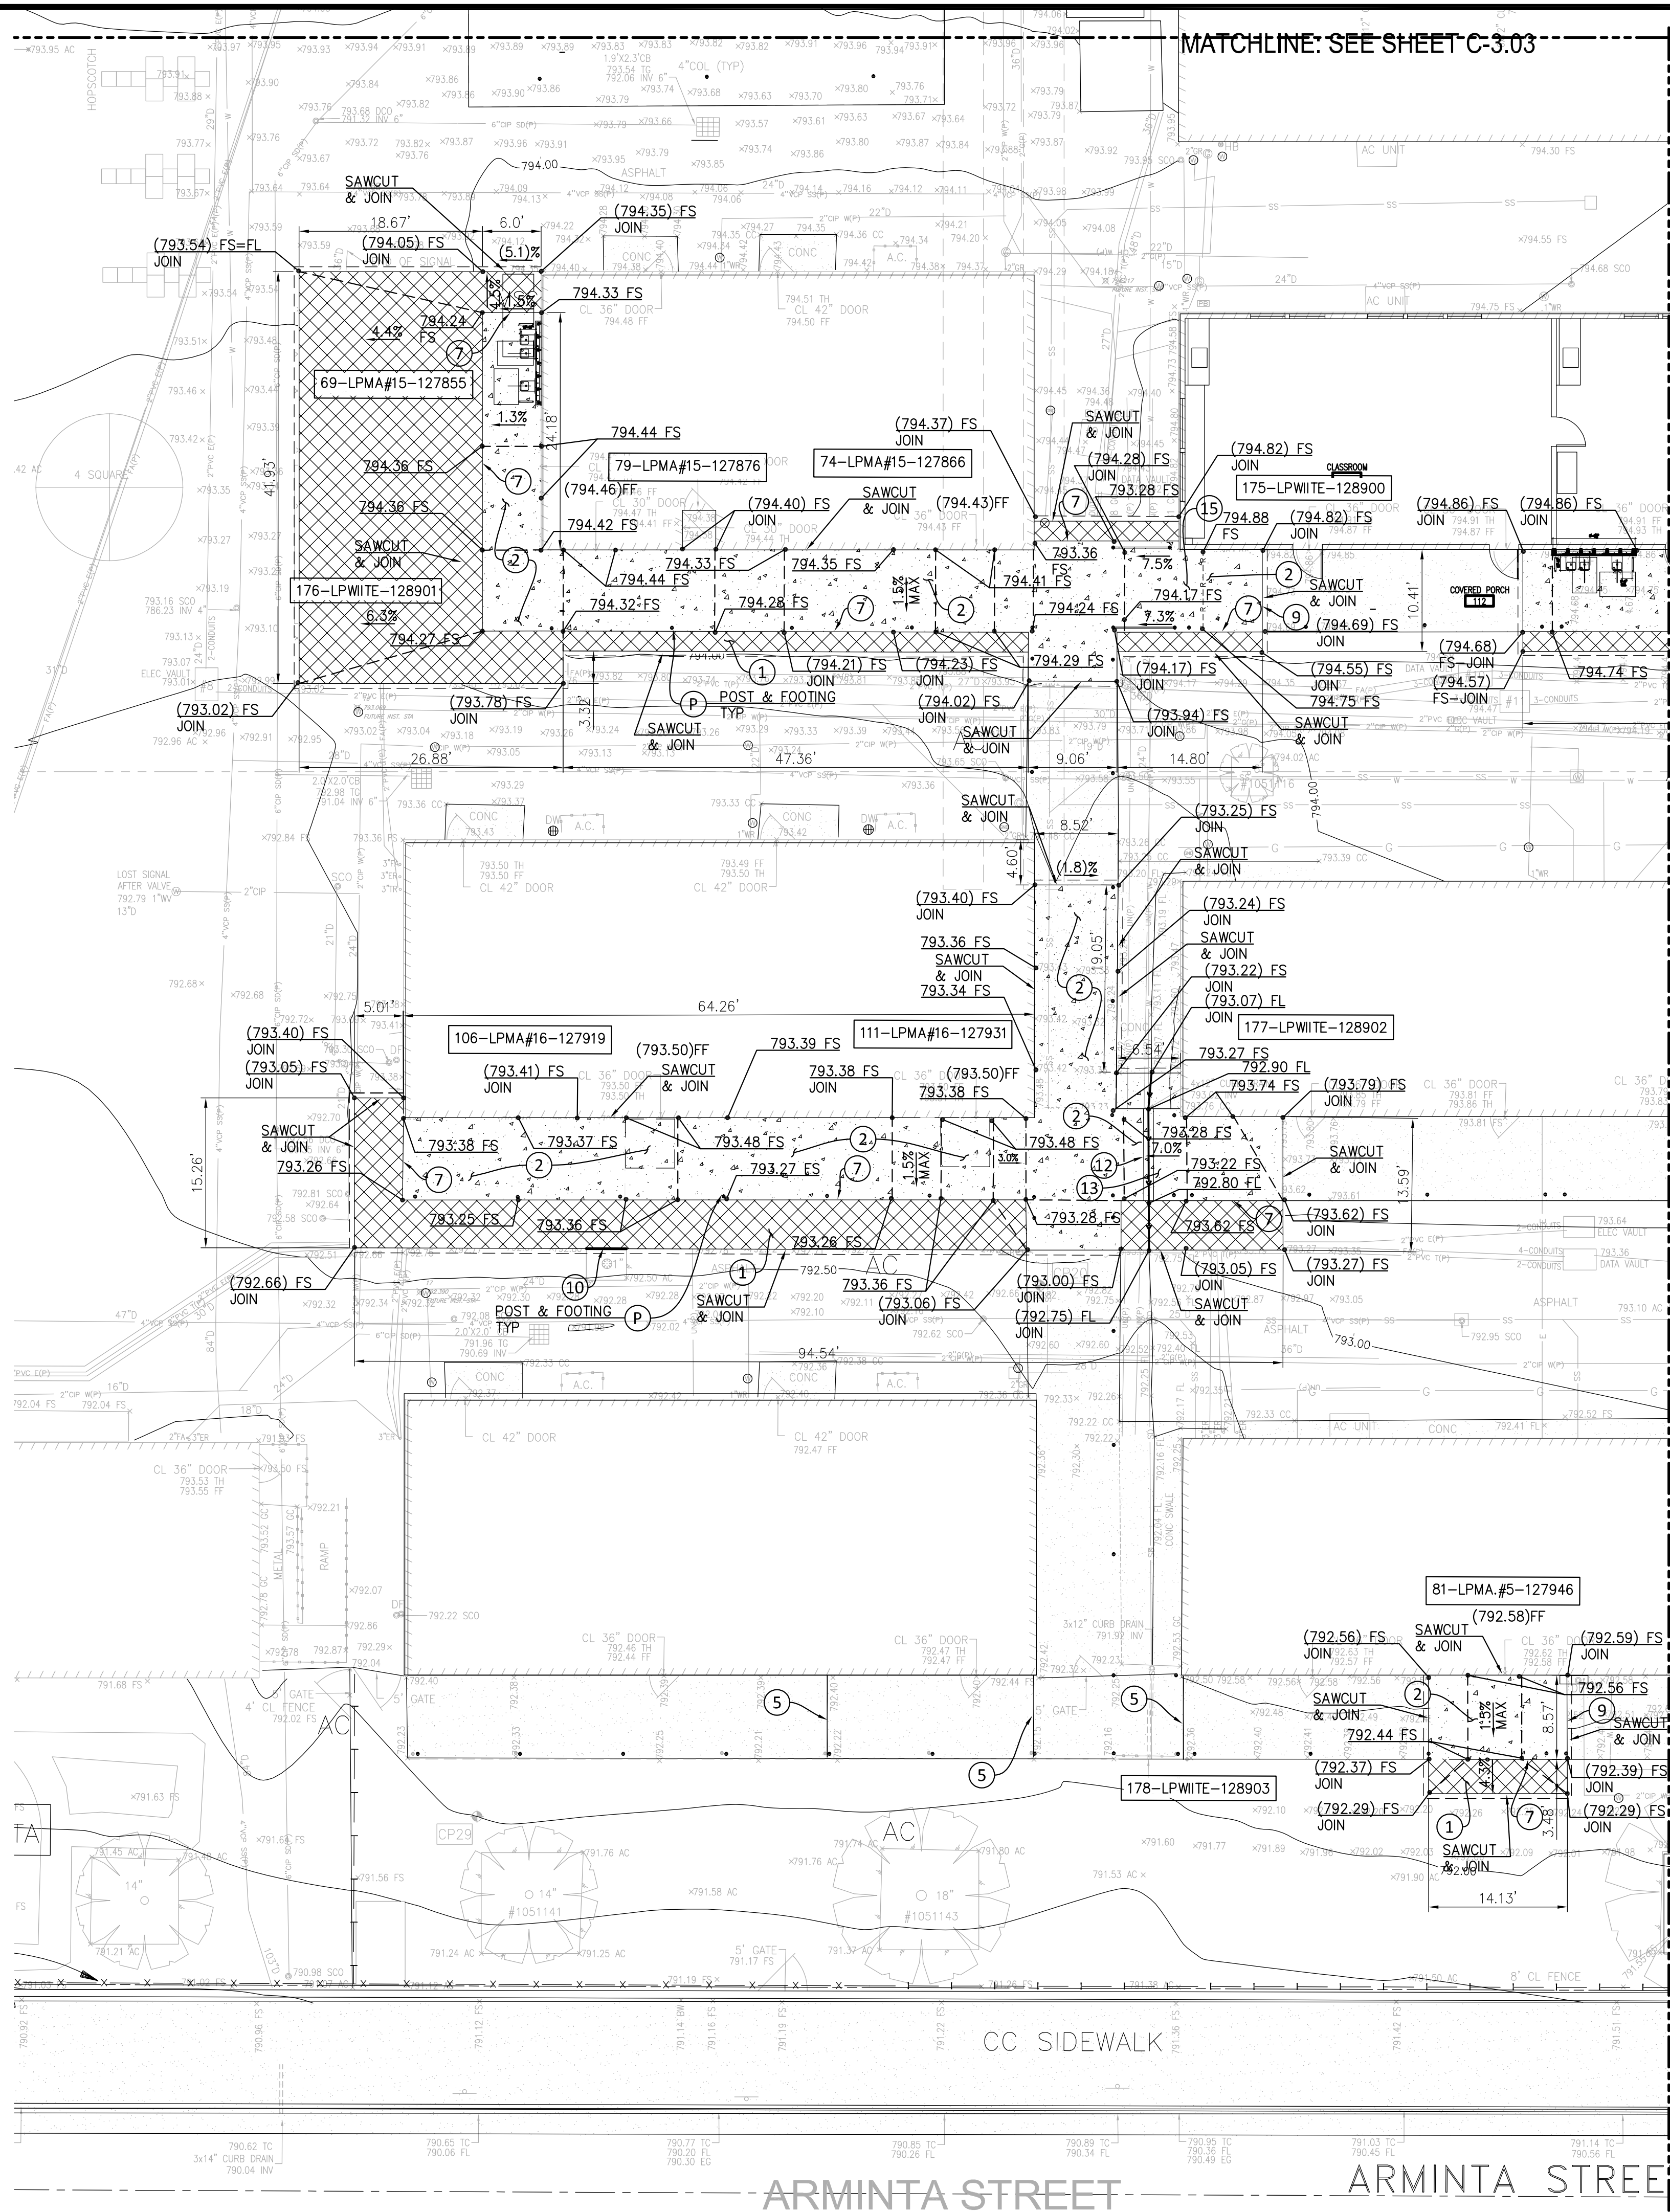

CONSTRUCTION NOTES:


- ① ASPHALT CONCRETE PAVEMENT PER DETAIL 1 C-5.01
- ② CONCRETE PAVEMENT PER DETAIL 2 C-5.01
- ⑤ EXPANSION JOINT FILLER PER DETAIL 3 C-5.01 TYPE A
- ⑦ THICKENED EDGE PER DETAIL 7 C-5.01 SEE GENERAL NOTE 2 HEREON
- ⑨ DOWEL #4 REBARS @ 18" O.C. PER DETAIL 3 C-5.01 TYPE A ALTERNATIVE
- ⑩ REDWOOD HEADER PER DETAIL 4 C-5.01
- ⑫ 3"x12.5" RECTANGULAR CAST IRON PIPE BENEATH RAMP
- ⑬ CONCRETE RAMP. SEE ARCHITECTURAL PLAN A-2.06 FOR DETAILS
- ⑮ CONCRETE RAMP. SEE ARCHITECTURAL PLAN A-2.07 FOR DETAILS
- P PROTECT IN PLACE

LEGEND:

- ASPHALT CONCRETE PAVEMENT TYPE PER PLAN 1 C-5.01
- PORTLAND CONCRETE PAVEMENT TYPE PER PLAN 2 C-5.01
- LIMIT OF WORK
- SAWCUT AND JOIN LINE
- GRADE BREAK
- RIDGE LINE
- FLOW LINE

GENERAL NOTES:

1. EXPANSION JOINTS SHALL BE CONSTRUCTED 20' FEET APART PER PROJECT SPECIFICATIONS. CONTRACTION JOINTS SHALL BE CONSTRUCTED AT INTERVALS OF 4' MINIMUM ON WALKWAYS/EXTERIOR SLABS.
2. THICKENED EDGE SHALL BE CONSTRUCTED ALONG ALL OUTER EDGES OF CONCRETE PAVEMENT.
3. SEE DETAIL 8/C5.01 WHERE NEW PAVEMENT JOINS EXISTING ASPHALT PAVEMENT.
4. WHERE NEW PAVEMENTS ABUTS AGAINST AN EXISTING BUILDING, PROVIDE A MINIMUM OF 1.00% POSITIVE SLOPE AWAY FROM THE BUILDING.
5. WHERE NEW PAVEMENT ABUTS AGAINST AN EXISTING DOOR LANDING, SEE ARCHITECTURAL PLAN DETAIL 2/ACS-8.00.

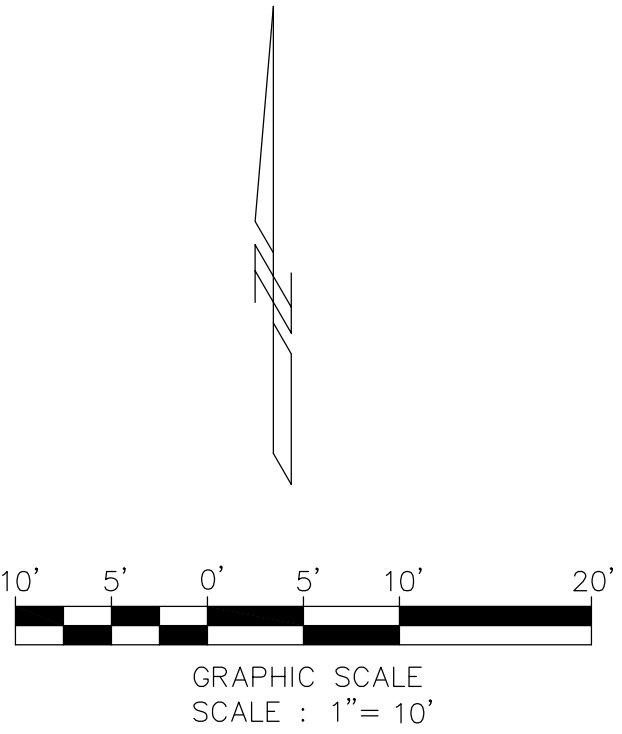

LOS ANGELES UNIFIED SCHOOL DISTRICT
BOARD OF EDUCATION

**LOS ANGELES UNIFIED
SCHOOL DISTRICT
ASSET MANAGEMENT
FACILITIES SERVICES DIVISION**

333 S. BEAUDRY AVENUE, 23RD FLOOR
LOS ANGELES, CALIFORNIA 90017

PROJECT TITLE AND SCHOOL LOCATION
**STRATHERN STREET
SCHOOL
VOLUNTARY BARRIER
REMOVAL**
7939 ST. CLAIRE AVENUE
N. HOLLYWOOD, CA 91605
COLIN ID No.: 10373687


DSA# 03-125645

COMMISSIONED ARCHITECT
MLA
ML ARCHITECTURE
355 PASADENA AVENUE
SOUTH PASADENA, CA 91030

STAMPS/SEALS

CONSULTANT
MOLLENHAUER GROUP
CIVIL ENGINEERING
SURVEYING+MAPPING
LAND DEVELOPMENT
213 624 2661 TEL
919 W. GLENDALE BLVD.,
2ND FLOOR
GLENDALE, CALIFORNIA
91202

STAMPS/SEALS

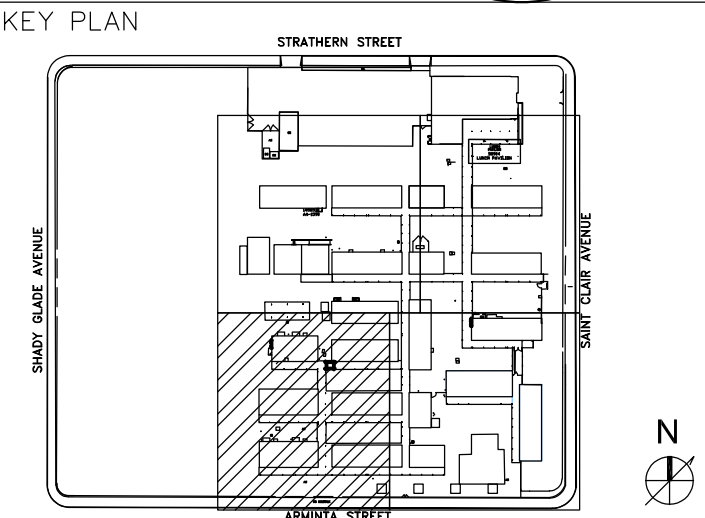

ADDENDUM 1 06/02/26


SHEET TITLE:

**GRADING PLAN
SOUTH**

PROJECT NO.: 23004 PROJECT ARCH: ML ARCHITECTURE
DRAWN: MK CHECKED: TT
SHEET NUMBER

C-3.04


DATE: 10-24-2025 SHEET: OF:

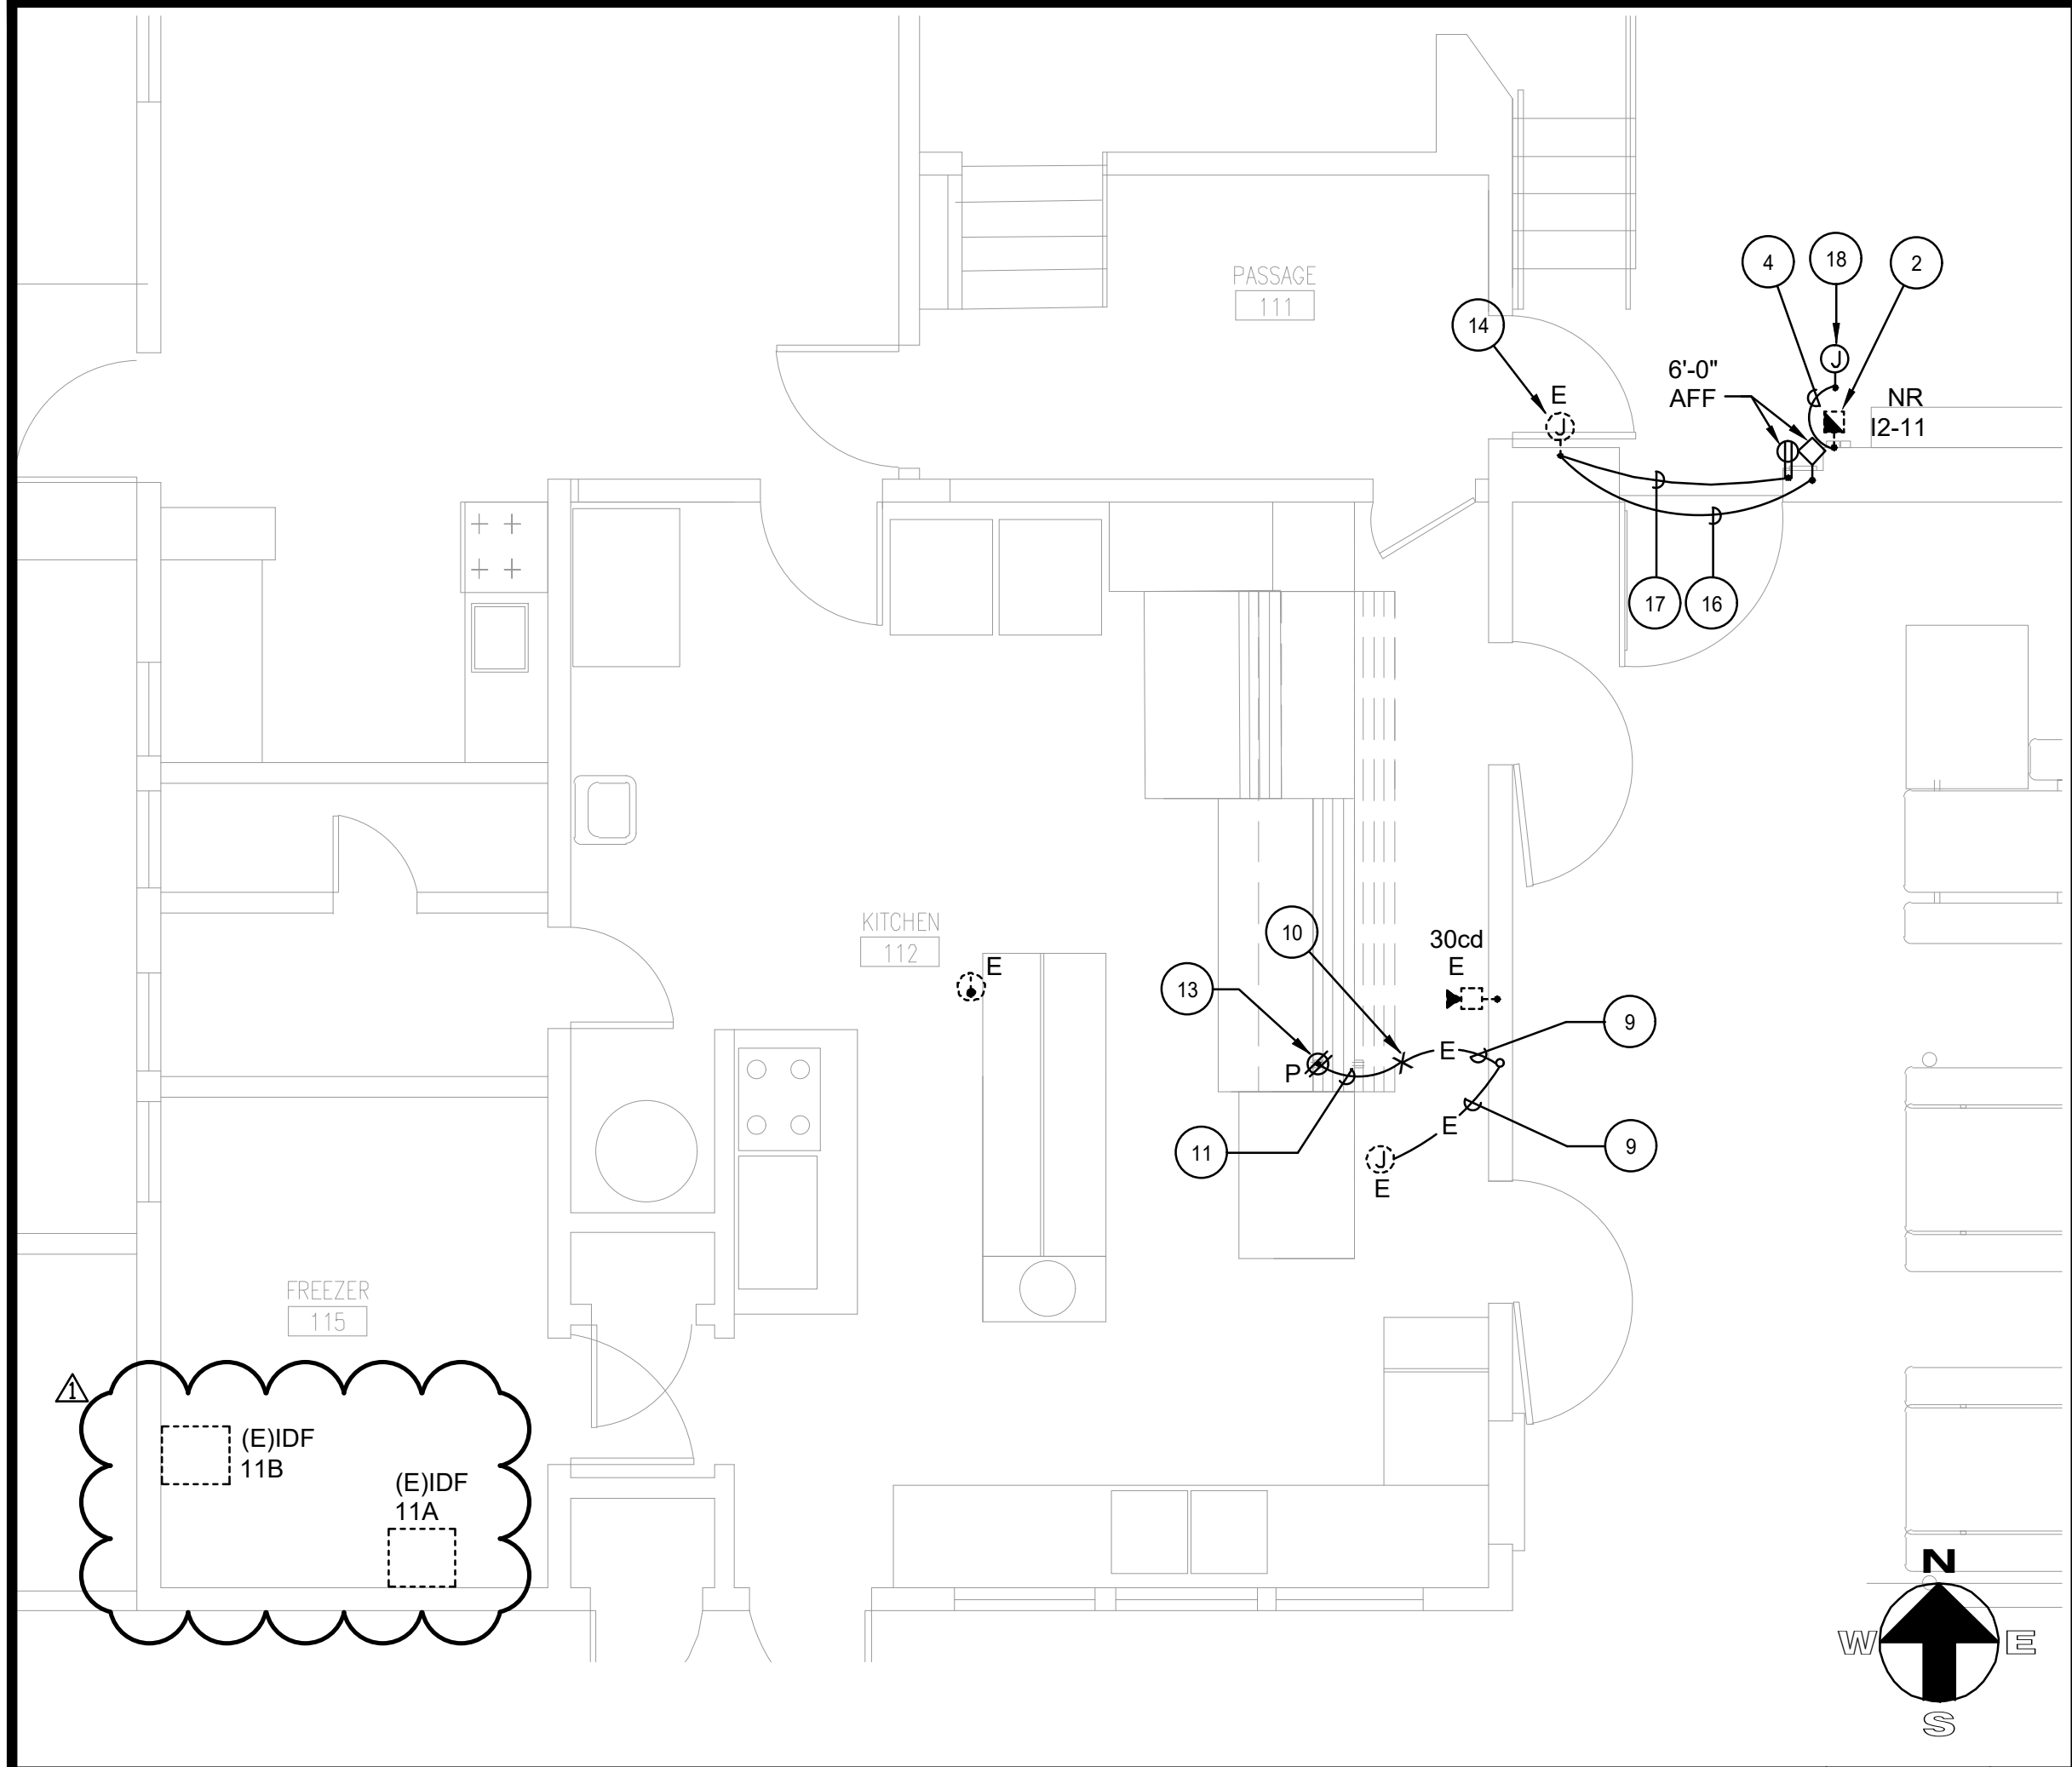

ELECTRICAL PLAN - KITCHEN 112 - BUILDING #13

SCALE:
1/4"=1'-0"


6

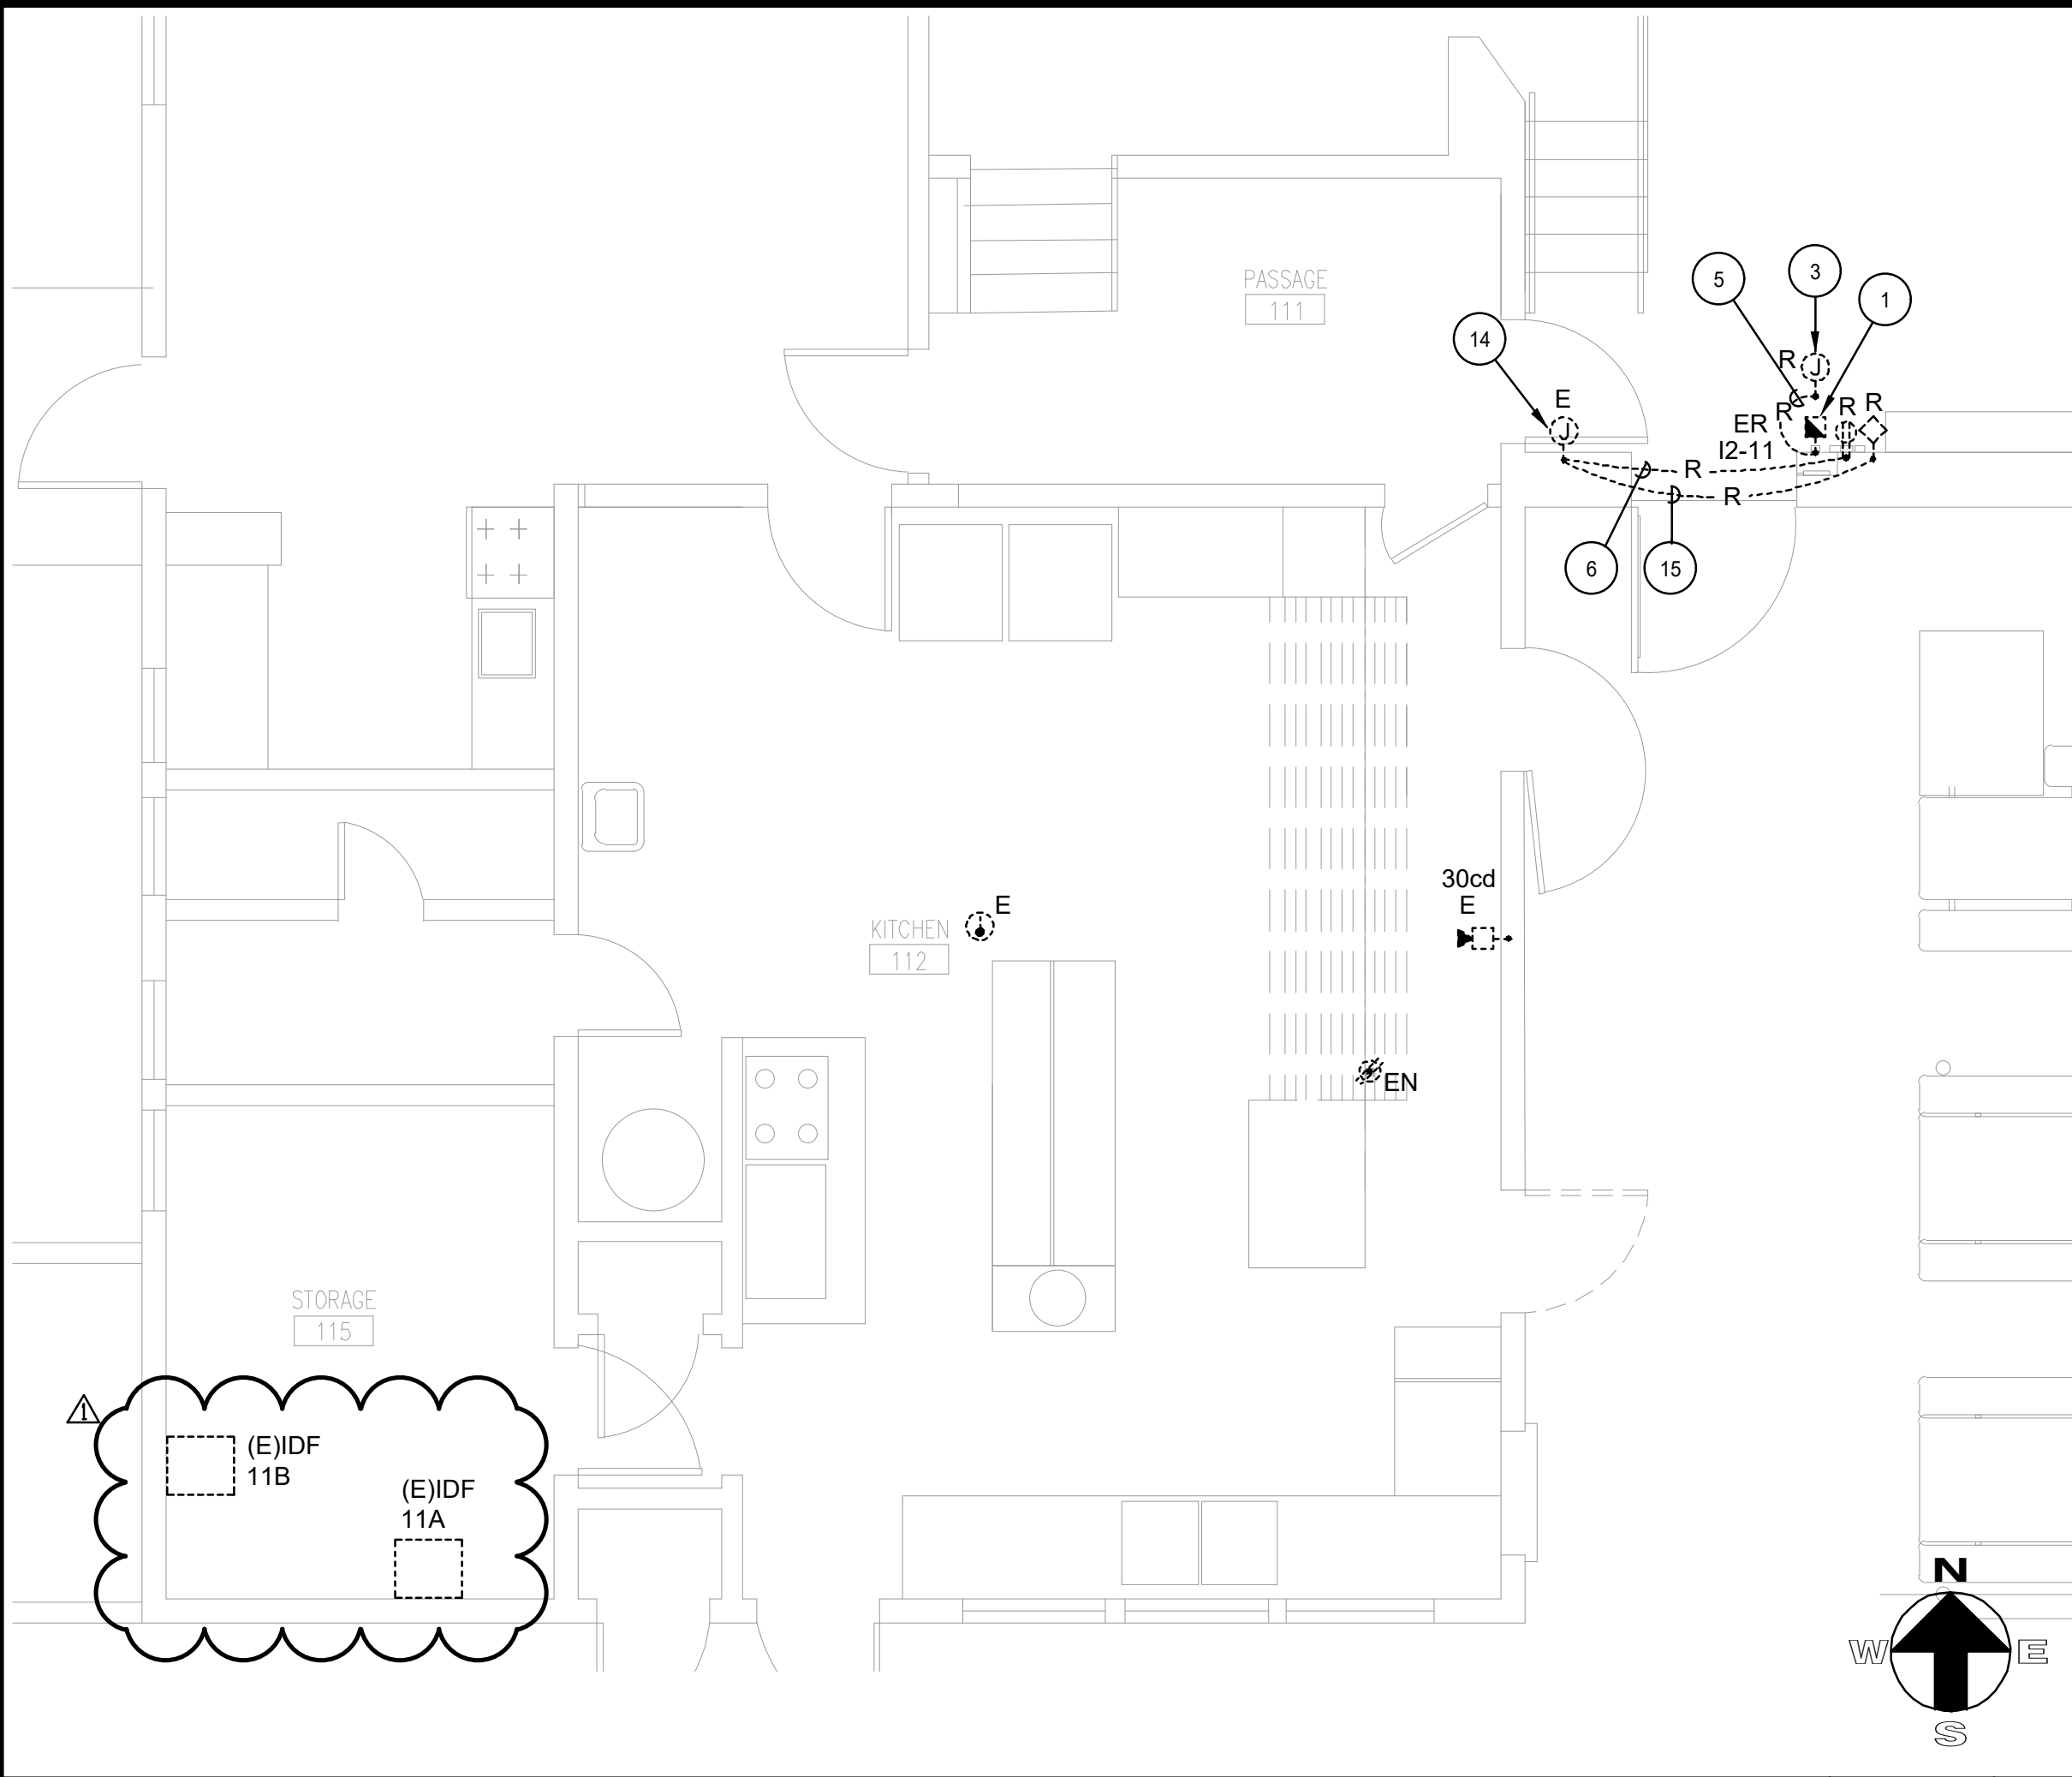

DEMO ELECTRICAL PLAN - KITCHEN 112 - BUILDING #13

SCALE:
1/4"=1'-0"


5

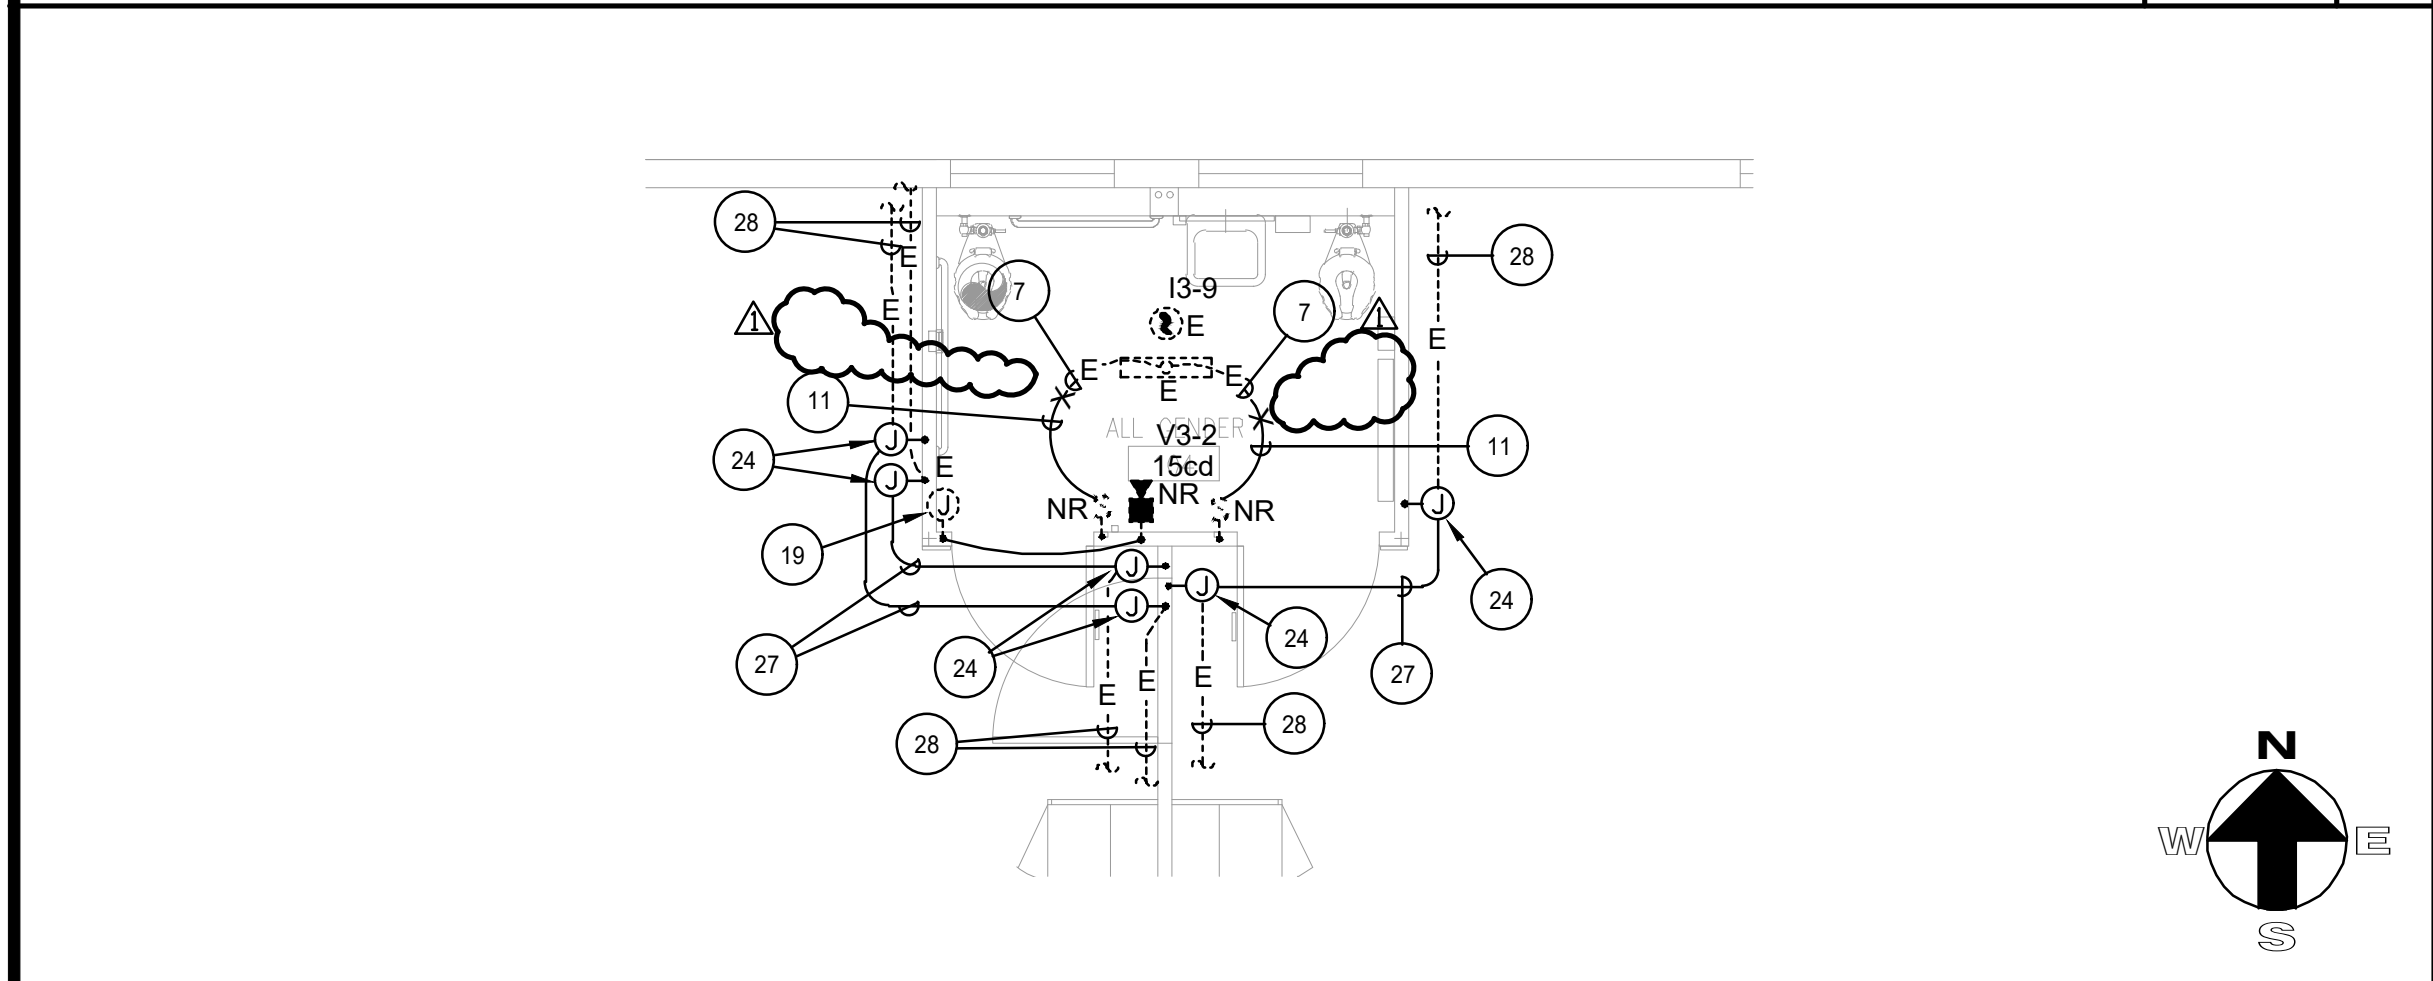

ELECTRICAL PLAN - ALL GENDER 104 - KINDERGARTEN #14

SCALE:
1/4"=1'-0"


4

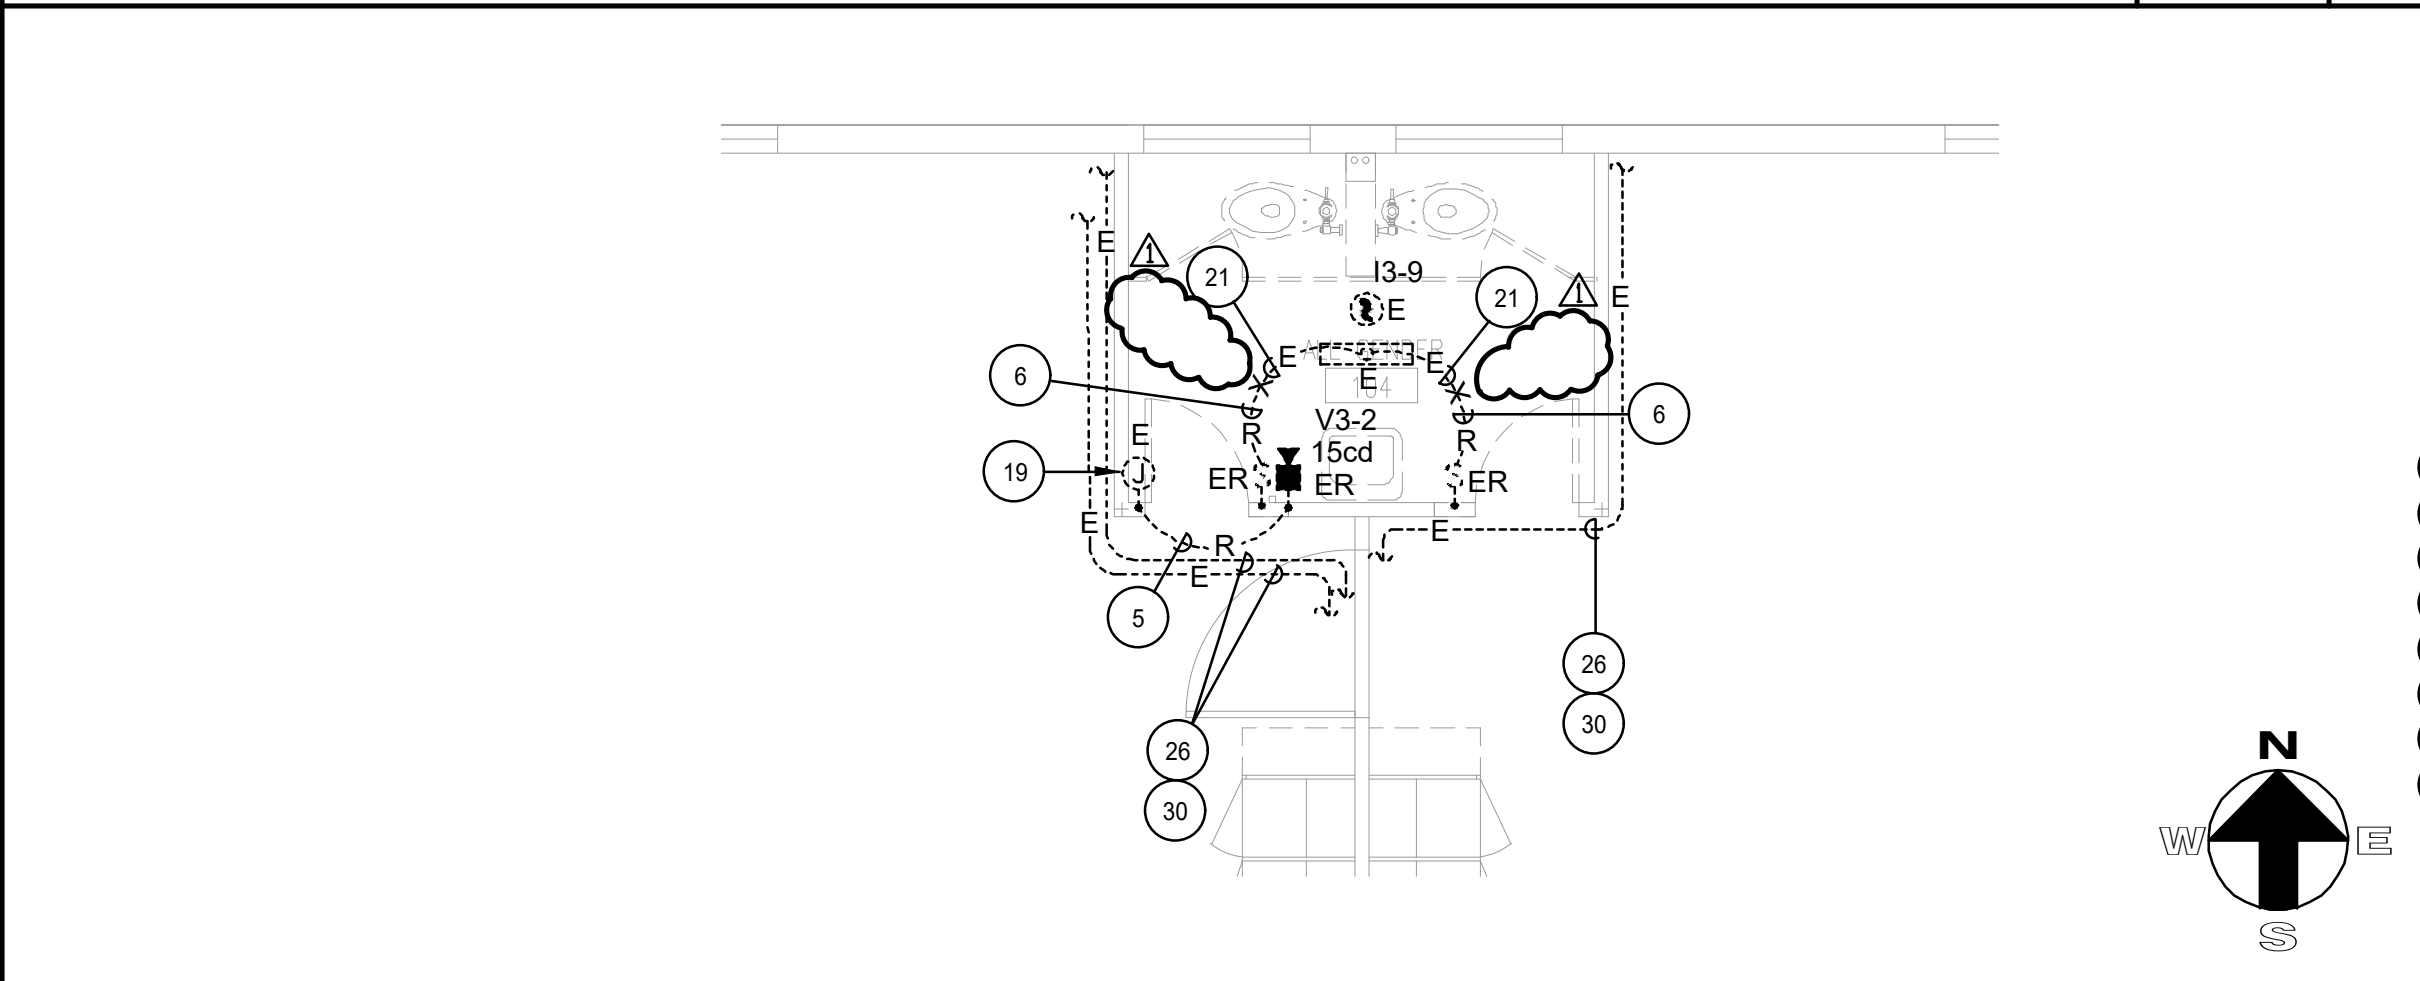

DEMO ELECTRICAL PLAN - ALL GENDER 104 - KINDERGARTEN #14

SCALE:
1/4"=1'-0"


3

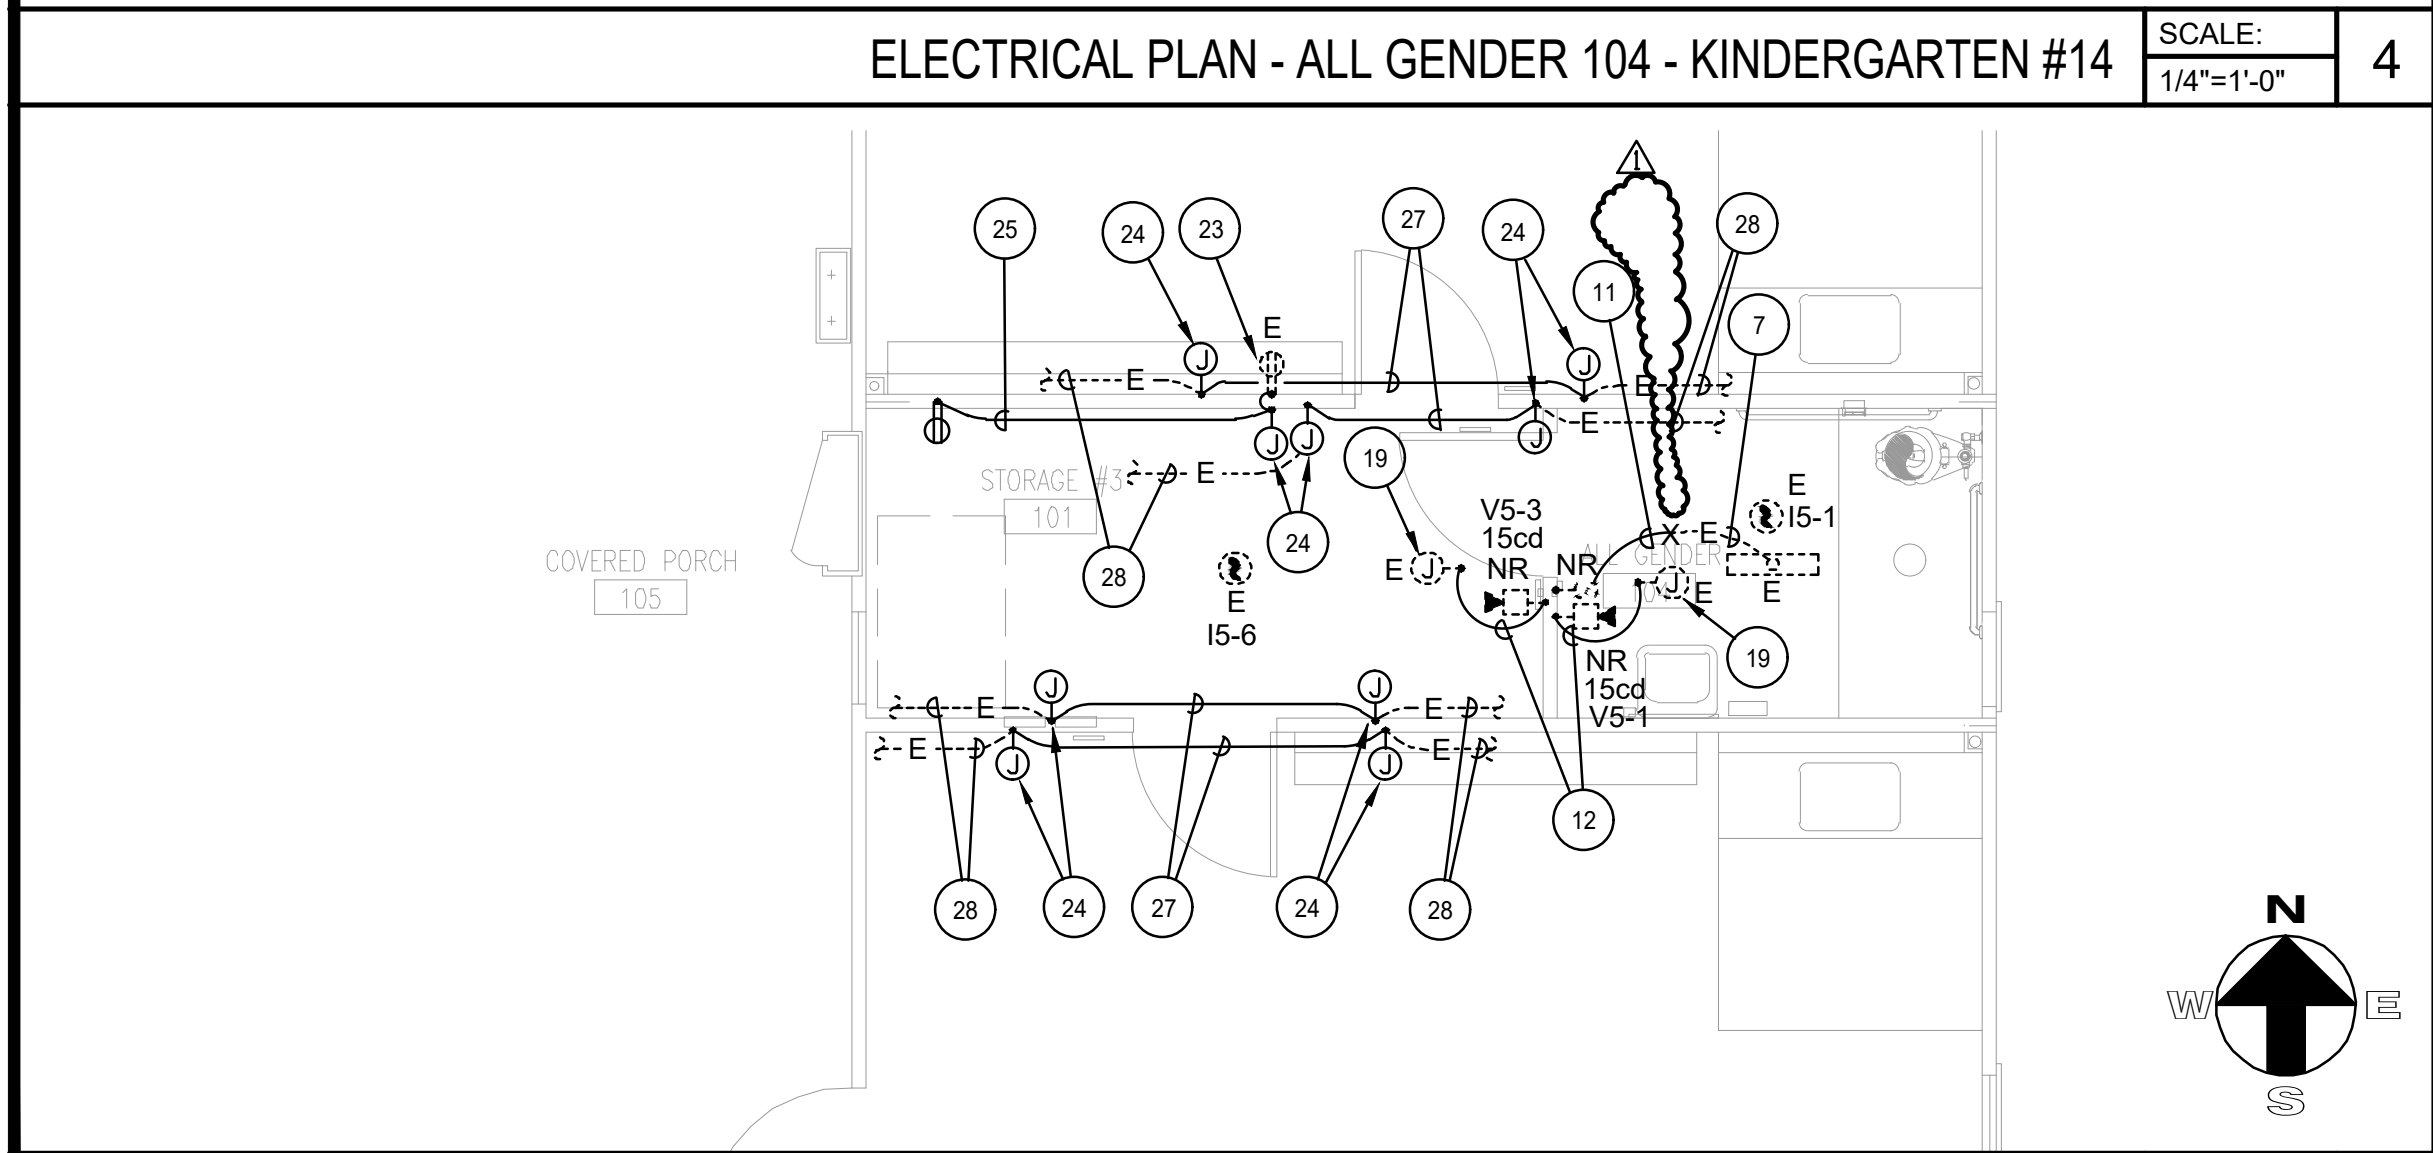

ELECTRICAL PLAN - ALL GENDER 104 - KINDERGARTEN #4

SCALE:
1/4"=1'-0"

2

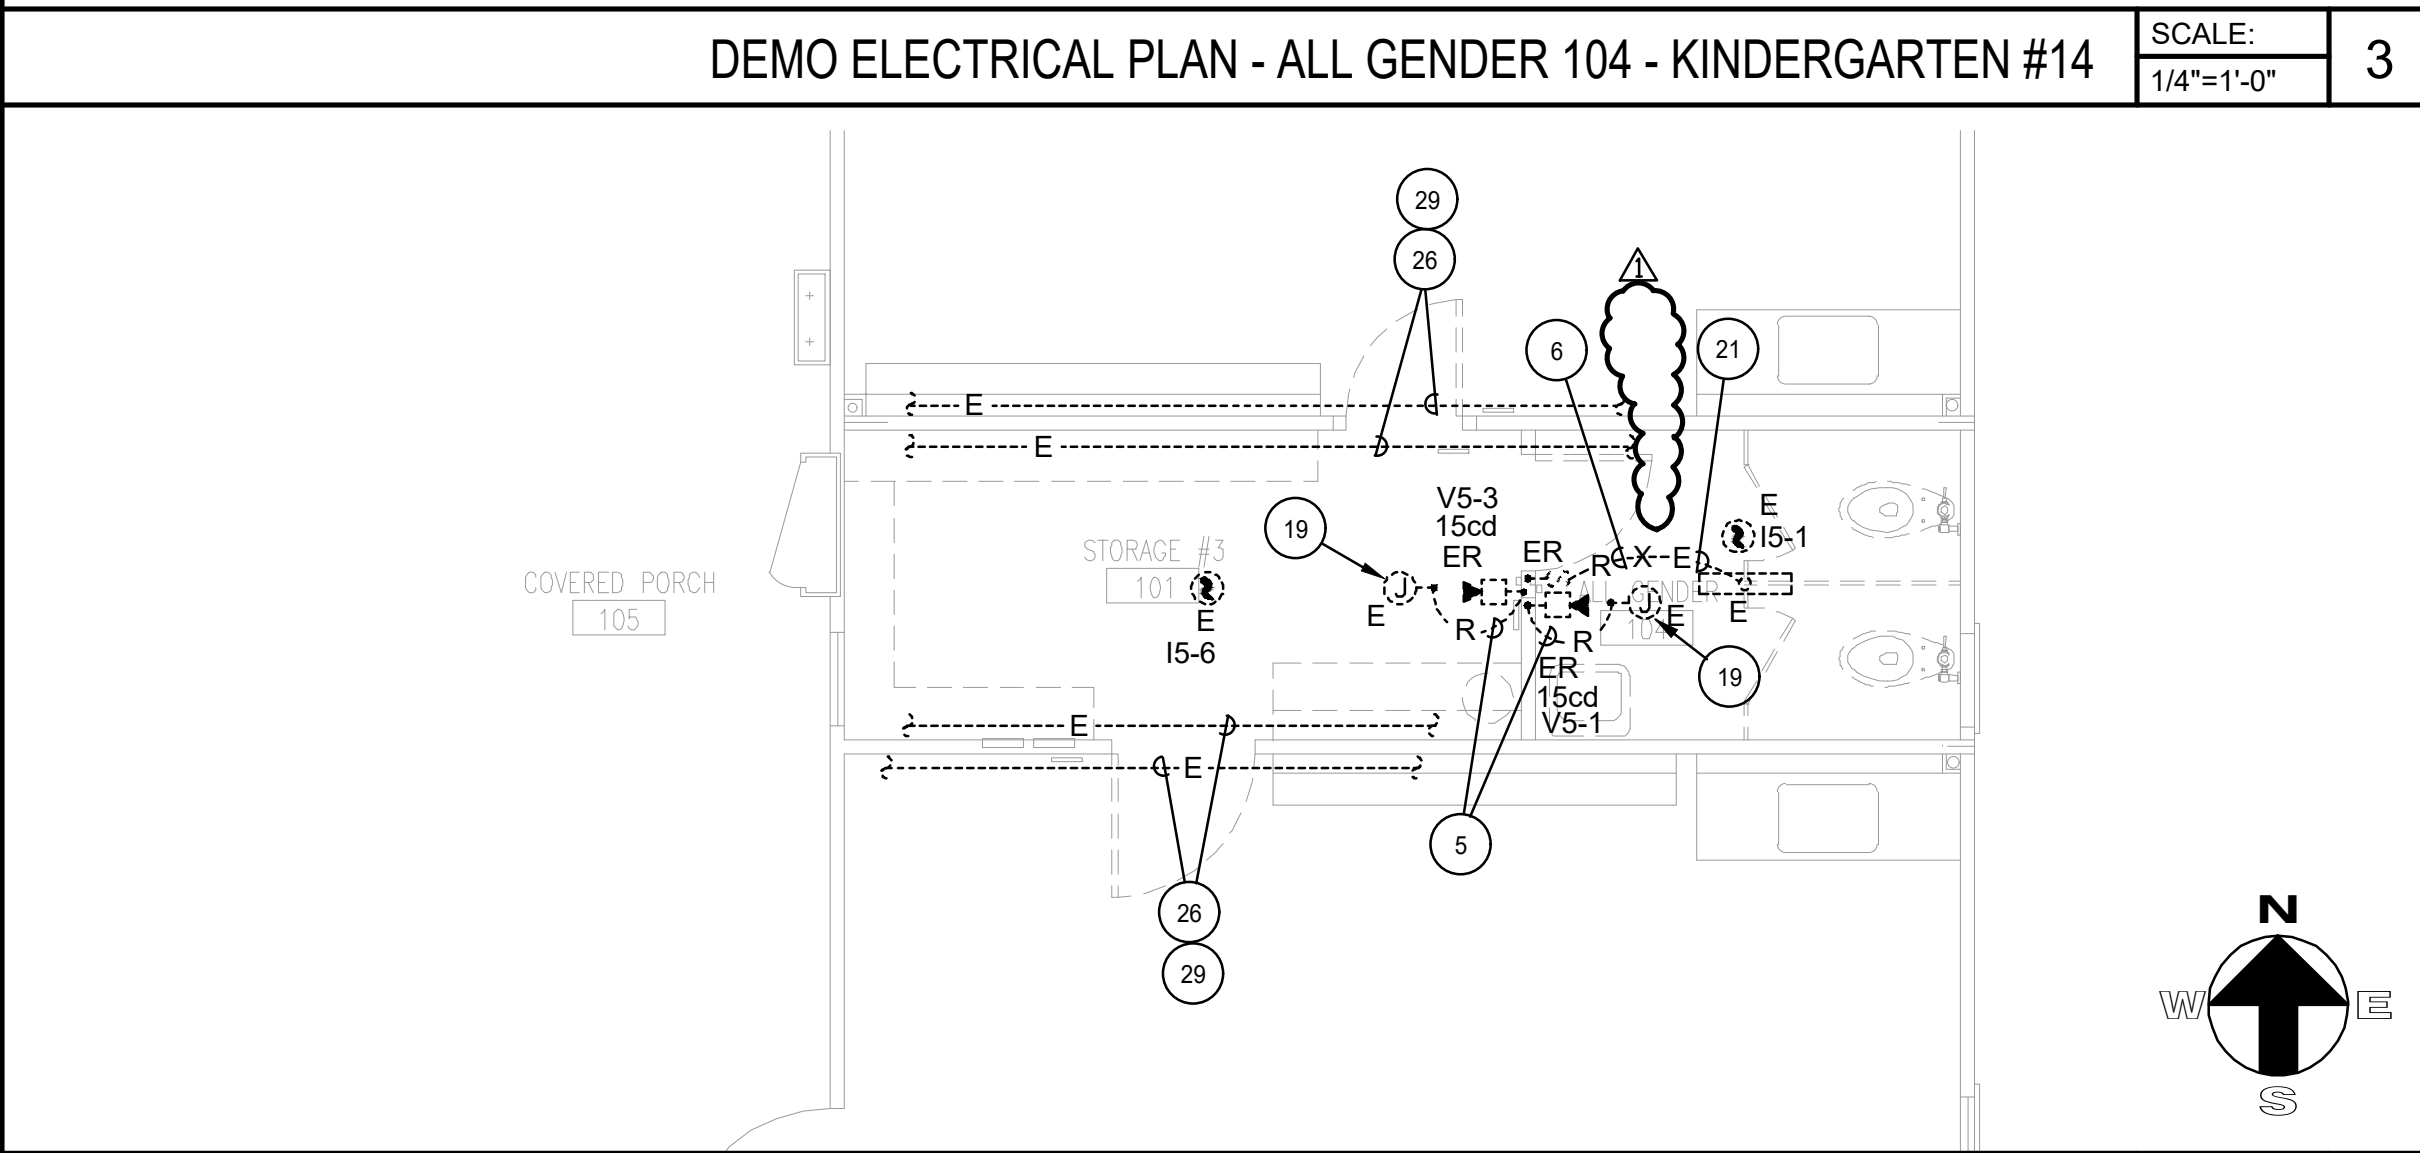

DEMO ELECTRICAL PLAN - ALL GENDER 104 - KINDERGARTEN #4

SCALE:
1/4"=1'-0"

1

PLAN NOTES


- RELOCATE EXISTING FIRE ALARM PULL STATION A#03-110125. REFER TO DETAIL #1 ON THIS SHEET FOR ADDITIONAL INFORMATION.
- NEWLY RELOCATED EXISTING PULLSTATION. CONNECT TO EXISTING INITIATING CIRCUIT AS INDICATED.
- REMOVE EXISTING FIRE ALARM WALL MOUNTED J-BOX AT THE CEILING AND REPLACE WITH NEW J-BOX AS INDICATED ON DETAIL #6 ON THIS SHEET.
- PROVIDE 2#16 TP IN NEW WIREMOLD 700 SERIES.
- REMOVE EXISTING WIREMODL AND CABLING.
- REMOVE EXISTING 3/4"C. & 2#12 WIRING & 1#12 GRD.
- PROVIDE 2#12, 1#12 GRD. IN EXISTING CONDUIT.
- PROVIDE 4#12 NOTIFICATION IN NEW WIREMOLD 700 SERIES.
- REMOVE EXISTING WIRING IN EXISTING CONDUIT AND REPLACE WITH NEW 2#12, 1#12 GRD.
- INTERCEPT EXISTING CONDUIT AND EXTEND WITH NEW CONDUIT AND WIRING AS INDICATED.
- PROVIDE 2#12, 1#12 GRD. - 3/4"C.
- PROVIDE 2#16 TP AND 4#12 NOTIFICATION IN NEW WIREMOLD 700 SERIES.
- THE CONTRACTOR SHALL TRACE THE EXISTING CIRCUIT NUMBER AND INDICATE IT ON THE AS-BUILT PLAN.
- EXISTING WALL MOUNTED TWO COMPARTMENT J-BOX TO REMAIN.
- REMOVE EXISTING CONDUIT AND CAT 6 CABLE AND REPLACE WITH NEW CAT 6 IN THE ENTIRE LENGTH FROM THE DEVICE TO THE EXISTING IDF RACK IN THE BUILDING.
- PROVIDE 1/2"C. WITH CAT 6 CABLE.
- PROVIDE 2#12, 1#12 GRD. - 1/2"C.
- PROVIDE WALL MOUNTED J-BOX AT THE CEILING, INTERCEPT EXISTING INITIATING CIRCUIT AND EXTEND WITH NEW WIREMOLD AND CABLING AS INDICATED.
- EXISTING FIRE ALARM JUNCTION BOX PER A#03-110125 TO REMAIN.
- REFER TO DETAIL #1 ON THIS SHEET FOR ADDITIONAL INFORMATION.
- REMOVE ALL WIRING IN EXISTING CONDUIT.
- INTERCEPT EXISTING CONDUIT AND EXTEND WITH NEW CONDUIT AND WIRING AS INDICATED.
- INTERCEPT EXISTING 120V CIRCUIT IN THE EXISTING RECEPTACLE AND EXTEND WITH NEW WIREMOLD AND WIRING AS INDICATED.
- PROVIDE SURFACE MOUNT JUNCTION BOX.
- PROVIDE 2#12, 1#12 GRD. - IN NEW WIREMOLD 700 SERIES.
- EXISTING WIREMOLD ABOVE DOOR/FRAME CONTAINING CABLING SHALL BE REMOVED AND REPLACED AS REQUIRED FOR CONSTRUCTION. CONTRACTOR SHALL TEMPORARILY SUPPORT AND PROTECT EXISTING CABLING ON CEILING DURING CONSTRUCTION AND REINSTALL IN NEW WIREMOLD UPON COMPLETION. IF ANY CABLING IS DISCONNECTED FROM DEVICES, CONTRACTOR SHALL RECONNECT, TEST, AND VERIFY SYSTEM OPERATIONAL. CONTRACTOR MUST VISIT SITE PRIOR TO BID TO VERIFY CONDITIONS AND INCLUDE ALL COSTS IN BID.
- PROVIDE NEW WIREMOLD MATCHING THE EXISTING REMOVED.
- EXISTING WIREMOLD TO REMAIN.
- REFER TO DETAIL #2 ON THIS SHEET FOR WIREMOLD LENGTH TO BE REPLACE.
- REFER TO DETAIL #4 ON THIS SHEET FOR WIREMOLD LENGTH TO BE REPLACE.

GENERAL NOTES:

- CONTRACTOR SHALL TEST ALL EXISTING FIRE ALARM DEVICES AFFECTED BY THE SCOPE OF WORK SHOWN ON THIS SHEET PRIOR TO REMOVAL TO VERIFY PROPER OPERATION. AFTER REINSTALLATION, CONTRACTOR SHALL RETEST DEVICES TO CONFIRM PROPER OPERATION AND INTEGRATION WITH THE FIRE ALARM SYSTEM.
- CONTRACTOR SHALL FIELD-VERIFY AND TRACE ALL EXISTING CIRCUITS AFFECTED BY THE SCOPE OF WORK SHOWN ON THIS SHEET PRIOR TO THE START OF CONSTRUCTION. UPON COMPLETION OF THE WORK, CONTRACTOR SHALL ACCURATELY RECORD ALL CIRCUITS ON THE AS-BUILT DRAWINGS.

LEGEND:

- E EXISTING EQUIPMENT OR DEVICE TO REMAIN. CONTRACTOR SHALL RECONNECT TO EXISTING CIRCUIT IF DISCONNECTED BY DEMOLITION ON THIS PROJECT.
- R EXISTING EQUIPMENT OR DEVICE TO BE REMOVED. CONTRACTOR SHALL DISCONNECT AND REMOVE ALL ASSOCIATED CONTROLS, CONDUCTORS, AND CONDUIT AS REQUIRED.
- ER EXISTING EQUIPMENT OR DEVICE TO BE DISCONNECTED AND RELOCATED AS INDICATED ON PLANS.
- EN EXISTING EQUIPMENT OR DEVICE TO BE REMOVED AND REPLACED WITH NEW AS INDICATED ON PLANS.
- NR NEWLY RELOCATED EXISTING EQUIPMENT OR DEVICE AT LOCATION INDICATED ON PLANS.
- #16cd--- candela rating
- #12cd--- EXISTING VISUAL DEVICE PER A#03-110125 TO REMAIN.
- #12cd--- device number
- #12cd--- notification device circuit number
- #16cd--- candela rating
- #12cd--- EXISTING AUDIO/VISUAL DEVICE PER A#03-110125 TO REMAIN.
- #12cd--- device number
- #12cd--- notification device circuit number
- #12cd--- EXISTING SMOKE DETECTOR PER A#03-110125 TO REMAIN.
- #12cd--- device number
- #12cd--- loop number
- #12cd--- EXISTING HEAT DETECTOR PER A#03-110125 TO REMAIN.
- #12cd--- device number
- #12cd--- loop number
- #12cd--- EXISTING PULL STATION PER A#03-110125 TO REMAIN.
- #12cd--- device number
- #12cd--- loop number

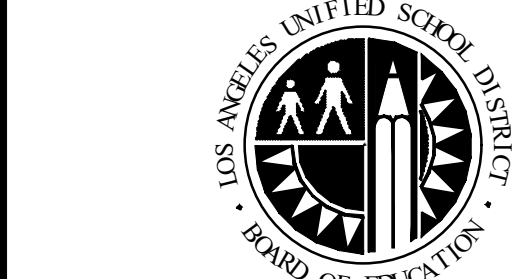

LOS ANGELES UNIFIED SCHOOL DISTRICT ASSET MANAGEMENT FACILITIES SERVICES DIVISION

333 S. BEAUDRY AVENUE, 23RD FLOOR
LOS ANGELES, CALIFORNIA 90017

PROJECT TITLE AND SCHOOL LOCATION

STRATHEN STREET
SCHOOL
VOLUNTARY BARRIER
REMOVAL

7939 ST. CLAIRE AVENUE.
N. HOLLYWOOD, CA 91605
COLIN ID No.: 10373687


DSA# 03-125645

COMMISSIONED ARCHITECT



ML ARCHITECTURE
355 PASADENA AVENUE
SOUTH PASADENA, CA91030

STAMPS/SEALS

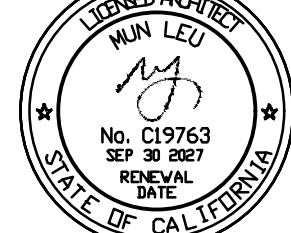


CONSULTANT

FBA Engineering


Consulting Electrical Engineers
150 Paulinho Avenue Suite A120
Costa Mesa, CA 92626
949.852.9995 • 949.852.1057 (fax)
fbengr.com

STAMPS/SEALS

FBA Job Number: 1137 056

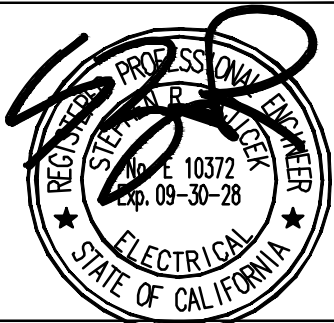

KEY PLAN

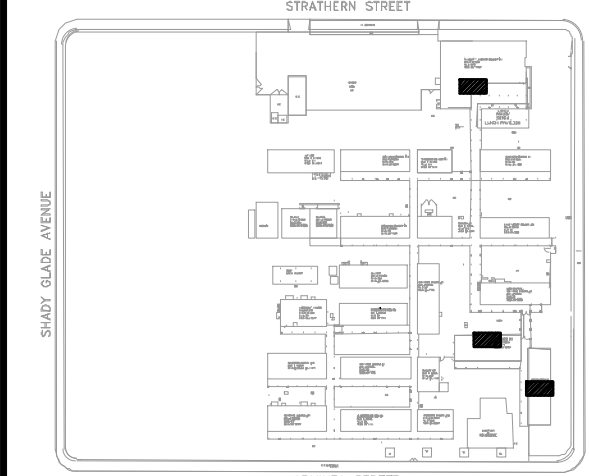

ADDENDUM 1 06/02/26

SHEET TITLE:

ENLARGED ELECTRICAL PLANS

PROJECT NO.: 23004 PROJECT ARCH: ML ARCHITECTURE

DRAWN: T PHAN CHECKED: MUN LEU



SHEET NUMBER

E-2.01

DATE: 10-24-2025

SHEET: OF:



FBA Engineering / Plot Date: 5/4/2026 1:33 PM / Plotted by: Brandon Nguyen / Drawing Location: L:\1137056\E-2.02 - 1137 056 ENLARGED ELECTRICAL PLANS.dwg

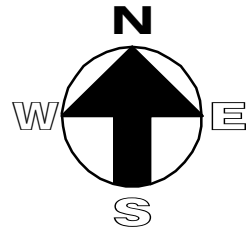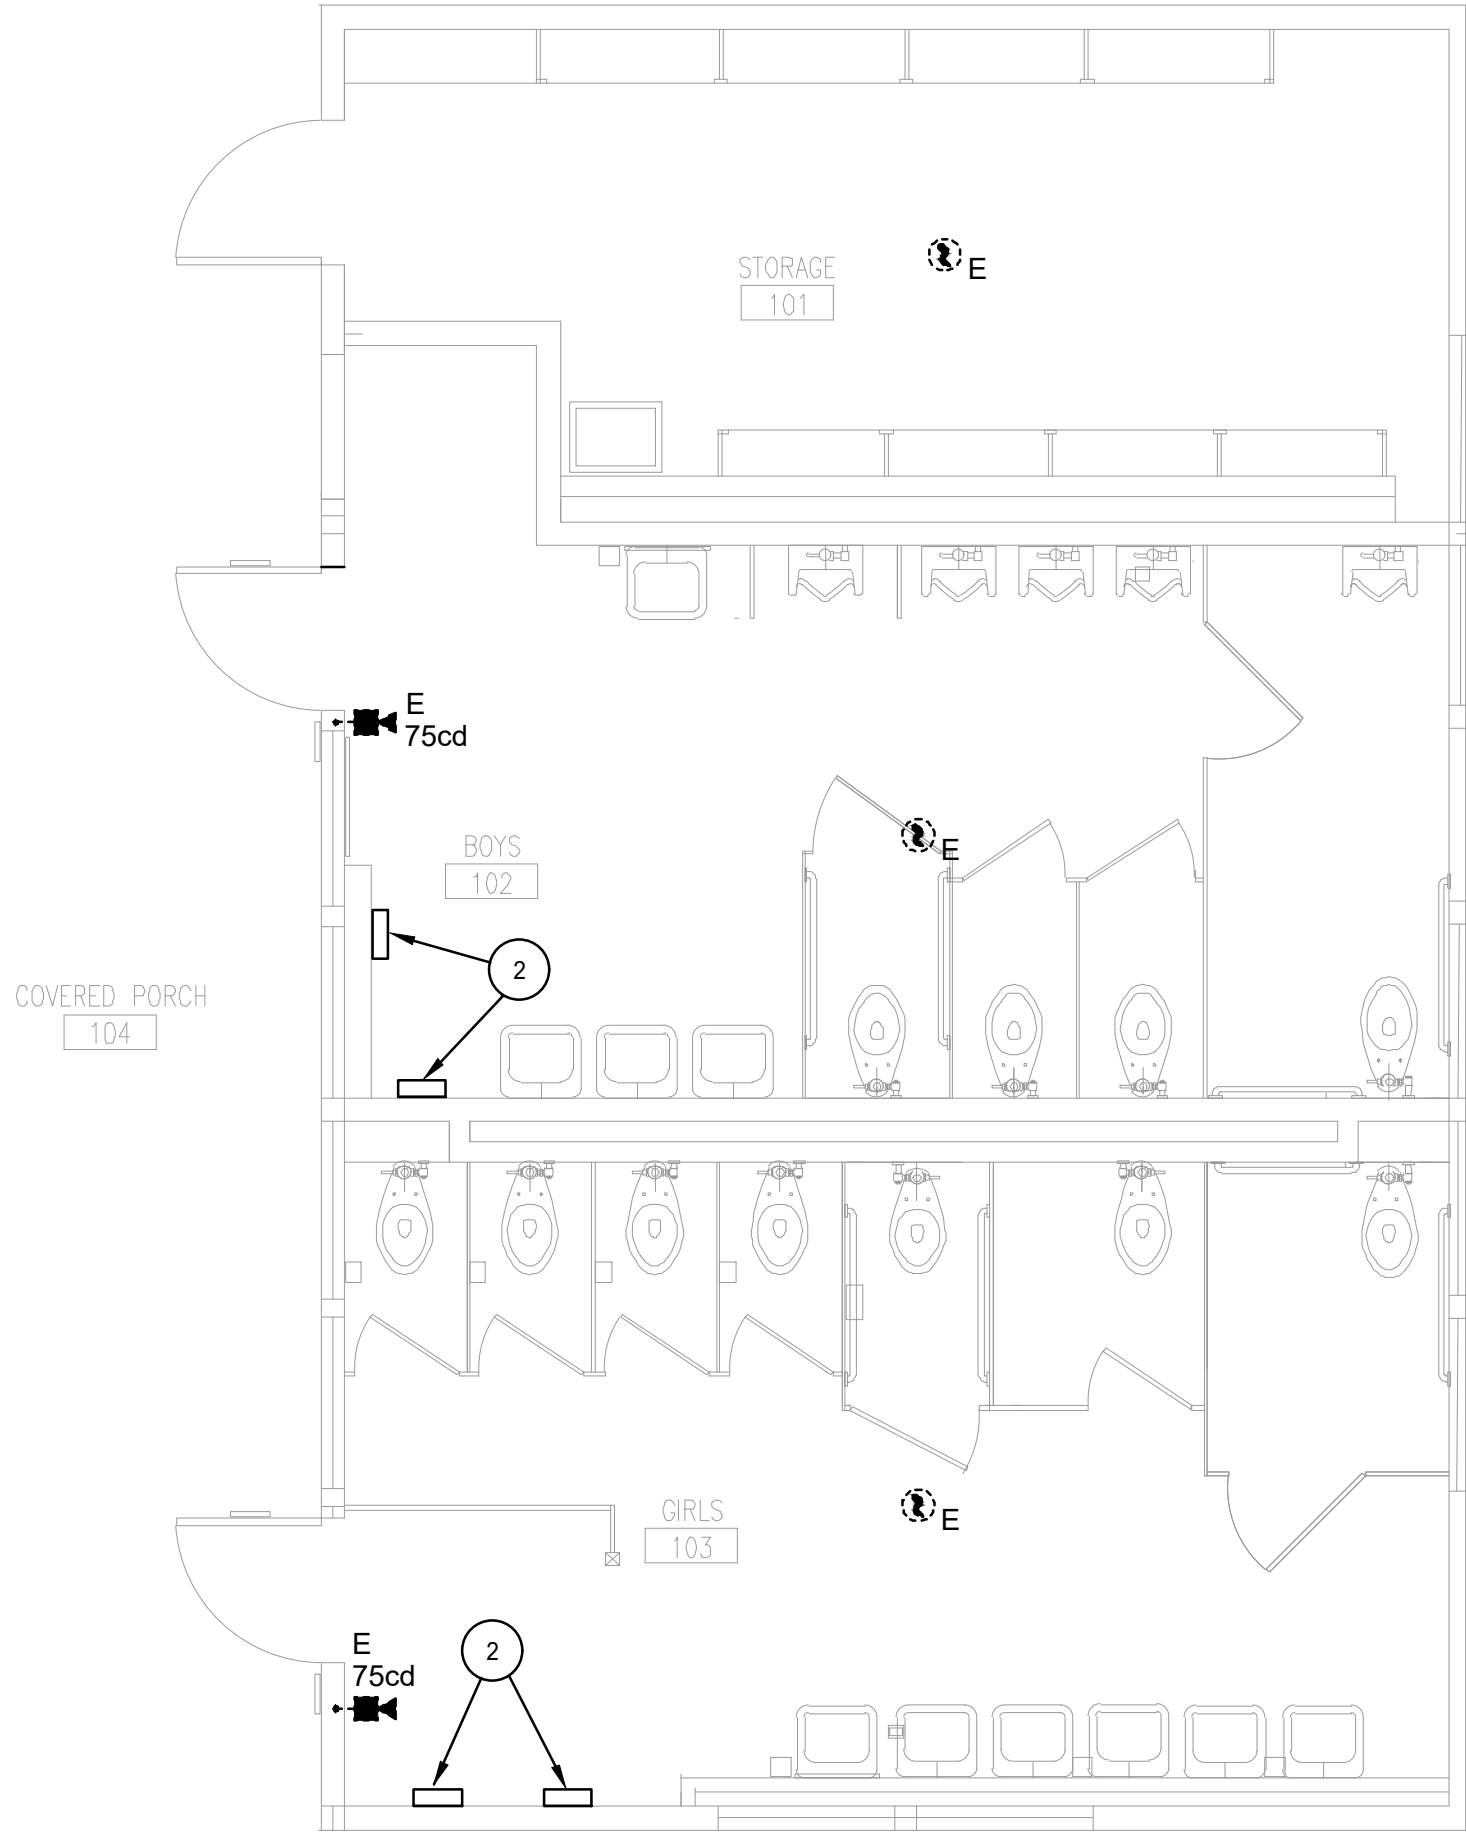

ELECTRICAL PLAN - SANITARY #2

SCALE:
1/4"=1'-0"



4

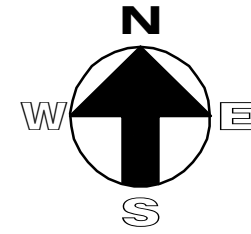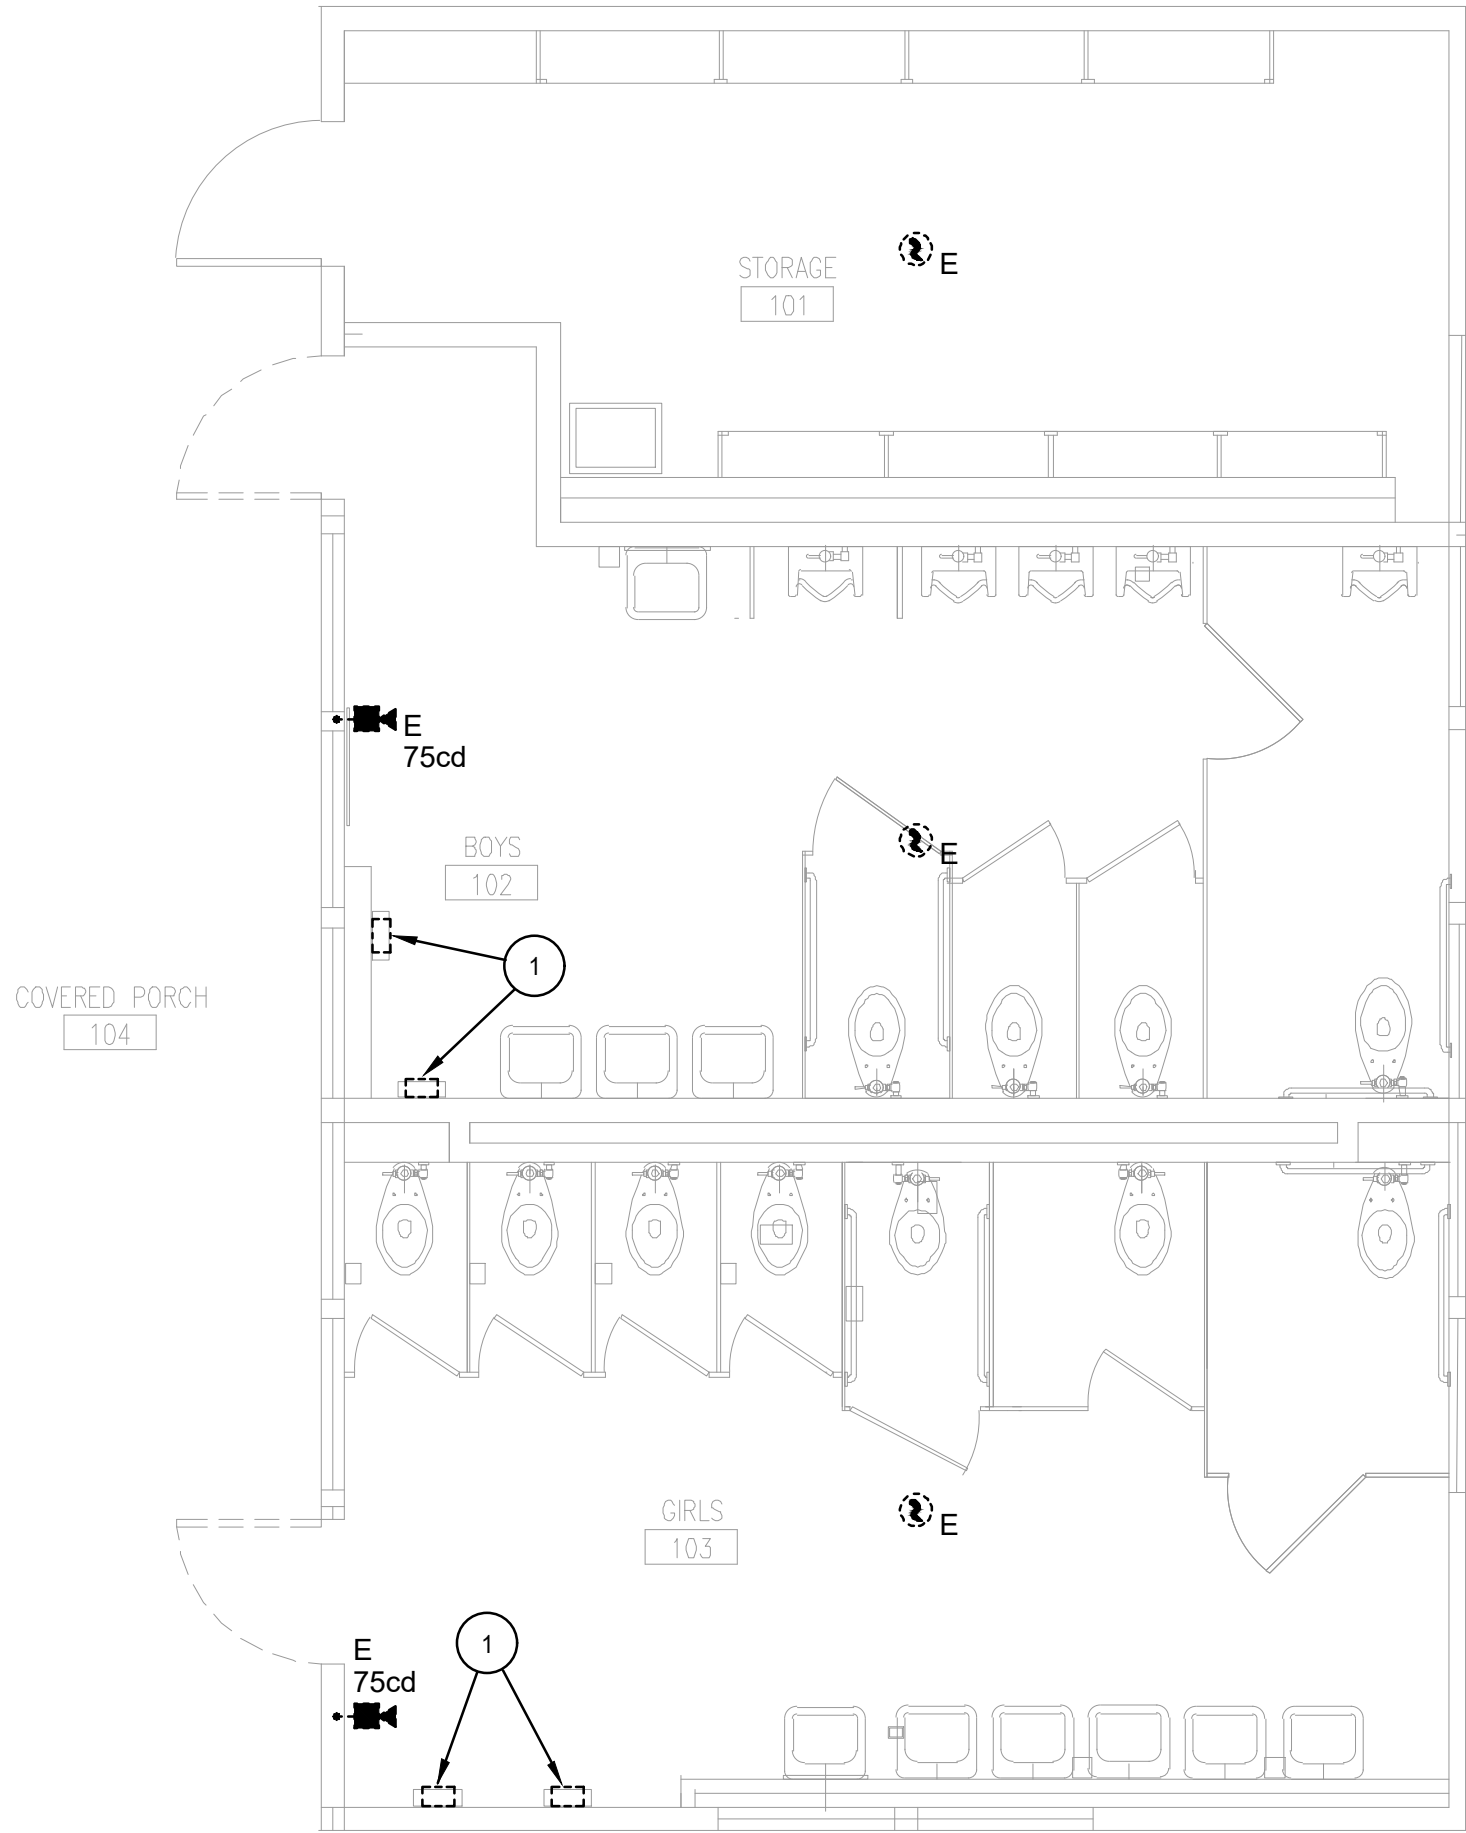

DEMO ELECTRICAL PLAN - SANITARY #2

SCALE:
1/4"=1'-0"



3

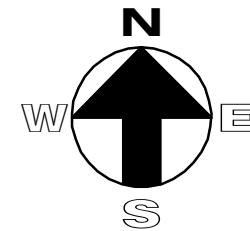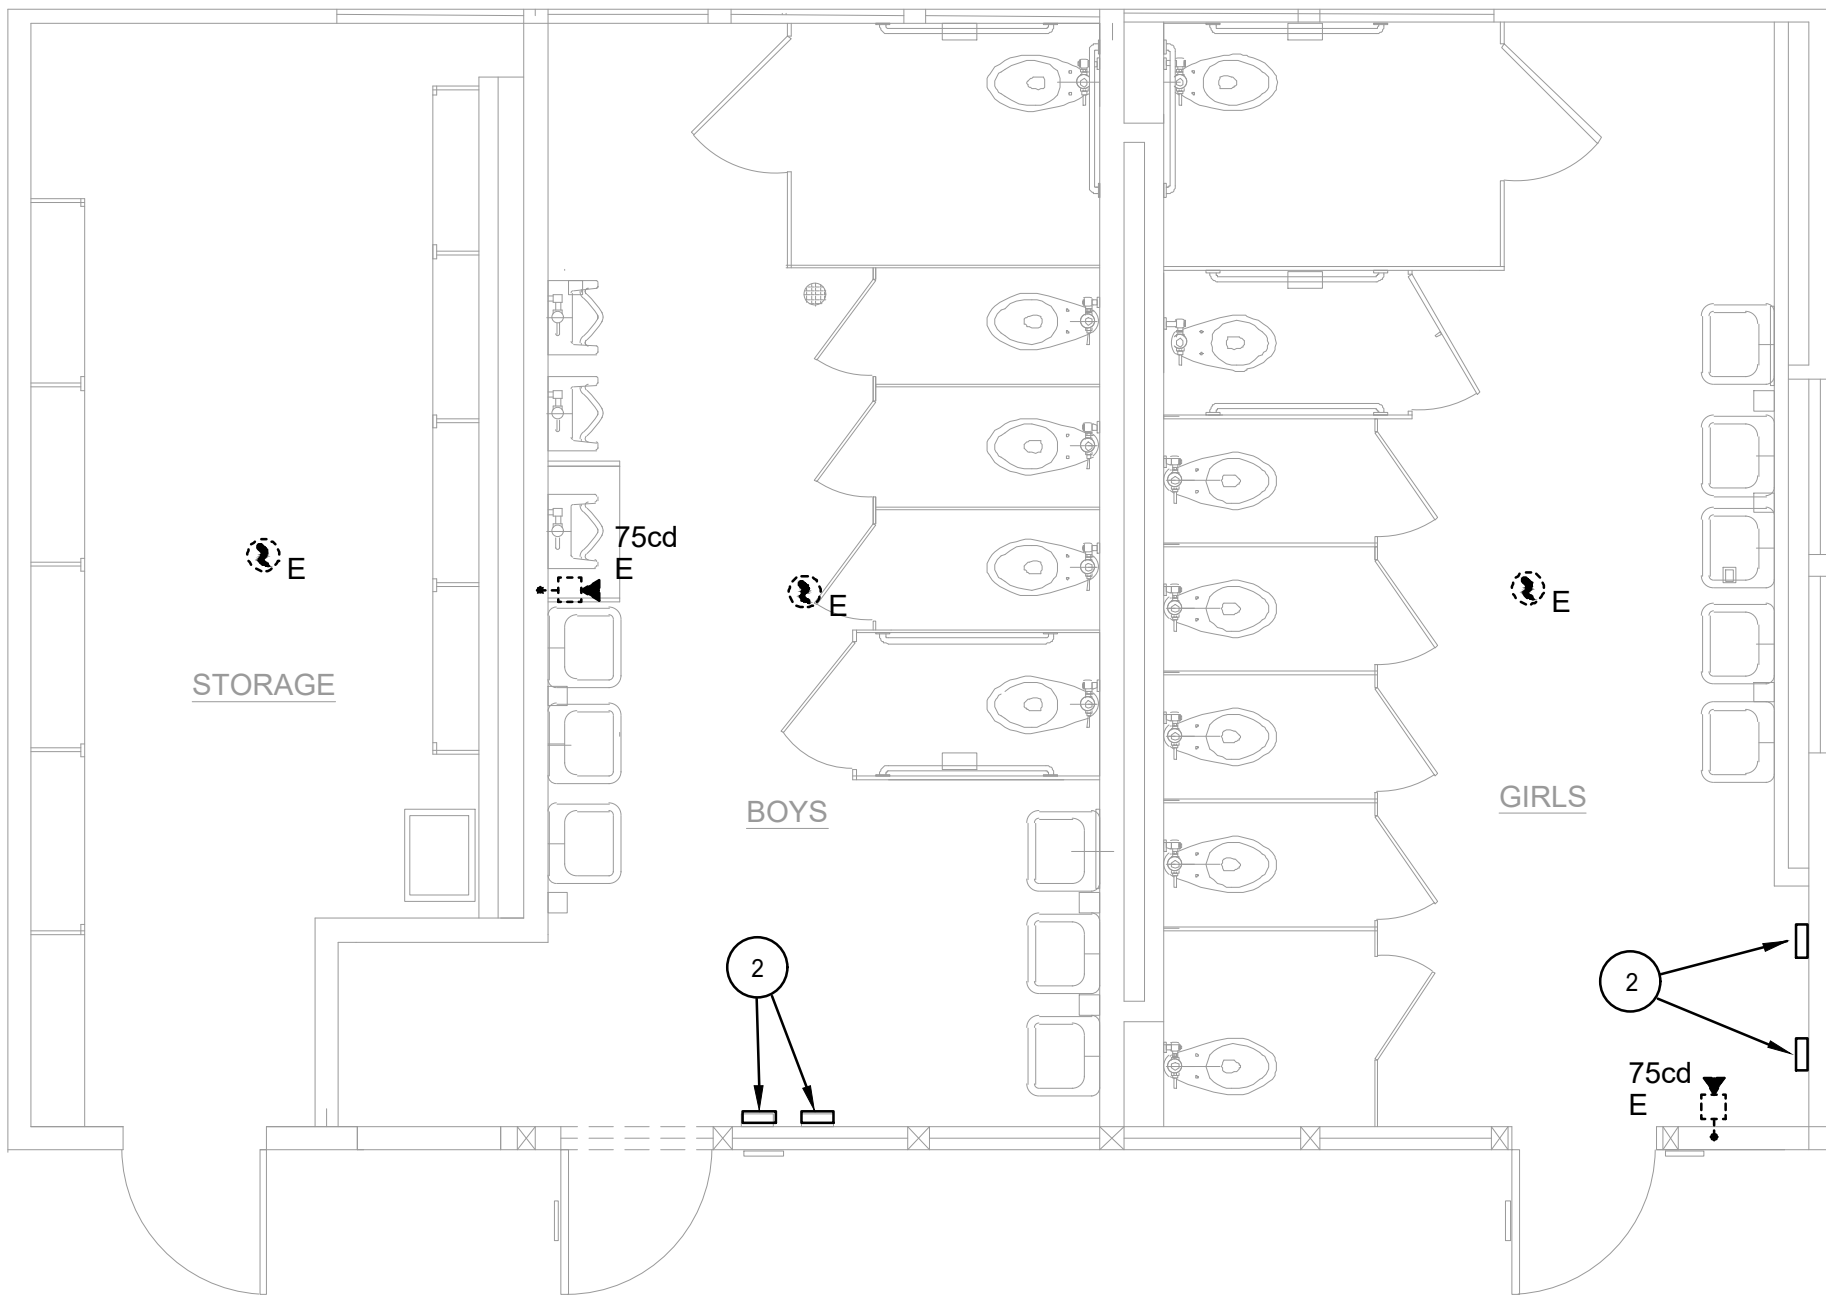

ELECTRICAL PLAN - SANITARY #1

SCALE:
1/4"=1'-0"

2

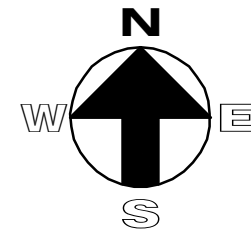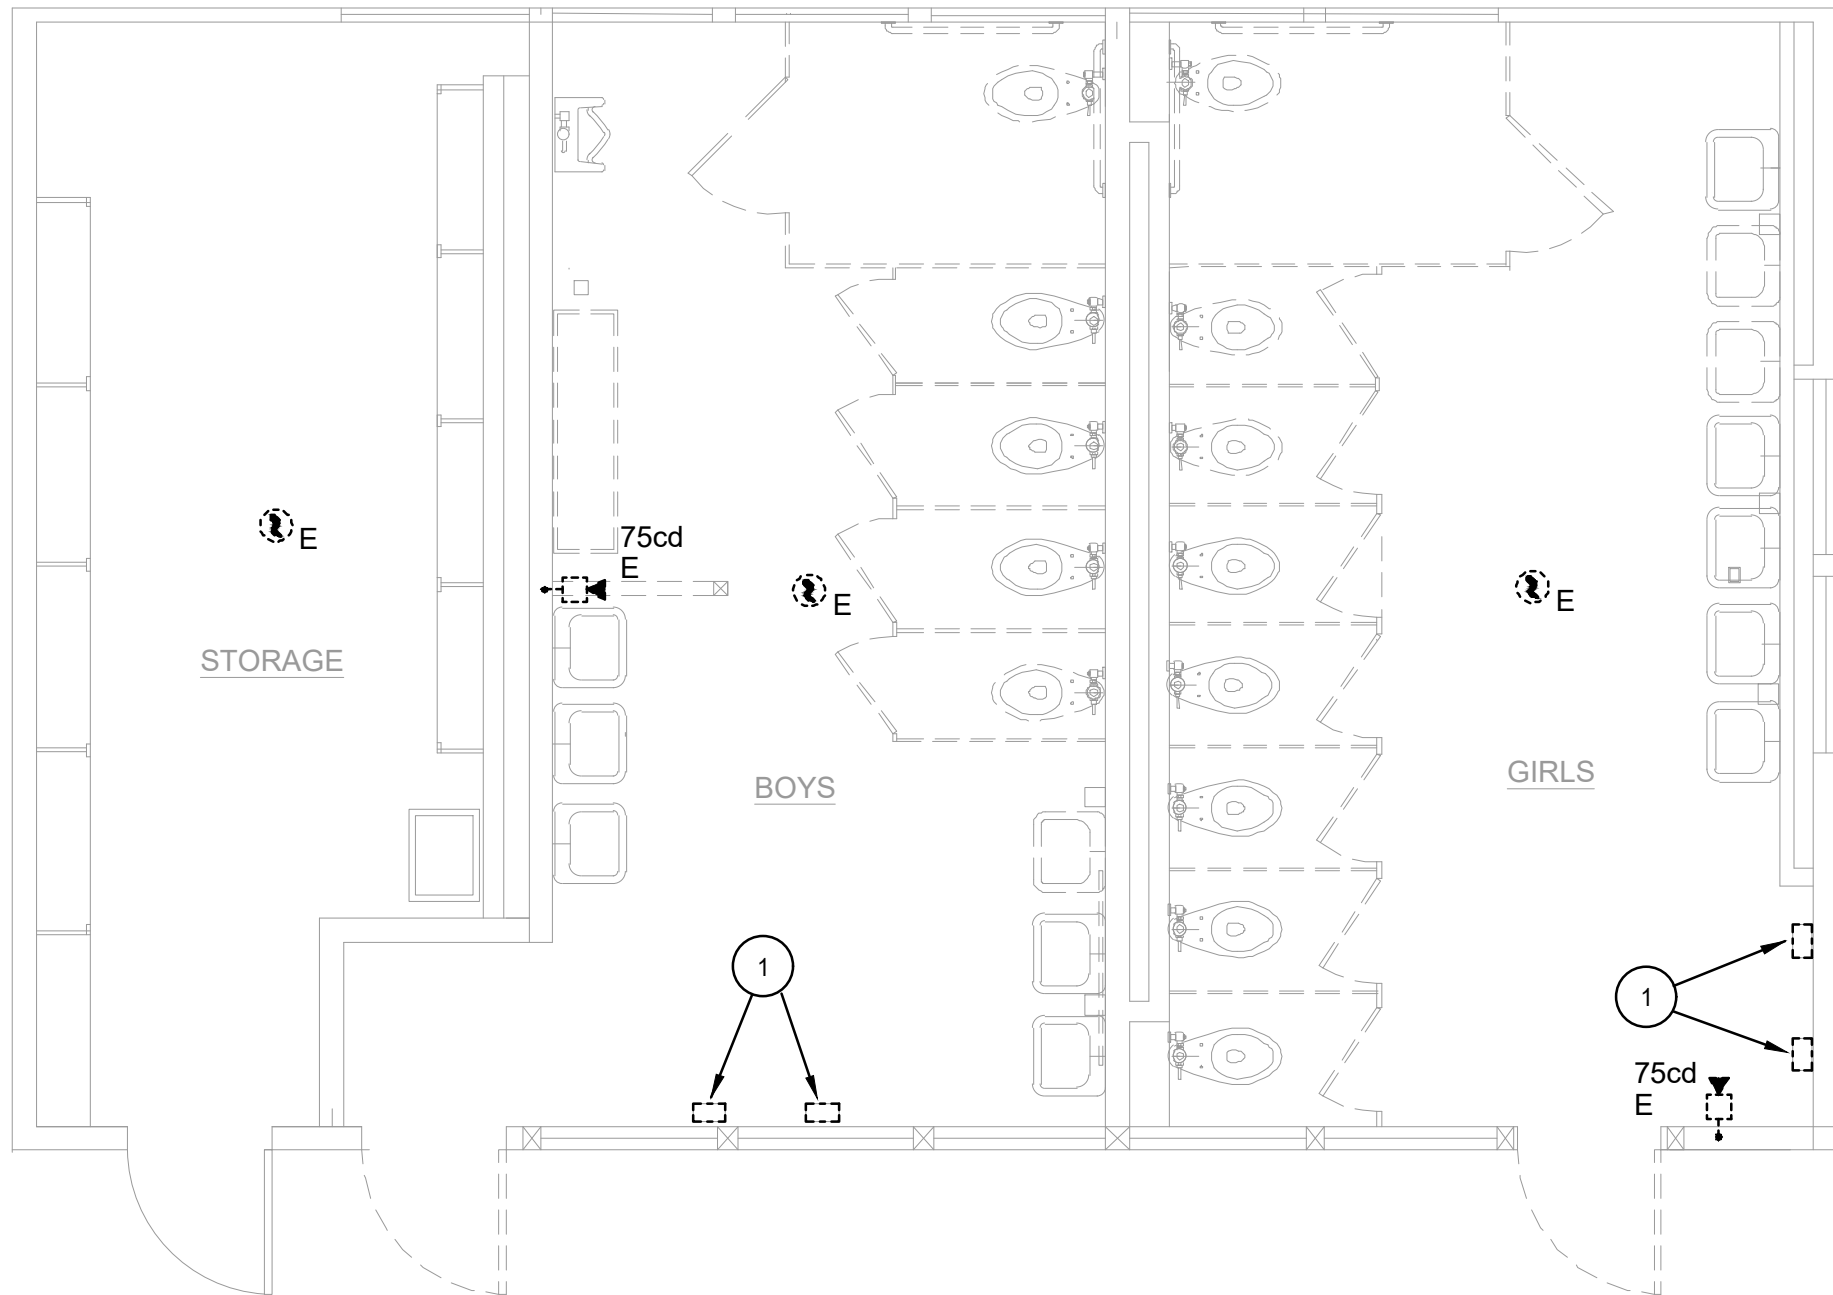

DEMO ELECTRICAL PLAN - SANITARY #1

SCALE:
1/4"=1'-0"

1

PLAN NOTES

- 1 DISCONNECT THE POWER FROM EXISTING HAND DRYER. PROTECT THE EXISTING WIRING AND JUNCTION BOX IN PLACE FOR RECONNECTION TO THE NEW HAND DRYER.
- 2 CONNECT THE NEW HAND DRYER TO THE EXISTING 120V CIRCUIT IN THE EXISTING JUNCTION BOX.

GENERAL NOTES:

1. CONTRACTOR SHALL FIELD-VERIFY AND TRACE ALL EXISTING CIRCUITS AFFECTED BY THE SCOPE OF WORK SHOWN ON THIS SHEET PRIOR TO THE START OF CONSTRUCTION. UPON COMPLETION OF THE WORK, CONTRACTOR SHALL ACCURATELY RECORD ALL CIRCUITS ON THE AS-BUILT DRAWINGS.

LEGEND:

- E EXISTING EQUIPMENT OR DEVICE TO REMAIN. CONTRACTOR SHALL RECONNECT TO EXISTING CIRCUIT IF DISCONNECTED BY DEMOLITION ON THIS PROJECT.
- R EXISTING EQUIPMENT OR DEVICE TO BE REMOVED. CONTRACTOR SHALL DISCONNECT AND REMOVE ALL ASSOCIATED CONTROLS, CONDUCTORS, AND CONDUIT AS REQUIRED.
- ER EXISTING EQUIPMENT OR DEVICE TO BE DISCONNECTED AND RELOCATED AS INDICATED ON PLANS.
- EN EXISTING EQUIPMENT OR DEVICE TO BE REMOVED AND REPLACED WITH NEW AS INDICATED ON PLANS.
- NR NEWLY RELOCATED EXISTING EQUIPMENT OR DEVICE AT LOCATION INDICATED ON PLANS.
- #/cd EXISTING VISUAL DEVICE PER A#03-110125 TO REMAIN.
- V/# EXISTING AUDIO/VISUAL DEVICE PER A#03-110125 TO REMAIN.
- E S EXISTING SMOKE DETECTOR PER A#03-110125 TO REMAIN.
- H/# EXISTING HEAT DETECTOR PER A#03-110125 TO REMAIN.
- E P EXISTING PULL STATION PER A#03-110125 TO REMAIN.



**LOS ANGELES UNIFIED
SCHOOL DISTRICT**
**ASSET MANAGEMENT
FACILITIES SERVICES DIVISION**
333 S. BEAUDRY AVENUE, 23RD FLOOR
LOS ANGELES, CALIFORNIA 90017

PROJECT TITLE AND SCHOOL LOCATION
**STRATHERN STREET
SCHOOL**
**VOLUNTARY BARRIER
REMOVAL**
7939 ST. CLAIRE AVENUE.
N. HOLLYWOOD, CA 91605
COLIN ID No.: 10373687


DSA# 03-125645

COMMISSIONED ARCHITECT



ML ARCHITECTURE
355 PASADENA AVENUE
SOUTH PASADENA, CA 91030

STAMPS/SEALS

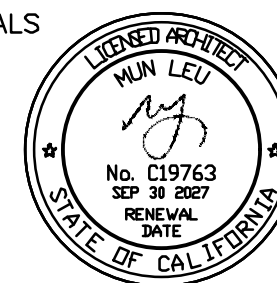


CONSULTANT


FBA Engineering

Consulting Electrical Engineers
150 Paulinho Avenue Suite A120
Costa Mesa, CA 92626
949.852.9965 • 949.852.1657 (fax)
fbagr.com

STAMPS/SEALS

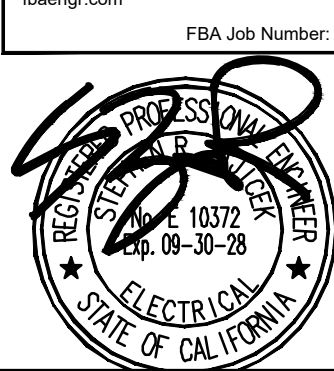

KEY PLAN

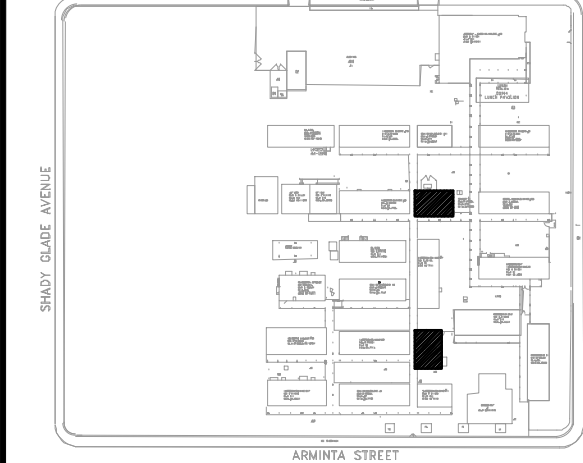

ADDENDUM 1 06/02/26

SHEET TITLE

**ENLARGED ELECTRICAL
PLANS**

PROJECT NO.: 23004 PROJECT ARCH: ML ARCHITECTURE

DRAWN: T PHAN CHECKED: MUN LEU


SHEET NUMBER

E-2.02


DATE: 10-24-2025

SHEET: OF:


FBA Engineering / Plot Date: 5/4/2026 1:33 PM / Plotted by: Brandon Nguyen / Drawing Location: L:\1137\056\E-2.03 - 1137 056 ENLARGED ELECTRICAL PLAN.dwg

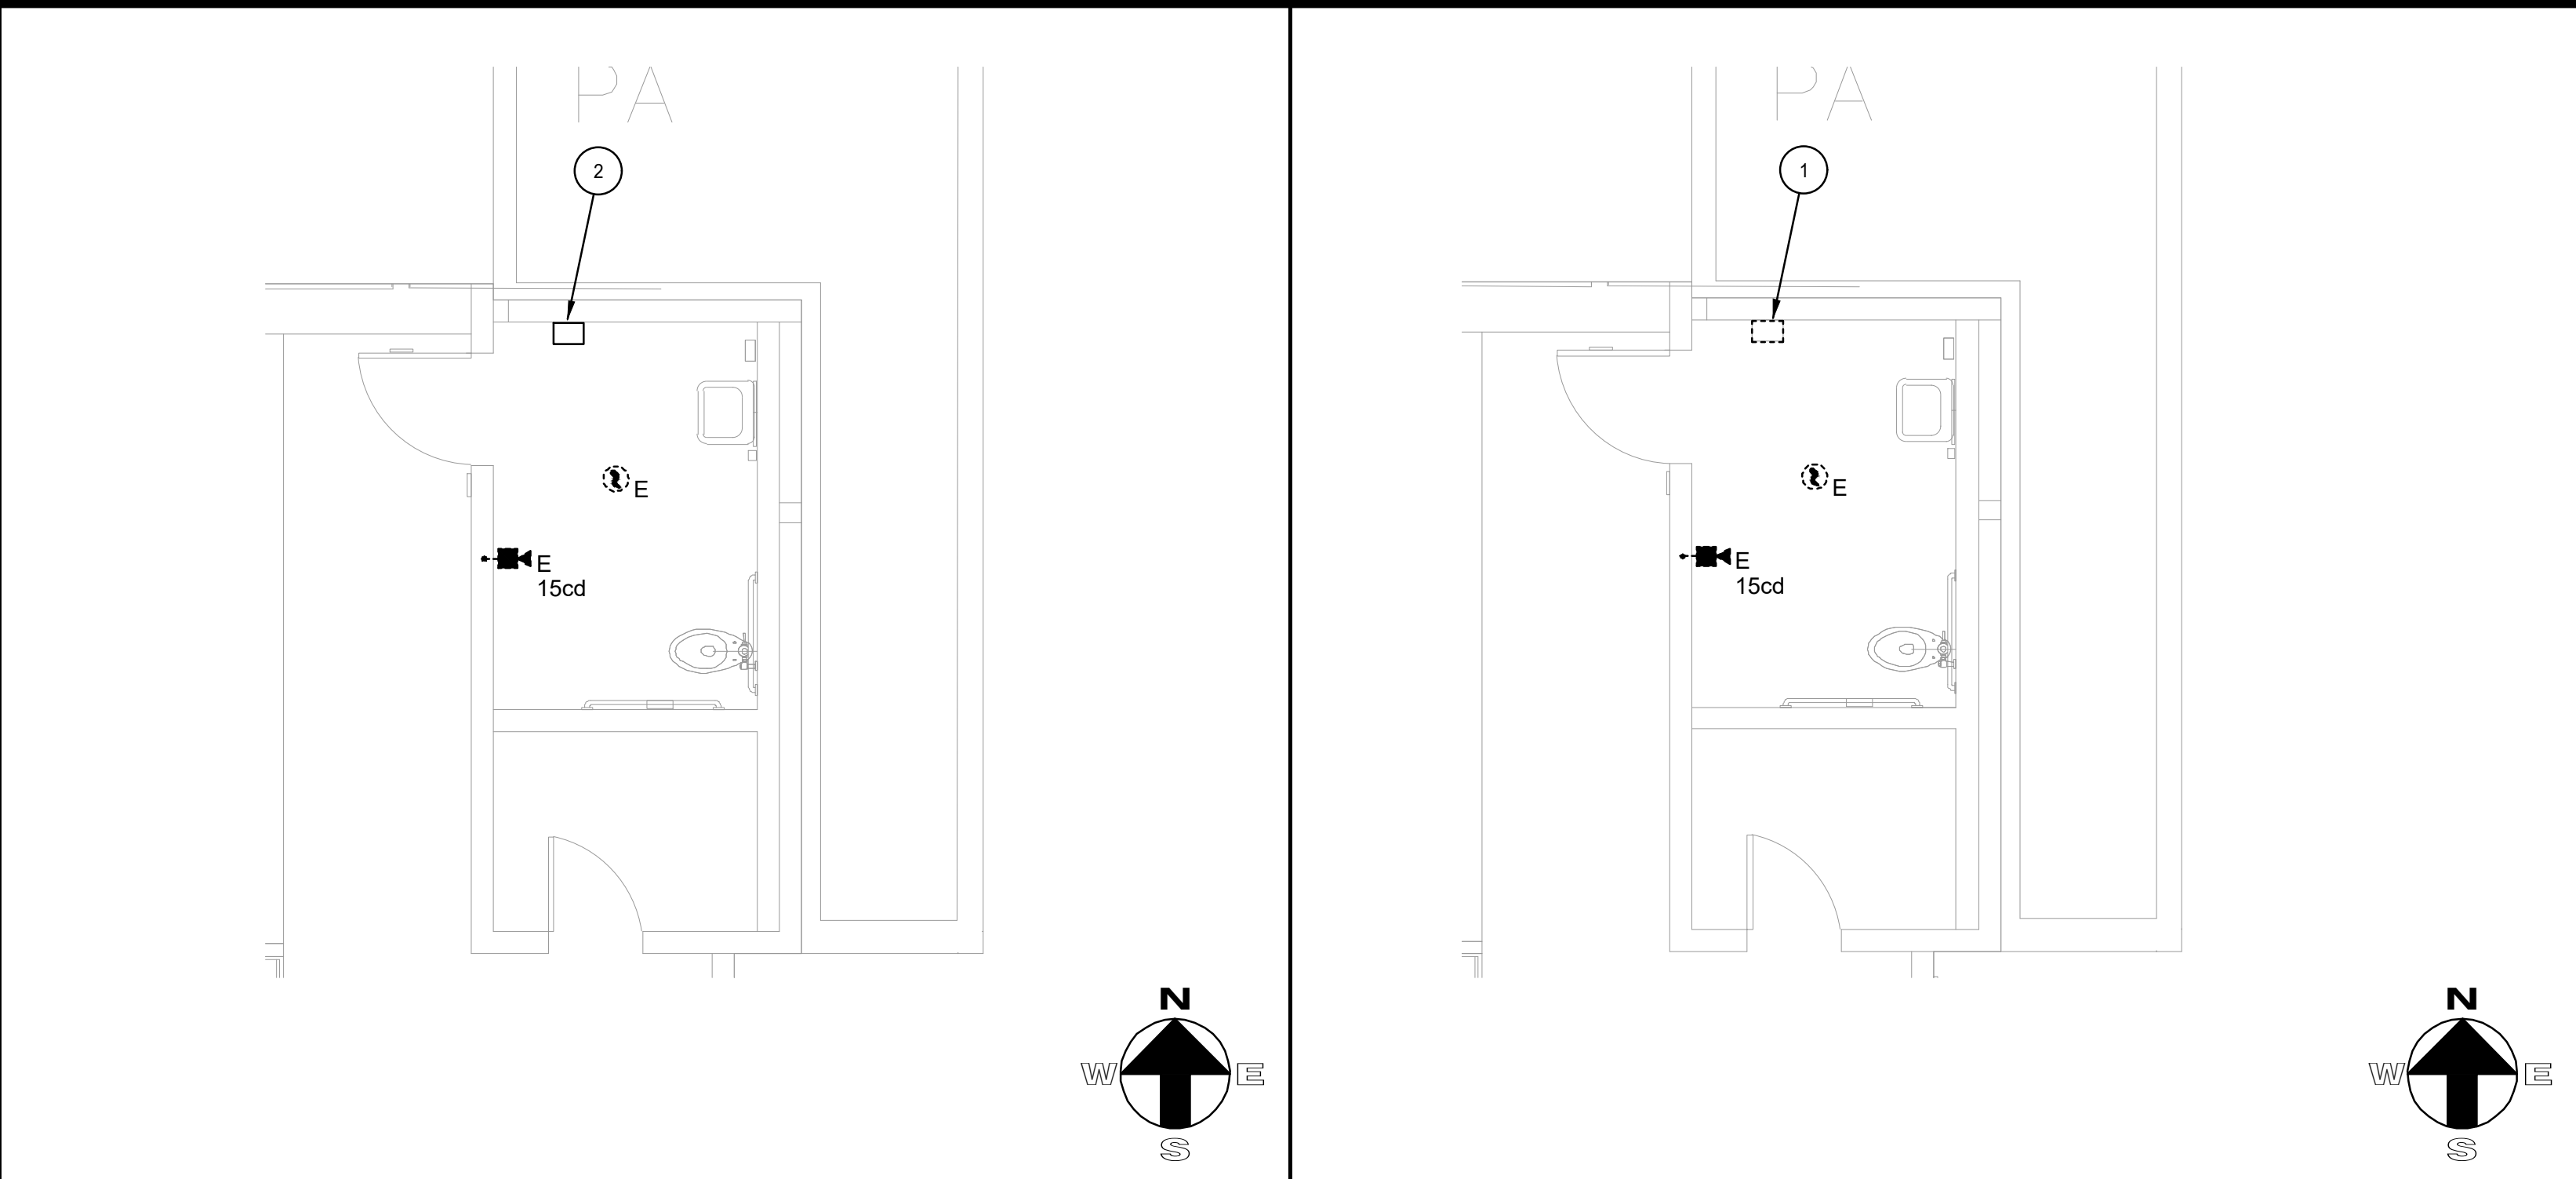

NEW FLOOR PLAN ALL GENDER 105 (ASSEMBLY BLDG. 13) SCALE: 1/4"=1'-0" 2 DEMO FLOOR PLAN ALL GENDER 105 (ASSEMBLY BLDG. 13) SCALE: 1/4"=1'-0" 1

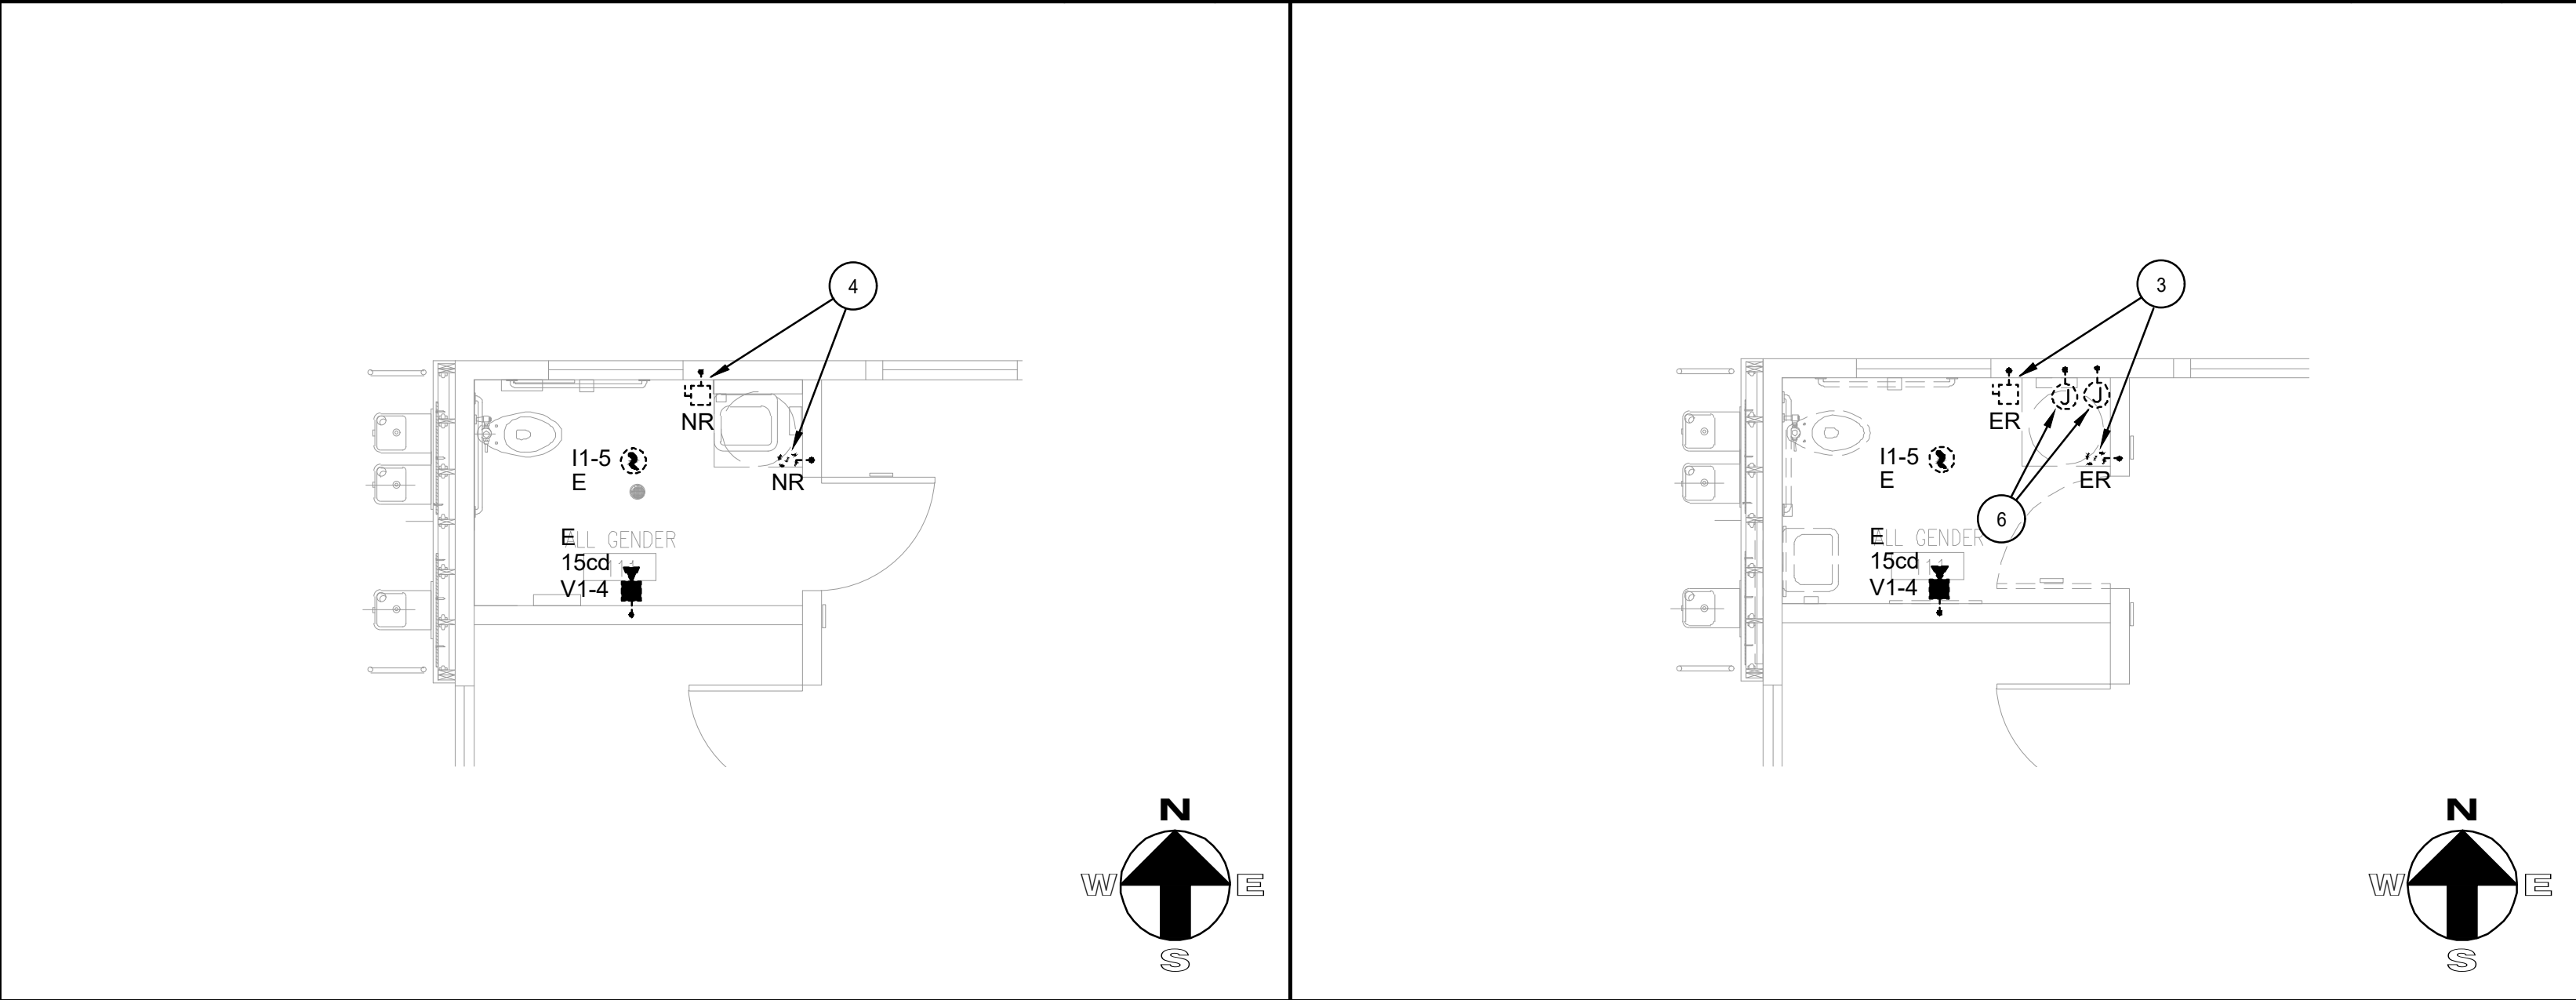

NEW FLOOR PLAN ALL GENDER 111 (ADMIN. BLDG. 1) SCALE: 1/4"=1'-0" 4 DEMO FLOOR PLAN ALL GENDER 111 (ADMIN. BLDG. 1) SCALE: 1/4"=1'-0" 3

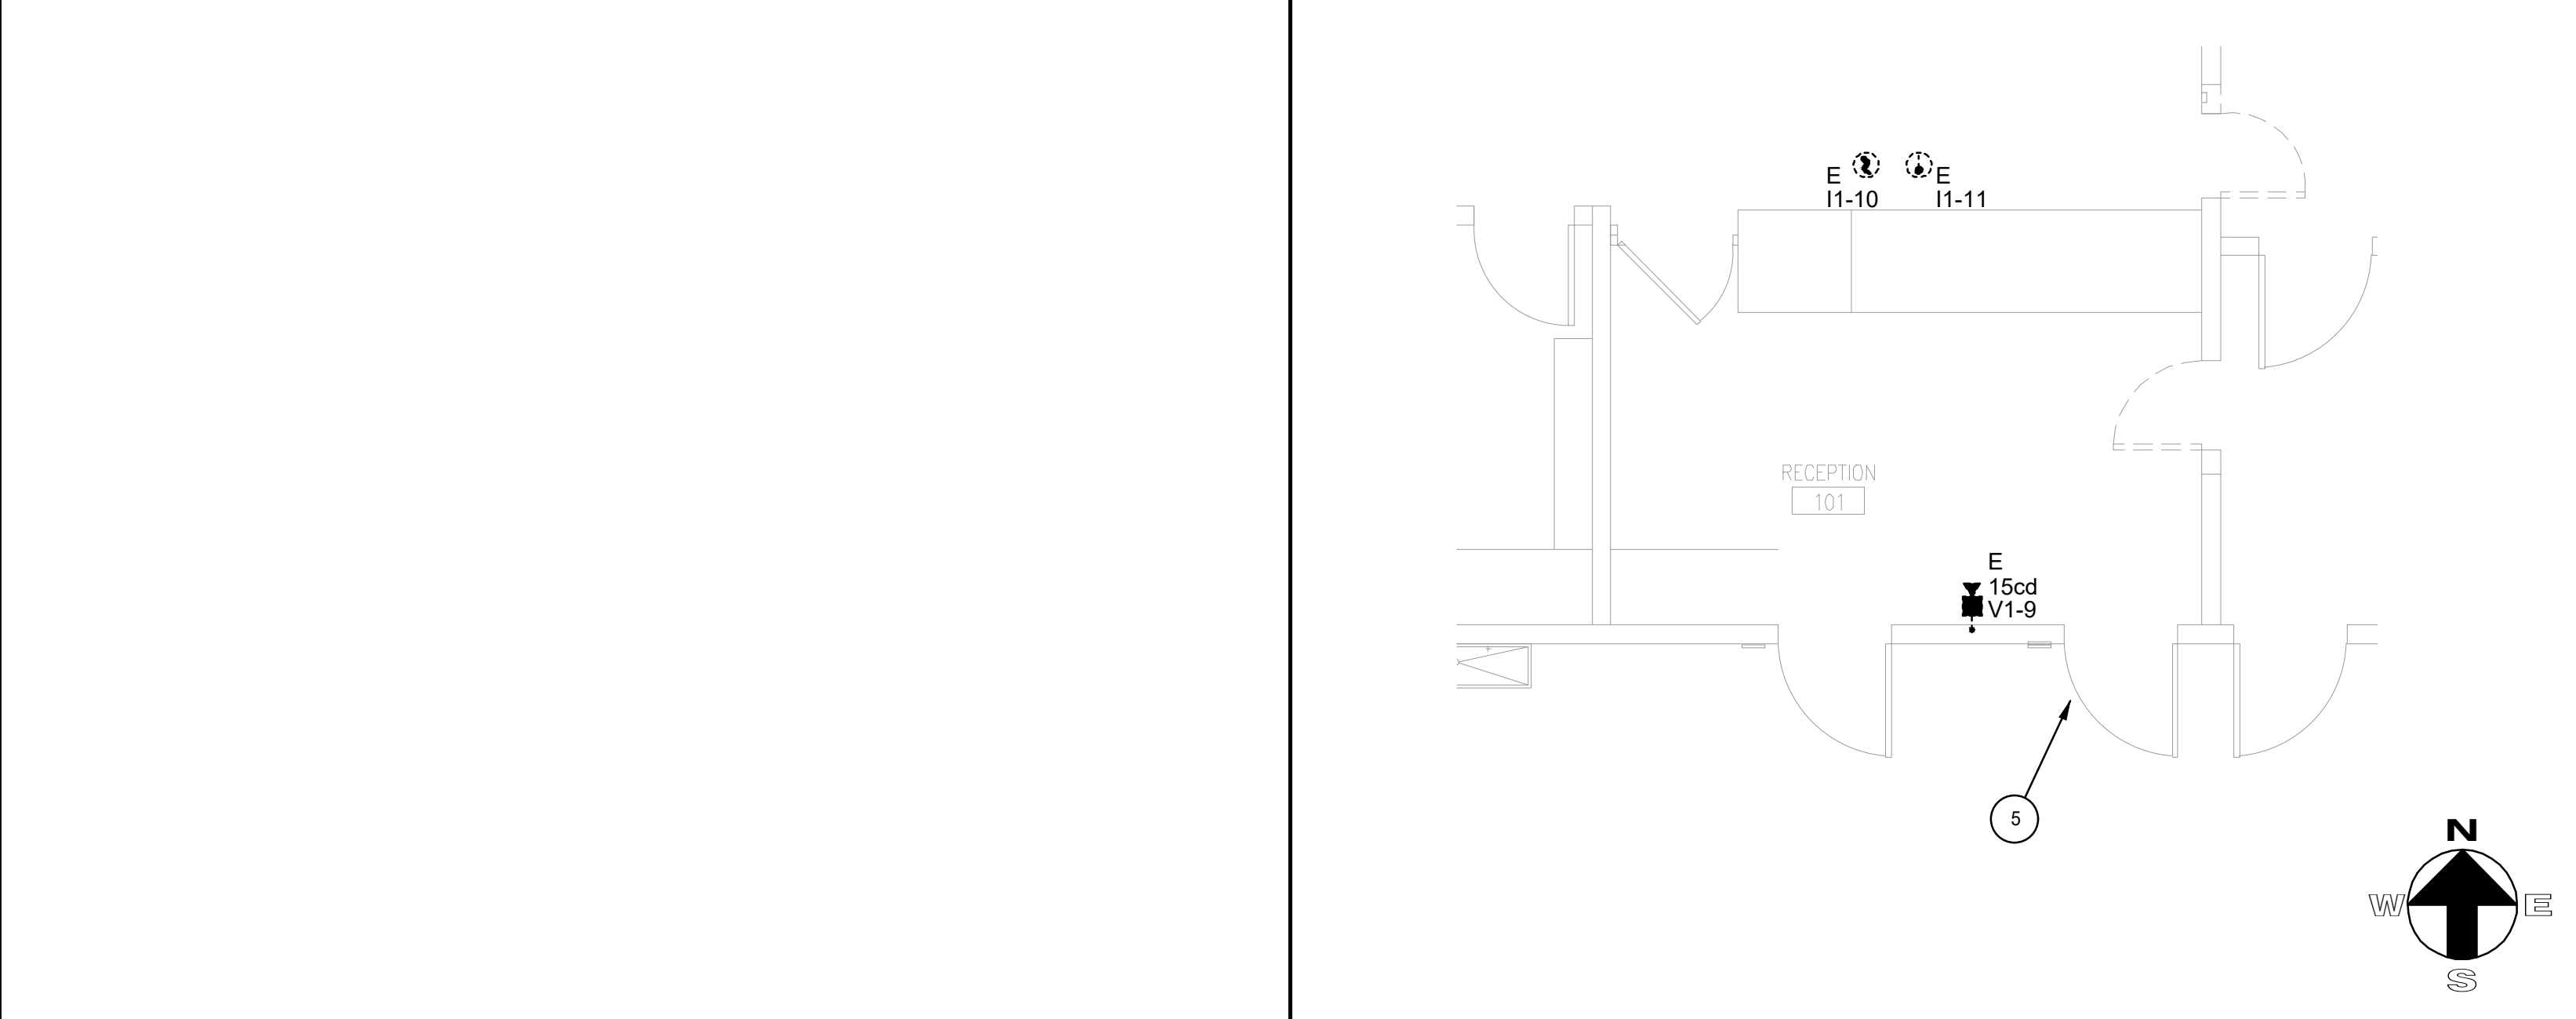

FLOOR PLAN RECEPTION 101 (ADMIN. BLDG. 1) SCALE: 1/4"=1'-0" 5

PLAN NOTES

- 1 DISCONNECT THE POWER FROM EXISTING HAND DRYER. PROTECT THE EXISTING WIRING AND JUNCTION BOX IN PLACE FOR RECONNECTION TO THE NEW HAND DRYER.
- 2 CONNECT THE NEW HAND DRYER TO THE EXISTING 120V CIRCUIT IN THE EXISTING JUNCTION BOX.
- 3 REMOVE EXISTING SWITCH FROM EXISTING WALL AND REINSTALL ON THE NEW FINISHED WALL.
- 4 REINSTALL THE SWITCH ON THE NEW FINISHED WALL.
- 5 CONNECT (E) INTERCOM TO THIS DOOR LOCATION.
- 6 CONTRACTOR SHALL EXTEND THE EXISTING JUNCTION BOXES TO THE FACE OF THE NEW WALL. PROVIDE BOX EXTENSIONS AS REQUIRED TO BRING THE BOXES FLUSH WITH THE NEW WALL SURFACE AND INSTALL NEW COVER PLATES ON THE EXTENDED BOXES.

- GENERAL NOTES:
1. CONTRACTOR SHALL FIELD-VERIFY AND TRACE ALL EXISTING CIRCUITS AFFECTED BY THE SCOPE OF WORK SHOWN ON THIS SHEET PRIOR TO THE START OF CONSTRUCTION. UPON COMPLETION OF THE WORK, CONTRACTOR SHALL ACCURATELY RECORD ALL CIRCUITS ON THE AS-BUILT DRAWINGS.

LEGEND:

- E EXISTING EQUIPMENT OR DEVICE TO REMAIN. CONTRACTOR SHALL RECONNECT TO EXISTING CIRCUIT IF DISCONNECTED BY DEMOLITION ON THIS PROJECT.
- R EXISTING EQUIPMENT OR DEVICE TO BE REMOVED. CONTRACTOR SHALL DISCONNECT AND REMOVE ALL ASSOCIATED CONTROLS, CONDUCTORS, AND CONDUIT AS REQUIRED.
- ER EXISTING EQUIPMENT OR DEVICE TO BE DISCONNECTED AND RELOCATED AS INDICATED ON PLANS.
- EN EXISTING EQUIPMENT OR DEVICE TO BE REMOVED AND REPLACED WITH NEW AS INDICATED ON PLANS.
- NR NEWLY RELOCATED EXISTING EQUIPMENT OR DEVICE AT LOCATION INDICATED ON PLANS.
- candela rating
- #cd EXISTING VISUAL DEVICE PER A#03-110125 TO REMAIN.
- device number
- notification device circuit number
- candela rating
- #cd EXISTING AUDIO/VISUAL DEVICE PER A#03-110125 TO REMAIN.
- device number
- notification device circuit number
- E EXISTING SMOKE DETECTOR PER A#03-110125 TO REMAIN.
- device number
- loop number
- E EXISTING HEAT DETECTOR PER A#03-110125 TO REMAIN.
- device number
- loop number
- E EXISTING PULL STATION PER A#03-110125 TO REMAIN.
- device number
- loop number



LOS ANGELES UNIFIED SCHOOL DISTRICT
ASSET MANAGEMENT
FACILITIES SERVICES DIVISION

333 S. BEAUDRY AVENUE, 23RD FLOOR
LOS ANGELES, CALIFORNIA 90017

PROJECT TITLE AND SCHOOL LOCATION
STRATHERN STREET
SCHOOL
VOLUNTARY BARRIER
REMOVAL

7939 ST. CLAIRE AVENUE.
N. HOLLYWOOD, CA 91605
COLIN ID No.: 10373687


DSA# 03-125645

COMMISSIONED ARCHITECT

MLA

ML ARCHITECTURE
355 PASADENA AVENUE
SOUTH PASADENA, CA91030

STAMPS/SEALS

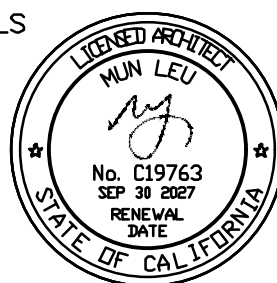

CONSULTANT


FBA Engineering

Consulting Electrical Engineers


150 Paulmar Avenue Suite A120
Costa Mesa, CA 92626
949.852.9965 • 949.852.1657 (fax)
fbasengr.com

STAMPS/SEALS

FBA Job Number: 1137 056

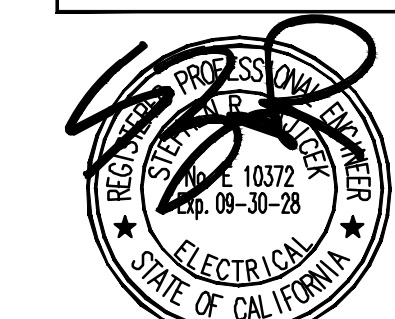

KEY PLAN

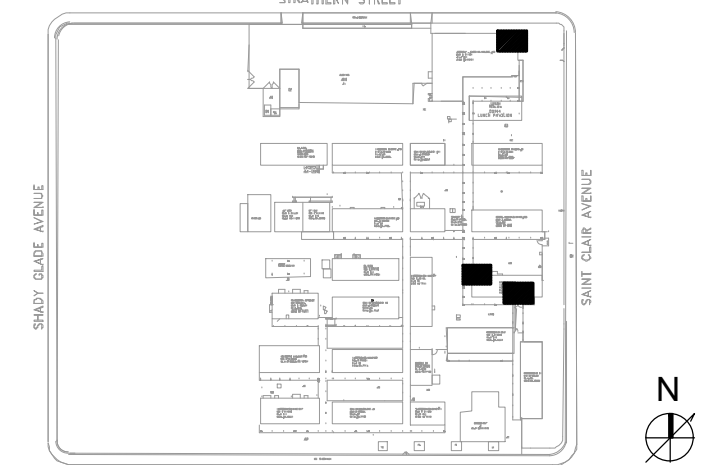

ADDENDUM 1 06/02/26

SHEET TITLE

ENLARGED
ELECTRICAL
PLANS

PROJECT NO.: 23004 PROJECT ARCH: ML ARCHITECTURE

DRAWN: T PHAN CHECKED: MUN LEU

SHEET NUMBER

E-2.03

DATE: 10-24-2025

SHEET: OF: